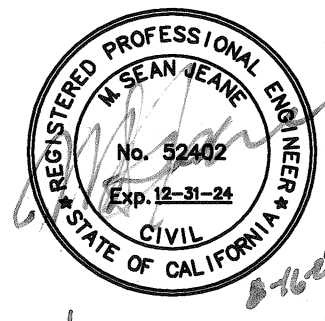




B STREET AND 3RD STREET RIGHT TURN POCKET IMPROVEMENTS

Brelje & Race
CONSULTING ENGINEERS
475 Aviation Blvd. • Suite 120 • Santa Rosa, CA 95403 • 707-576-1322
www.brce.com



1. ALL WORKMANSHIP, MATERIALS AND CONSTRUCTION SHALL CONFORM TO THE CITY OF SANTA ROSA STANDARD PLANS, THE CONSTRUCTION SPECIFICATIONS FOR PUBLIC IMPROVEMENTS, THE SPECIAL PROVISIONS FOR THIS PROJECT AND THE STATE STANDARD SPECIFICATIONS AND STANDARD PLANS. THE CONTRACTOR IS RESPONSIBLE FOR UNDERSTANDING ALL STANDARDS PERTAINING TO THIS PROJECT.
2. THE CONTRACTOR SHALL CALL UNDERGROUND SERVICE ALERT (USA) AT 1-800-227-2600 NO LESS THAN 2 WORKING DAYS PRIOR TO ANY EXCAVATION FOR MARK OUTS OF EXISTING UNDERGROUND FACILITIES IN ACCORDANCE WITH SECTION 5-1.36E OF THE SPECIAL PROVISIONS.
3. THE LOCATIONS OF UNDERGROUND UTILITIES AND OTHER OBSTACLES SHOWN ON THE PLANS ARE BASED ON THE BEST AVAILABLE INFORMATION. THE CONTRACTOR SHALL POTHOLE AND DETERMINE THE EXACT LOCATION OF ALL POTENTIAL CONFLICTS IN ACCORDANCE WITH U.S.A. LAWS AND THESE SPECIAL PROVISIONS AND THE STANDARD SPECIFICATIONS. IF ANY UNMARKED UTILITIES ARE ENCOUNTERED, OR IF UNABLE TO LOCATE A MARKED UTILITY AFTER POT HOLING, THE CONTRACTOR SHALL IMMEDIATELY NOTIFY THE OWNER OF THAT UTILITY AND THE ENGINEER.
4. ALL SEWER MANHOLES, MAINLINE CLEANOUTS AND WATER VALVES THAT ARE ON ACTIVE SYSTEMS SHALL BE ACCESSIBLE TO CITY PERSONNEL AT ALL TIMES AND SHALL BE BROUGHT TO GRADE WITHIN 48 HOURS OF PAVING.
5. THE CONTRACTOR SHALL PROTECT AND PRESERVE CITY MONUMENTS. THE CONTRACTOR SHALL COORDINATE WITH THE CITY ENGINEER 10 WORKING DAYS IN ADVANCE FOR REFERENCING OF EXISTING MONUMENTS TO BE DISTURBED. THE CONTRACTOR SHALL RECONSTRUCT DISTURBED MONUMENTS IN ACCORDANCE WITH CITY STANDARD 280.
6. OVERHEAD UTILITY SERVICE DROPS ARE NOT SHOWN ON THE PLANS. THE CONTRACTOR SHALL INVESTIGATE THE SITE AND BE AWARE OF LIMITED CLEARANCES UNDER OVERHEAD UTILITY LINES AND LOW HANGING TREE BRANCHES. THE CONTRACTOR'S TRUCKS AND EXCAVATION EQUIPMENT SHALL BE SIZED SO THAT OVERHEAD WIRES AND TREE BRANCHES ARE NOT DAMAGED.
7. ALL EXCAVATED MATERIAL SHALL BE DISPOSED OF AS GENERATED AND AT NO TIME SHALL THE CONTRACTOR PLACE EXCAVATED MATERIAL AT THE WORK SITE.
8. THE CONTRACTOR SHALL ONLY REMOVE EXISTING TREES OR SHRUBS AS NOTED ON THE PLANS OR AS DIRECTED BY THE ENGINEER.
9. FOR CLARITY OF EXISTING SUBSURFACE CONDITIONS, NOT ALL CROSSWALKS, STOP BARS, OR EXISTING PAVEMENT MARKINGS ARE SHOWN ON THE PLANS. TRAFFIC STRIPES, RAISED PAVEMENT MARKERS AND PAVEMENT MARKINGS DAMAGED DUE TO THE CONTRACTOR'S OPERATIONS SHALL BE REPLACED PER CITY OF SANTA ROSA TRAFFIC STANDARDS PART III, TRAFFIC MARKINGS. PATCHING OF DAMAGED MARKINGS WILL NOT BE ALLOWED WITHOUT PRIOR APPROVAL FROM THE ENGINEER. ALL DAMAGED RAISED PAVEMENT (NON-REFLECTIVE) MARKERS MUST BE CERAMIC.



NOT TO SCALE



NOT TO SCALE

SHEET NO	DESCRIPTION
1	COVER
2	ABBREVIATIONS, LEGEND, SHEET LAYOUT & SURVEY CONTROL
3	DEMOLITION PLAN
4	GRADING AND UTILITY PLAN
5	SIDEWALK & CURB RAMP GRADING & DETAILS
6	SIGNING & STRIPING PLAN
7	DETAILS
8	TRAFFIC SIGNAL MODIFICATION
9	TRAFFIC SIGNAL SCHEDULES
10	STREET LIGHTING MODIFICATION
11	SIDEWALK AND CURB RAMP ELECTRICAL DETAILS

Design/Const		
Survey	<i>Done</i>	10/6/94
TPW Field Svc's		
Utilities Op's		
Traffic	<i>AKB</i>	10/16/94
Parks		
Storm Water		
DEPT	SIGNATURE	DATE

[illegible]

SCALE: AS SHOWN	DATE: JULY 2024
DWN BY: PIT	CHK BY: MSJ
APPROVED: <i>[Signature]</i> Director of Transportation and Public Works	
By <i>[Signature]</i>	Date: 06/27/24
Dan Hennessey	

City of Santa Rosa		B STREET AND 3RD STREET RIGHT TURN POCKET IMPROVEMENTS		COVER
CONTRACT NO. C02408				
SHEET	1	OF	11	
FILE NO. 2023-0025				

PROJECT START:	WATER SERVICE TYPE:
PROJECT END:	MANUFACTURER:
GEN. CONTRACTOR:	FIRE HYDRANT TYPE:
SUPERINTENDENT:	MANUFACTURER:
UNDERGROUND	INSPECTOR:
CONTRACTOR	CONSTRUCTION
FOREMAN:	MANAGER:
SEWER PIPE TYPE:	RECORD PLANS BY:
MANUFACTURER:	
SEWER FITTINGS	ADDITIONAL INFO:
MANUFACTURER:	
M.H. MANUFACTURER:	
WATER PIPE TYPE:	
MANUFACTURER:	
WATER VALVE	
MANUFACTURER:	
WATER FITTINGS	
MANUFACTURER:	

BEFORE EXCAVATING
CALL U.S.A.
UNDERGROUND SERVICE ALERT
800-642-2444
TWO WORKING DAYS BEFORE ALL
PLANNED WORK OPERATIONS

FINAL PAY ITEM(S)
Bid Item #9 - Roadway Excavation - 250CY

ABBREVIATIONS

AB	AGGREGATE BASE	MH	MANHOLE
ABAN	ABANDONED	MIN	MINIMUM
ABS	ACRYLONITRILE-BUTADIENE-STYRENE	MISC	MISCELLANEOUS
AC	ASPHALT CONCRETE	MI	MECHANICAL JOINT
ACP	ASBESTOS CEMENT PIPE	MON	MONUMENT
AD	ALGEBRAIC DIFFERENCE	MSL	MEAN SEA LEVEL
ADA	AMERICANS WITH DISABILITIES ACT	N	NORTH
ADPT	ADAPTER	NG	NATURAL GROUND
AGG	AGGREGATE	NO.	NUMBER
ALUM	ALUMINUM	NA	NOT APPLICABLE
ANG	ANGLE	NI	NOT IN CONTRACT
AP	ANGLE POINT	NPT	NATIONAL PIPE THREAD
APN	ASSESSORS PARCEL NUMBER	OC	ON CENTER
APPROX	APPROXIMATE	OD	OUTSIDE DIAMETER
ARV	AIR RELEASE VALVE	OH	OVERHEAD
AVE	AVENUE	OZ	OUNCE
AVG	AVERAGE	PA	PLANTER AREA
BC	BEGIN HORIZONTAL CURVE	PB	PULL BOX
BFP	BACKFLOW PREVENTER	PC	POINT OF CURVATURE
BLDG	BUILDING	PCC	POINT OF COMPOUND CURVATURE
BLVD	BULEVARD	PCC	PORTLAND CEMENT CONCRETE
BM	BENCHMARK	PD	PLANTER DRAIN
BO	BLOWOFF	PE	PLAIN END
BOC	BACK OF CURB	PEC	PHOTOELECTRIC CELL
BV	BUTTERFLY VALVE	PED	PEDESTRIAN
BVC	BEGIN VERTICAL CURVE	PG	PAD GRADE
BSW	BACK OF SIDEWALK	PI	POINT OF INTERSECTION
BT	BOTTOM OF TAPER	PV	POST INDICATOR VALVE
B&R	BRELJE & RACE	PL	PROPERTY LINE
C	CONDUIT	PN	PAVING NOTCH
CAV	COMBINATION AIR AND VACUUM RELEASE VALVE	PCC	POINT OF CONNECTION
CB	CATCH BASIN	PCC	POINT ON CURVE
CBC	CALIFORNIA BUILDING CODE	PCCC	POINT OF COMPOUND CURVE
CD	CONTROLLED DENSITY FILL	PCCV	POINT ON VERTICAL CURVE
CHK	CHECK	POS	PRIVATE OPEN SPACE
CIP	CAST IRON PIPE	POT	POINT ON TANGENT
CIPP	CAST-IN-PLACE PIPE	PP	POWER POLE
C	CENTERLINE	PRC	POINT OF REVERSE CURVATURE
CL	CENTERLINE	PRV	PRESSURE REDUCING VALVE
CL	CLASS	PSD	PERFORATED SUBDRAIN
CLR	CLEAR	PSI	POUND PER SQUARE INCH
CMP	CORRUGATED METAL PIPE	PSV	PRESSURE SUSTAINING VALVE
OMPA	CORRUGATED METAL PIPE ARCH	PT	POINT OF TANGENCY
CMU	CONCRETE MASONRY UNIT	PUE	PUBLIC UTILITY EASEMENT
COAX	COAXIAL CABLE	PVC	POLYVINYL CHLORIDE
CONC	CONCRETE	PVI	POINT OF VERTICAL INTERSECTION
COND	CONDUIT	PVMT	PAVEMENT
CONST	CONSTRUCTION	PWE	PUBLIC WATER EASEMENT
CONT	CONTINUOUS	R	RAW
COTG	CLEANOUT TO GRADE	RAW	RAW WATER
CT	COURT	RC	RELATIVE COMPACTION
CPLG	COUPLING	RCB	REINFORCED CONCRETE BOX
CR	CURB RETURN	RCP	REINFORCED CONCRETE PIPE
CSP	CORRUGATED STEEL PIPE	RD	ROAD
CT	CEMENT TREATED BASE	RED	REDUCER
CTB	CEMENT TREATED BASE	REF	REFERENCE
CTR	CENTER	ROW	RIGHT OF WAY
CY	CUBIC YARD	RBP	REDUCED PRESSURE BACKFLOW PREVENTER
C/C	CENTER TO CENTER	RPM	RAISED PAVEMENT MARKER
C&G	CURB AND GUTTER	RSC	REMOTE SUPERVISORY CONTROL
DBL	DOUBLE	RT	RIGHT
DDC	DOUBLE CHECK DETECTOR CHECK	RT	RING TIGHT
DDC	DOUBLE DETECTOR CHECK	RW	RECYCLED WATER
DDC	DOUBLE DETECTOR CHECK	RWL	RAIN WATER LEADER
DET	DETECTOR	R/W	RIGHT OF WAY
DH	DETECTOR HANDHOLE	S	SOUTH
DI	DROP INLET	S	SLOPE
DIA	DIAMETER	S.A.D.	SEE ARCHITECTURAL DRAWINGS
DIP	DUCTILE IRON PIPE	SCADA	SUPERVISORY CONTROL AND DATA ACQUISITION
DLC	DETECTOR LOOP CONDUIT	SCH	SCHEDULE
DR	DRIVE	SD	STORM DRAIN
DS	DOWNSPOUT	SDCB	STORM DRAIN CATCH BASIN
DS	DOWNSTREAM	SDCO	STORM DRAIN CLEANOUT
DWG	DRAWING	SDI	STORM DRAIN DROP INLET
DWR	DASHED WHITE PAVEMENT MARKER	SDE	STORM DRAIN EASEMENT
DWY	DRIVEWAY	SDMH	STORM DRAIN MANHOLE
DY	DOUBLE YELLOW	SE	SEWER EASEMENT
DYR	DASHED YELLOW RAISED PAVEMENT MARKER	SEE	SEE ELECTRICAL DRAWINGS
E	EACH	S.F.	SQUARE FEET
EA	END HORIZONTAL CURVE	SG	SUBGRADE
EC	ECCENTRIC	SL	SIGNAL
EFFL	EFFLUENT (SEWER)	SL	STREET LIGHT
EG	EXISTING GROUND	S.L.D.	SEE LANDSCAPE DRAWINGS
ELC	ELEVATION	SOF	SLIP ON FLANGE
ELL	ELECTRICAL	SO	SIDE OPENING (SD)
ELB	ELBOW	S.P.D.	SEE PLUMBING DRAWINGS
EP	EDGE OF PAVEMENT	SPEC	SPECIFICATION
EQ	EQUAL	SQ	SQUARE
ESMT	EASEMENT	SS	STAINLESS STEEL
EVC	END VERTICAL CURVE	SS	SANITARY SEWER
EW	EACH WAY	SSCO	SANITARY SEWER CLEANOUT
EX	EXISTING	S.S.D.	SEE STRUCTURAL DRAWINGS
F	FIRE	SSMH	SANITARY SEWER MANHOLE
FA	FIRE ALARM	ST	STREET
FC	FACE OF CURB	STA	STATION
FCA	FLANGED COUPLING ADAPTER	STD	STANDARD
FDC	FIRE DEPARTMENT CONNECTION	STL	STEEL
FES	FLARED END SECTION	SVC	SERVICE
FF	FINISHED FLOOR	SWE	SIDEWALK EASEMENT
FG	FINISHED GRADE	SY	SQUARE YARDS
FH	FIRE HYDRANT	SW	SIDEWALK
FL	FLOWLINE	SWL	SOLID WHITE LINE
FLG	FLANGE	TAN	TANGENT
FLSO	FLOWLINE OF SIDE OPENING	TB	TOP OF BOX
FLEX	FLEXIBLE	TBM	TEMPORARY BENCHMARK
FM	FORCE MAIN (PRESSURE)	TC	TOP OF CONCRETE
FRP	FIBERGLASS REINFORCED PLASTIC	TC	TOP OF CURB
FT	FEET	TCE	TEMPORARY CONSTRUCTION EASEMENT
FTG	FOOTING	TD	TOP OF DIKE
GAL	GALLON	TEL	TELEPHONE
GALV	GALVANIZED	TEMP	TEMPORARY
GB	GRADE BREAK	TF	TOP OF FOUNDATION
GPM	GALLONS PER MINUTE	TG	TOP OF GRATE
GRD	GROUND	THD	THREADED
GSP	GALVANIZED STEEL PIPE	TP	TOP OF PIPE
GV	GAS VALVE	TS	TOP OF SLAB
HB	HOSE BIBB	TS	TRAFFIC SIGNAL
HB	HEADER BOARD	TT	TOP OF TAPER
HDB	HOT DIPPED GALVANIZED	TW	TOP OF WALL
HDPE	HIGH DENSITY POLYETHYLENE	TWLTL	TWO WAY LEFT TURN LANE
HORIZ	HORIZONTAL	TYP	TYPICAL
HP	HIGH POINT	UC	UTILITY CHASE
HPC	HIGH PRESSURE GAS	UFFG	UNDER FLOOR FINISHED GRADE
HPS	HIGH PRESSURE SODIUM	UG	UNDERGROUND
HT	HEIGHT	UNO	UNLESS NOTED OTHERWISE
HWY	HIGHWAY	V	VOLT
IC	INTERCONNECT	VC	VERTICAL CURVE
ICV	IRRIGATION CONTROL VALVE	VCP	VITRIFIED CLAY PIPE
ID	INSIDE DIAMETER	VERT	VERTICAL
INV	INVERT	VG	VALLEY GUTTER
IP	IRON PIPE	VLT	VAULT
IPS	IRON PIPE SIZE	W	WEST
IRR	IRRIGATION	W	WATER
ISA	INTERNATIONAL SYMBOL OF ACCESSIBILITY	WBD	WALL BACK DRAIN
JB	JUNCTION BOX	WM	WATER METER
JP	JOINT POLE	WNF	WELD NECK FLANGE
JT	JOINT TRENCH	WS	WATER SERVICE
KV	KILOVOLT	WSS	WATER SAMPLING STATION
L	ARC LENGTH	WT	WEIGHT
L	LENGTH	WTR	WATER
LAT	LATERAL	WV	WATER VALVE
LF	LINEAL FEET	WWF	WELDED WIRE FABRIC
LG	LIP OF GARAGE	Y	YARD
LG	LIP OF GUTTER	°	DEGREES
LL	LANE LINE	'	MINUTES
LMA	LUMINAIRE MAST ARM	"	SECONDS
LN	LANE	Δ	DELTA
LT	LOW POINT	AND	AND
LT	LEFT	AT	AT
LUM	LUMINAIRE	#	NUMBER
MAX	MAXIMUM	#	POUNDS
MB	MAILBOX	%	PERCENT
MBGR	METAL BEAM GUARD RAIL		
MFR	MANUFACTURE		
MG	MILLION GALLONS		


LEGEND


LINES

EXISTING BOUNDARY	----
EXISTING PARCEL	----
CENTER	----
EASEMENT	----

UTILITY & TOPOGRAPHY

	EXISTING	PROPOSED
DROP INLET		
DROP INLET WITH SIDE OPENINGS		
STORM DRAIN, MANHOLE & CATCH BASIN		
SEWER MAIN, MANHOLE & CLEAN OUT		
SEWER LATERAL & CLEANOUT		
IRRIGATION CONTROL VALVE BOX & SERVICE		
FIRE HYDRANT & SERVICE ASSEMBLY		
WATER MAIN, GATE VALVE, CROSS & ELBOW		
WATER MAIN, PERMANENT BLOWOFF, TEE, GATE VALVE, CROSS & BEND		
SINGLE WATER SERVICE (SEE PLANS FOR SIZE)		
DUAL WATER SERVICE (SEE PLANS FOR SIZE)		
TEMPORARY BLOWOFF, REDUCER & TIE-IN		
END CAP OR PLUG		
GAS MAIN, VALVE & SERVICE		
ELECTRICAL MANHOLE		
TELEPHONE MANHOLE		
PACIFIC BELL TELEPHONE PULL BOX/VAULT		
ELECTRICAL CONDUIT & BOX		
STREET LIGHT CONDUIT & BOX		
STREET LIGHT		
TRAFFIC SIGNAL		
TRAFFIC SIGNAL PULL BOX		
JOINT POLE & GUY ANCHOR		
OVERHEAD UTILITY		
STREET ADDRESS		
STREET SIGN		
FENCE		
PARKING METER		
SURVEY CONTROL POINT		
SURVEY MONUMENT		
AC DIKE		
CURB & GUTTER		
TREE PROTECTION		
ABANDON EXISTING UTILITY		
TREE TO BE SAVED/PROTECTED		
TREE TO BE REMOVED		

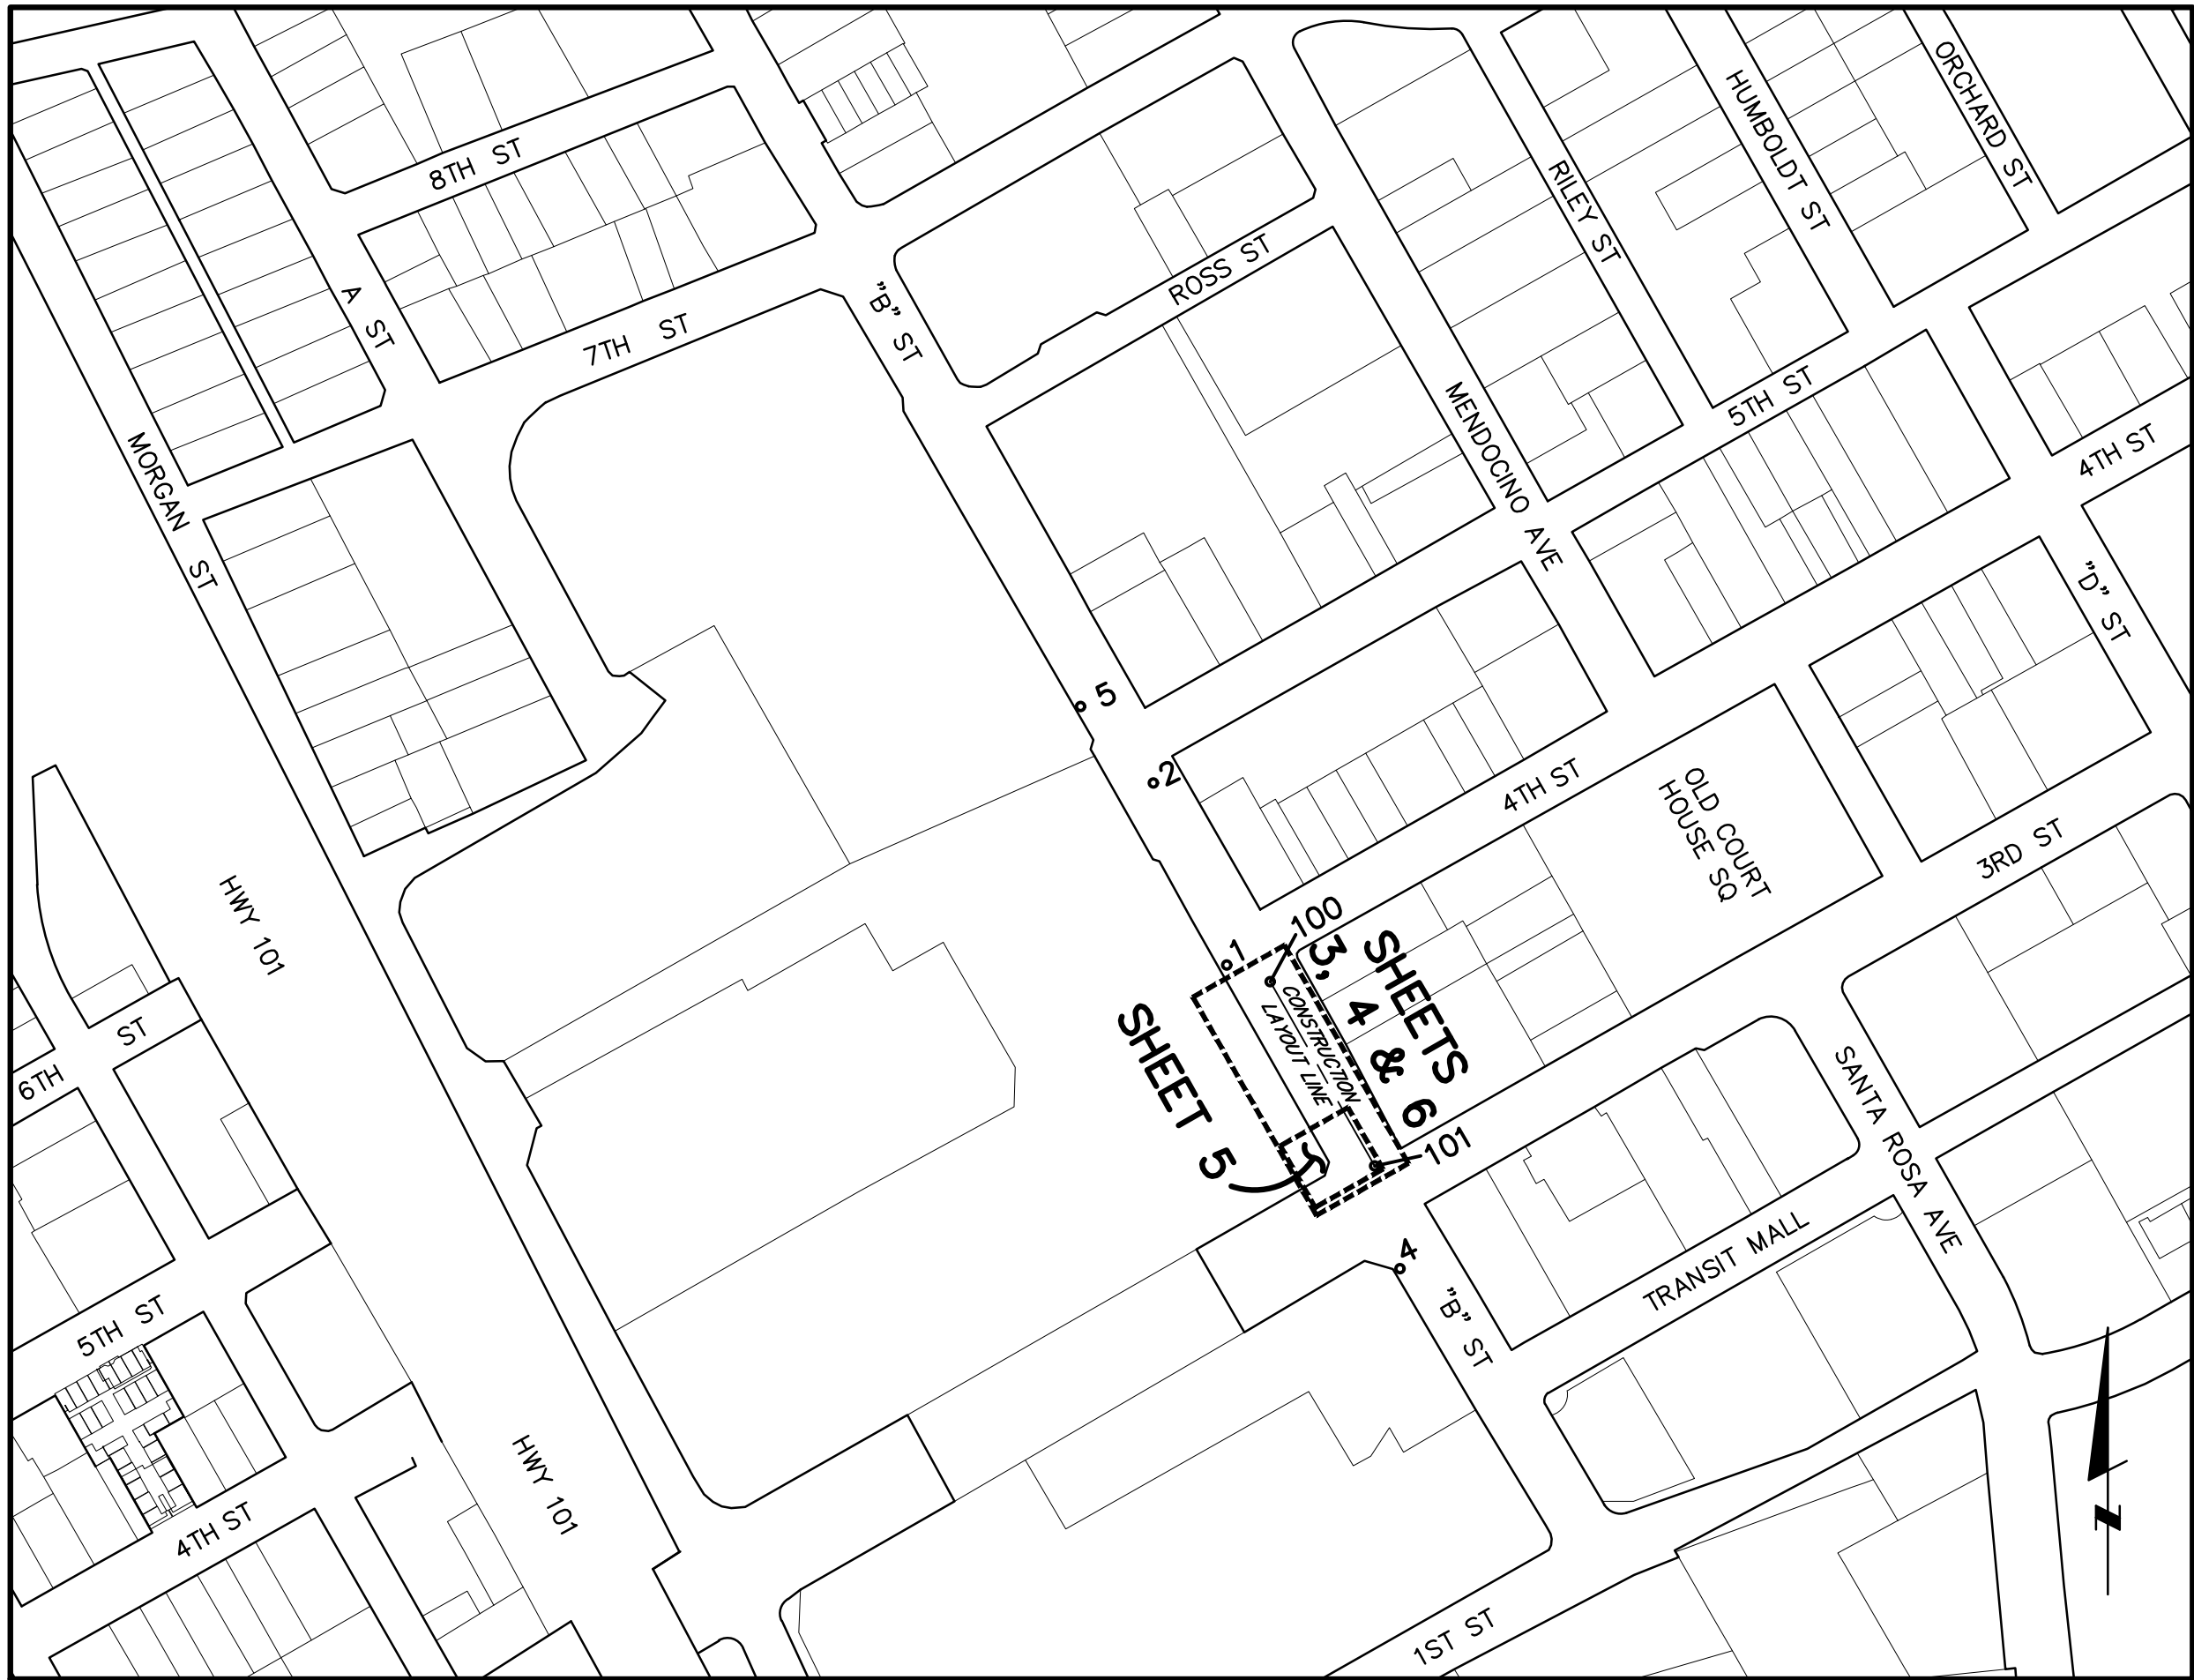

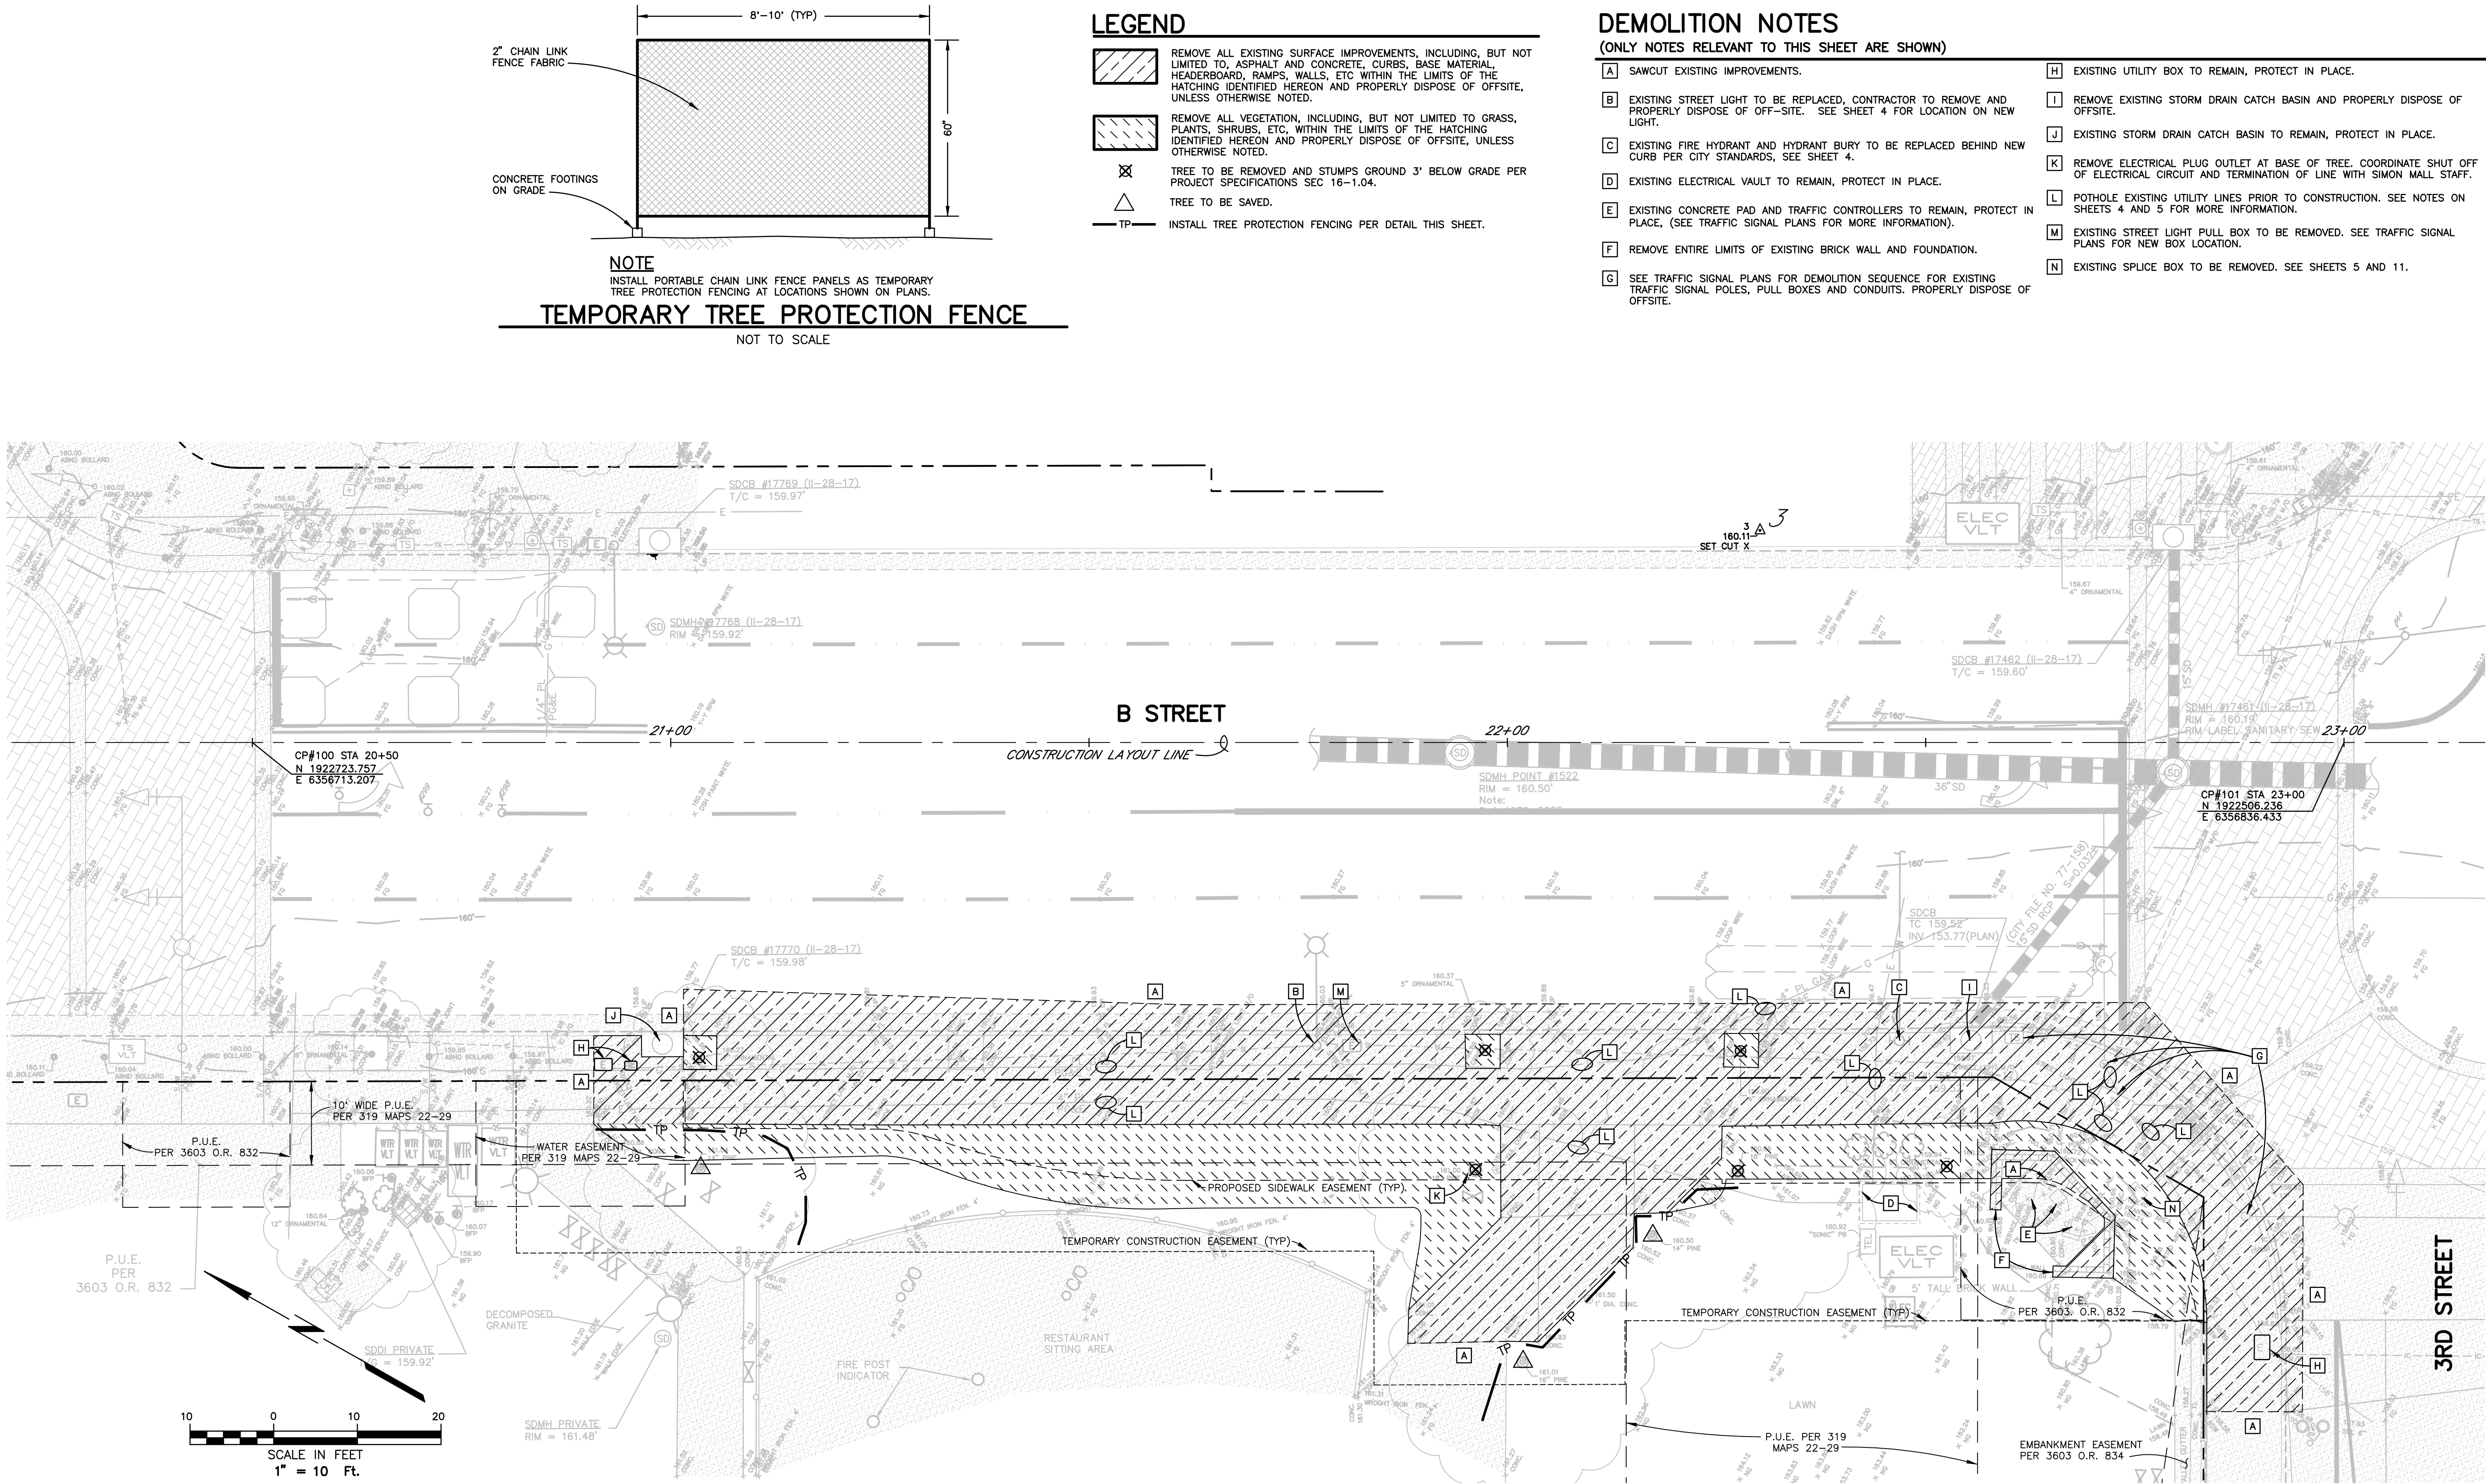

REGISTERED PROFESSIONAL ENGINEER
No. 52402
Exp. 12-31-24
CIVIL
STATE OF CALIFORNIA
6/16/24

City of Santa Rosa
Brelje & Race
1000 1st Street, Suite 200
Santa Rosa, CA 95404
(707) 539-1100
www.breljeandrace.com

City of Santa Rosa

B STREET AND 3RD STREET RIGHT
TURN POCKET IMPROVEMENTS

DEMOLITION PLAN

CONTRACT NO.
C02408

SHEET 3 OF 11

FILE NO. 2023-0025

SCALE: AS SHOWN

DATE: JULY 2024

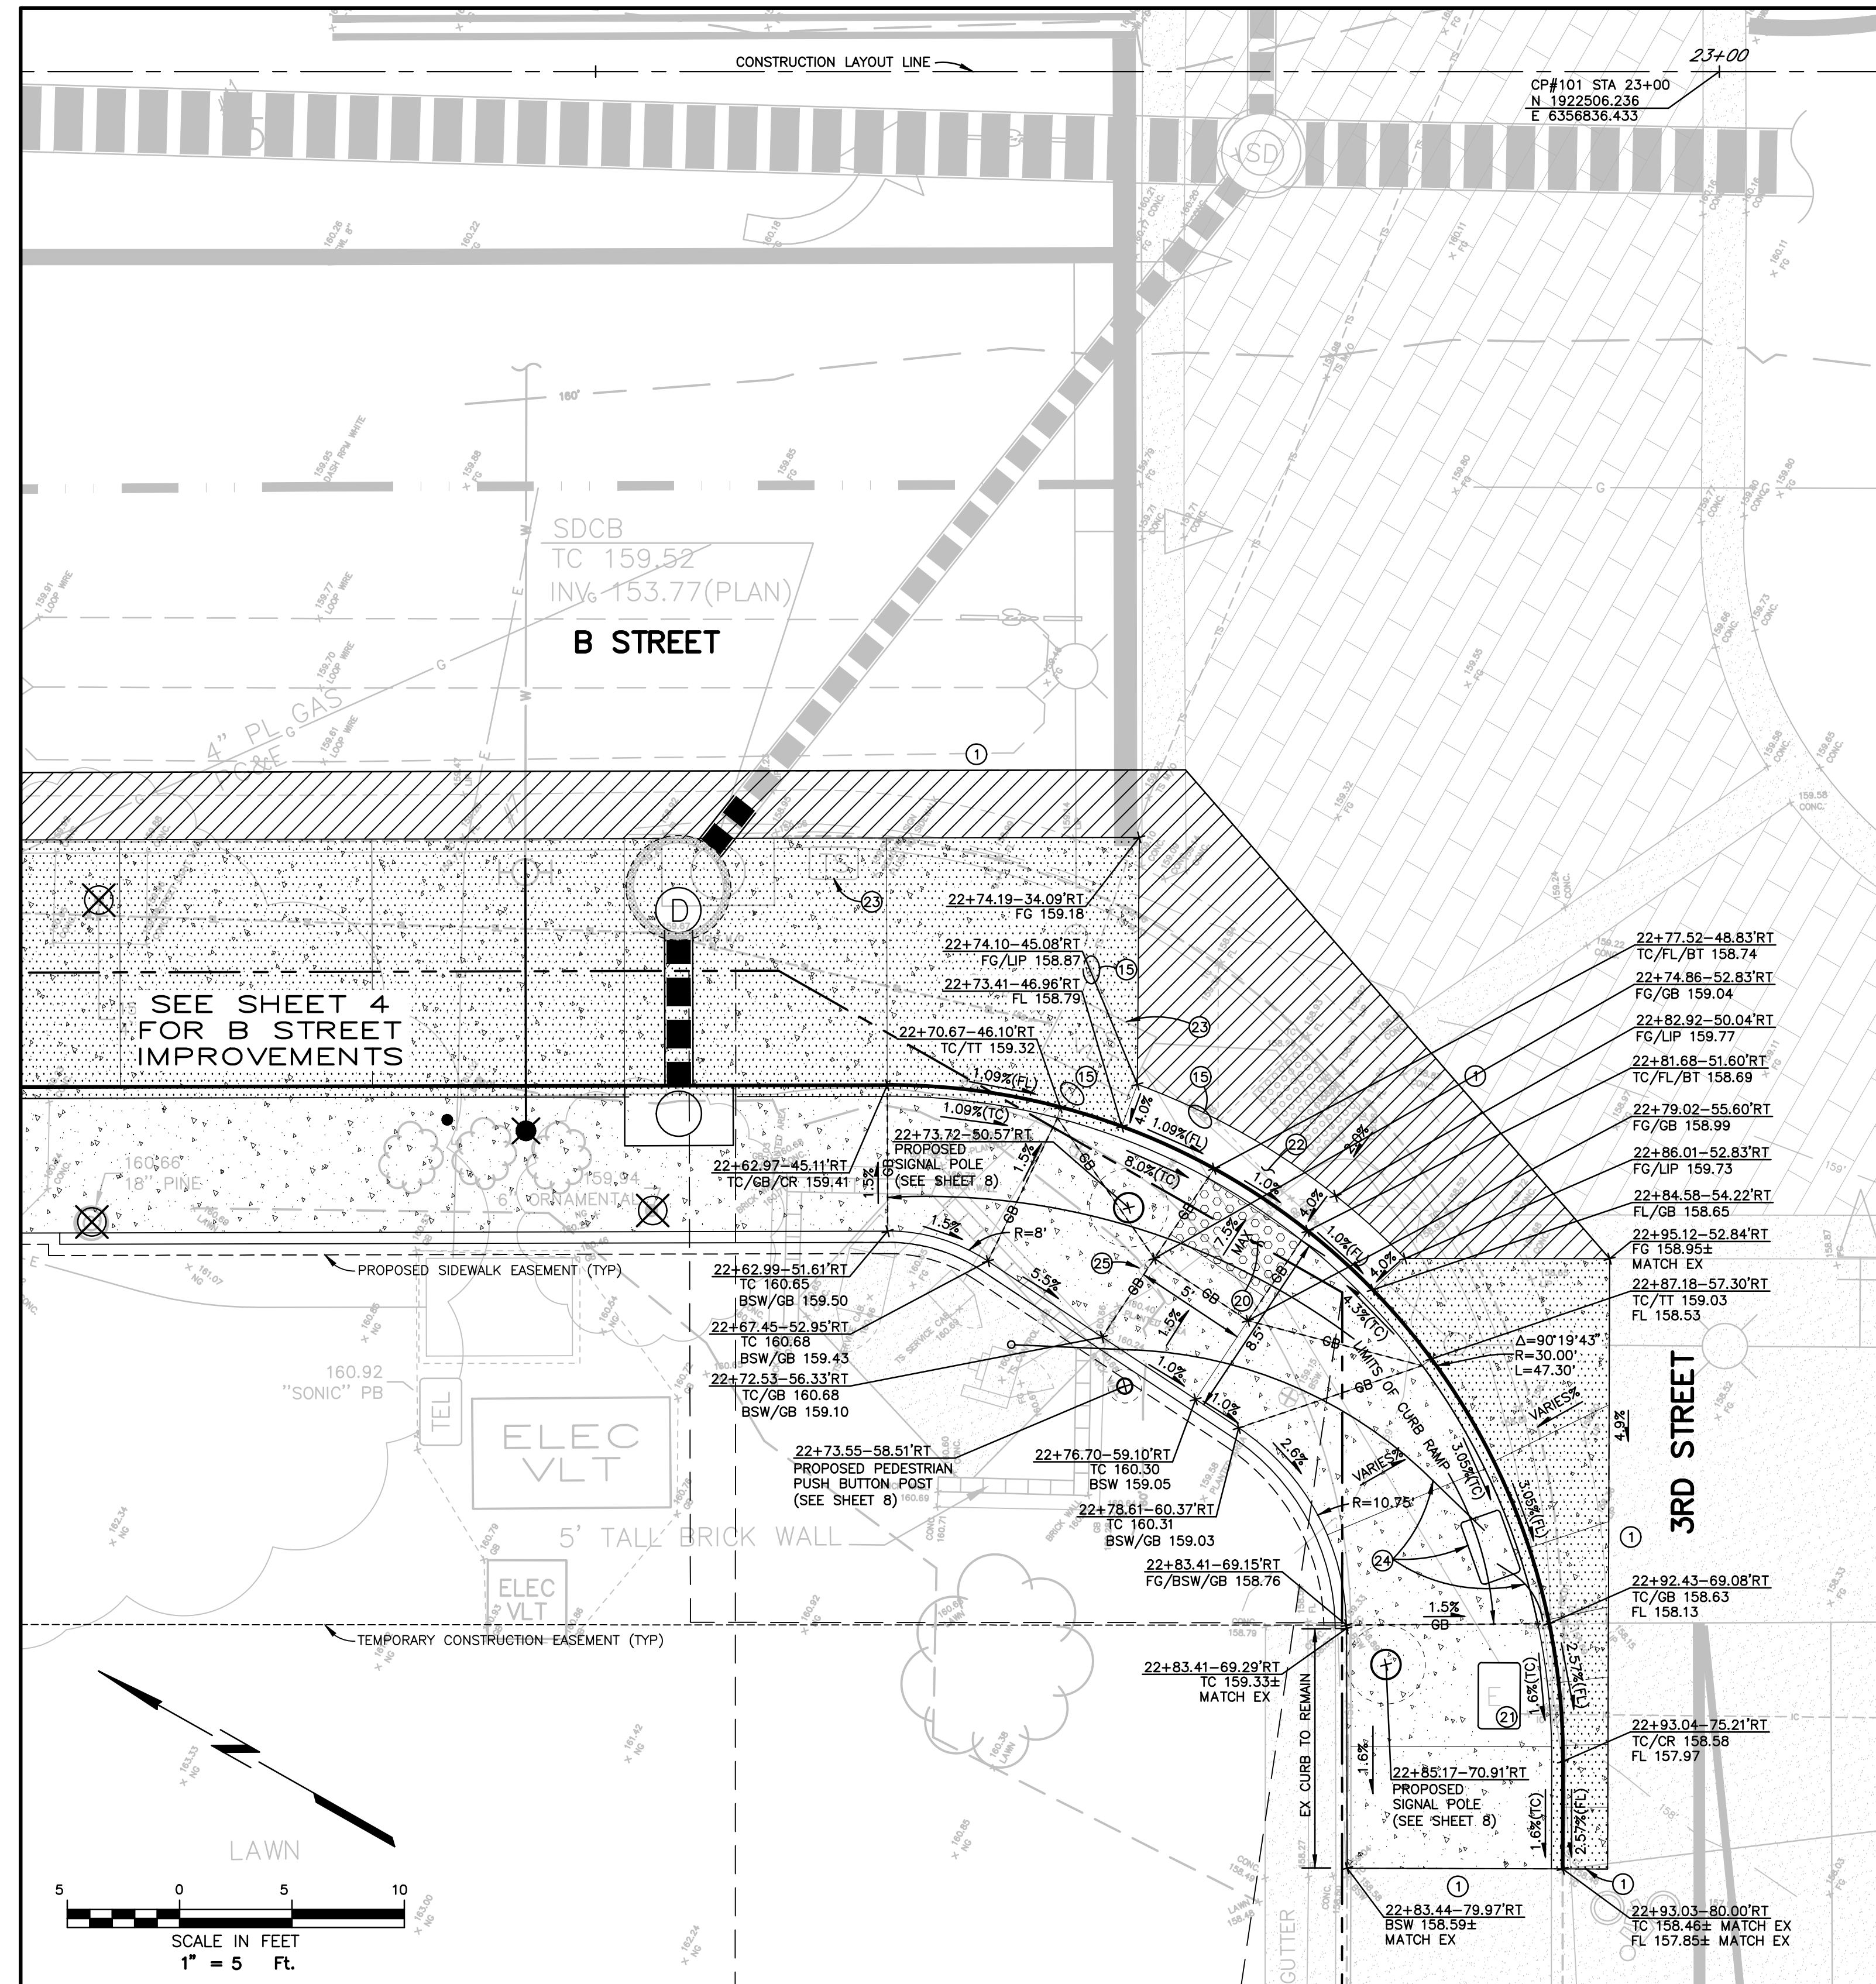
DWN BY: PIT

CHK BY: JST

NO. DATE

REVISION

BY



CURB RAMPS WEST SIDE (B STREET/3 RD STREET)

GRADING NOTES

(ONLY NOTES RELEVANT TO THIS SHEET ARE SHOWN)

- ① SAWCUT AND MATCH EXISTING.
- ⑮ POTHOLE EXISTING TRAFFIC SIGNAL CONDUITS ENOUGH TO ASSURE AVOIDING DISRUPTION OF TRAFFIC SIGNAL OPERATION DURING CONSTRUCTION AND TO ALLOW FOR REROUTING OF LINES PER TRAFFIC SIGNAL PLANS.
- ②⑥ 3' X 5' DETECTABLE WARNING SURFACE PER DETAIL SHEET 7.
- ②① EXISTING UTILITY BOX TO REMAIN, PROTECT IN PLACE, ADJUST TO NEW FINISHED GRADE.
- ②② CURB AND GUTTER PER CITY STANDARD 241 WITH VARIED HEIGHT AND GUTTER CROSS SLOPE PER THIS PLAN.
- ②③ EXISTING STREET LIGHT AND TRAFFIC SIGNAL PULL BOXES TO BE REMOVED. SEE TRAFFIC SIGNAL PLANS FOR NEW BOX LOCATIONS.
- ②④ PRIOR TO CONSTRUCTION OF THE CURB RAMP, THE CONTRACTOR SHALL REROUTE THE EXISTING CONDUIT RUN LEADING FROM THE PUMP STATION LOCATED IN THE UNDERPASS TO THE PUMP CONTROLLER CABINET. SEE SHEET 11 FOR DETAILS.
- ②⑤ EXISTING PUMP CONTROL PULL BOXES TO BE REMOVED. SEE SHEET 11 FOR DETAILS.

LEGEND

- | | |
|---|---|
|  | LIMITS OF AC CONFORM 0.67" AC SURFACE
OVER 1.26" CLASS 2 AB. ($\pi = 10:1$) |
|  | LIMITS OF P.C.C. PAVEMENT SECTION, PER CITY STANDARD 222, AND
TYPICAL SECTION 1 (SEE SHEET 7). SCORE MARKS AND EXPANSION
JOINTS SHALL APPROXIMATE SQUARE SHAPES WITH THE LONG SIDE OF
THE SQUARE NO MORE THAN 1.25 TYPICAL (1.5 MAX) TIMES THE
LENGTH OF THE SHORT SIDE. APPROXIMATE SUGGESTED SCORE MARKS
ARE SHOWN ON THE PLAN. EXPANSION JOINTS SHALL BE AT 60"
MAXIMUM SPACING. |
|  | LIMITS OF CONTIGUOUS SIDEWALK SECTION,
PER CITY STANDARD 230G. |




City of
Santa Rosa
Brelje & Race
CONSULTING ENGINEERS
475 Aviation Blvd. • Suite 120 • Santa Rosa, CA 95403 • 707-576-1322

[illegible]

SCALE: AS SHOWN	DATE: JULY 2024
DWN BY: JLP	CHK BY: JST

B STREET AND 3RD STREET RIGHT TURN POCKET IMPROVEMENTS	CONTRACT NO.
	C02408
SIDEWALK & CURB RAMP GRADING & DETAILS	CONTRACT NO.
	C02408

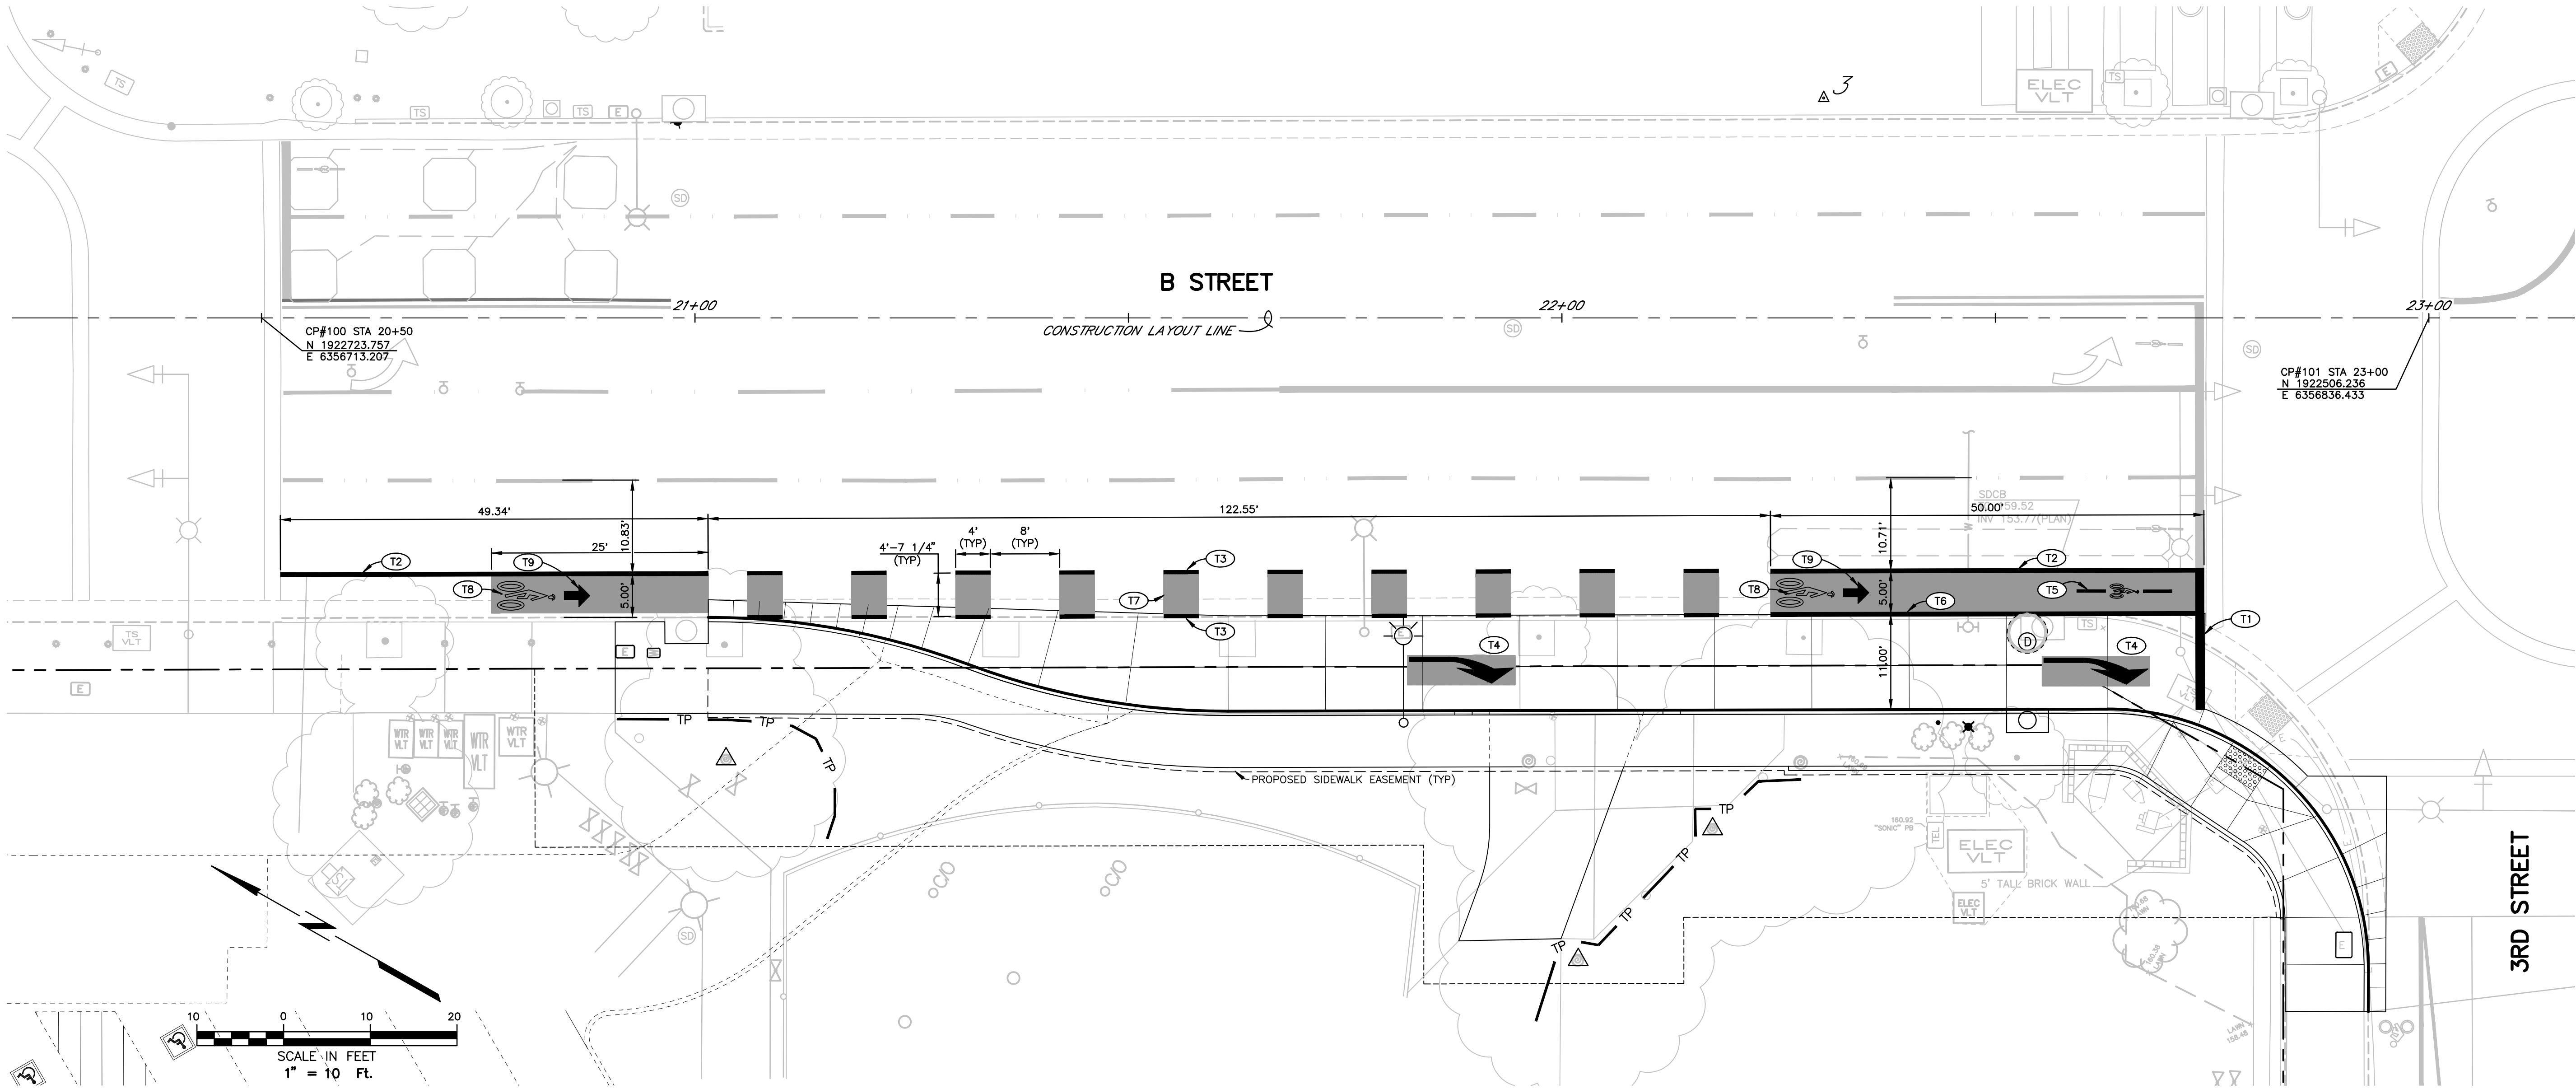

SHEET NOTES

(ONLY NOTES RELEVANT TO THIS SHEET ARE SHOWN)

- (T1) INSTALL 12" WHITE METHYL METHACRYLANE CROSSWALK/LIMIT LINE PER CALTRANS STD PLAN A24F.
- (T2) INSTALL 6" WHITE BIKE LANE PER CALTRANS STD PLAN A20D, DETAIL 39.
- (T3) INSTALL 6" WHITE BIKE LANE INTERSECTION LINE PER CALTRANS STD PLAN A20D, DETAIL 39A.
- (T4) INSTALL TYPE IV (R) ARROW PER CALTRANS A24A, WITH CONTRAST BLACK BENEATH THE ARROW AND A MINIMUM OF 2" BEYOND ARROW.
- (T5) INSTALL METHYL METHACRYLANE BIKE DETECTOR SYMBOL PER CALTRANS STD PLAN A24C.
- (T6) INSTALL 8" WHITE CHANNELIZING LINE PER CALTRANS STD PLAN A20D, DETAIL 38A.
- (T7) AREA BETWEEN STRIPES SHALL BE GREEN METHYL METHACRYLANE BIKE LANE MARKINGS (TYPICAL).
- (T8) INSTALL METHYL METHACRYLANE BIKE LANE SYMBOL PER CALTRANS STD PLAN A24C.
- (T9) INSTALL METHYL METHACRYLANE BIKE LANE ARROW PER CALTRANS STD PLAN A24A.

NOTES


- ALL STRIPING, PAVEMENT MARKINGS, AND RAISED MARKERS SHALL CONFORM TO THE LATEST EDITION OF THE CALTRANS STANDARD PLANS AND THE CALIFORNIA MUTCD, UNLESS OTHERWISE NOTED.
- ALL PAVEMENT STRIPING AND MARKINGS SHALL BE METHYL METHACRYLANE PER MUTCD AND CALTRANS STANDARD SUPPLEMENTAL SPECIFICATIONS, UNLESS OTHERWISE NOTED.
- PROPOSED STRIPING TO MATCH EXISTING IN SIZE, LENGTH, AND COLOR.

LEGEND


- BICYCLE LOOP DETECTOR SYMBOL DETAIL PER CALTRANS STD PLAN A24C
- BIKE LANE SYMBOL PER CALTRANS STD PLAN A24C




City of Santa Rosa		CONTRACT NO. C02408		SHEET 6 OF 11		FILE NO. 2023-0025	
B STREET AND 3RD STREET RIGHT TURN POCKET IMPROVEMENTS		DATE: JULY 2024		CHK BY: JST		NO. DATE	
SIGNING & STRIPING PLAN		SCALE: AS SHOWN		DWN BY: PIT		REVISION	
						BY	

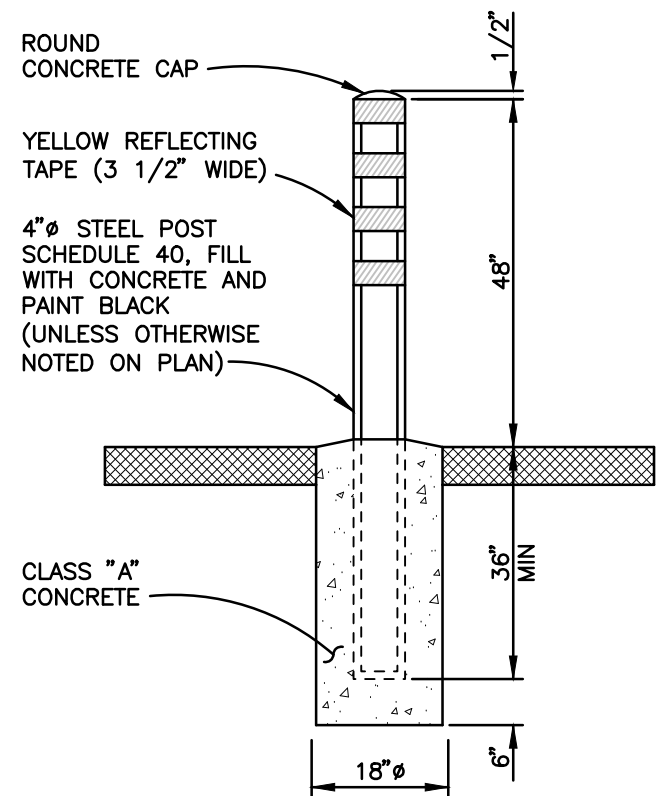


FIXED BOLLARD
NOT TO SCALE

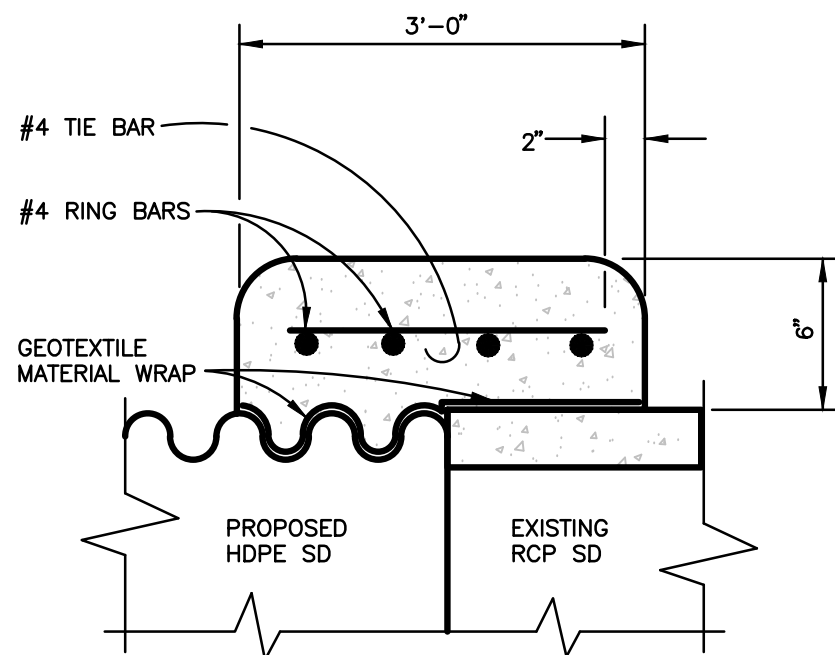


CONCRETE COLLAR
NOT TO SCALE

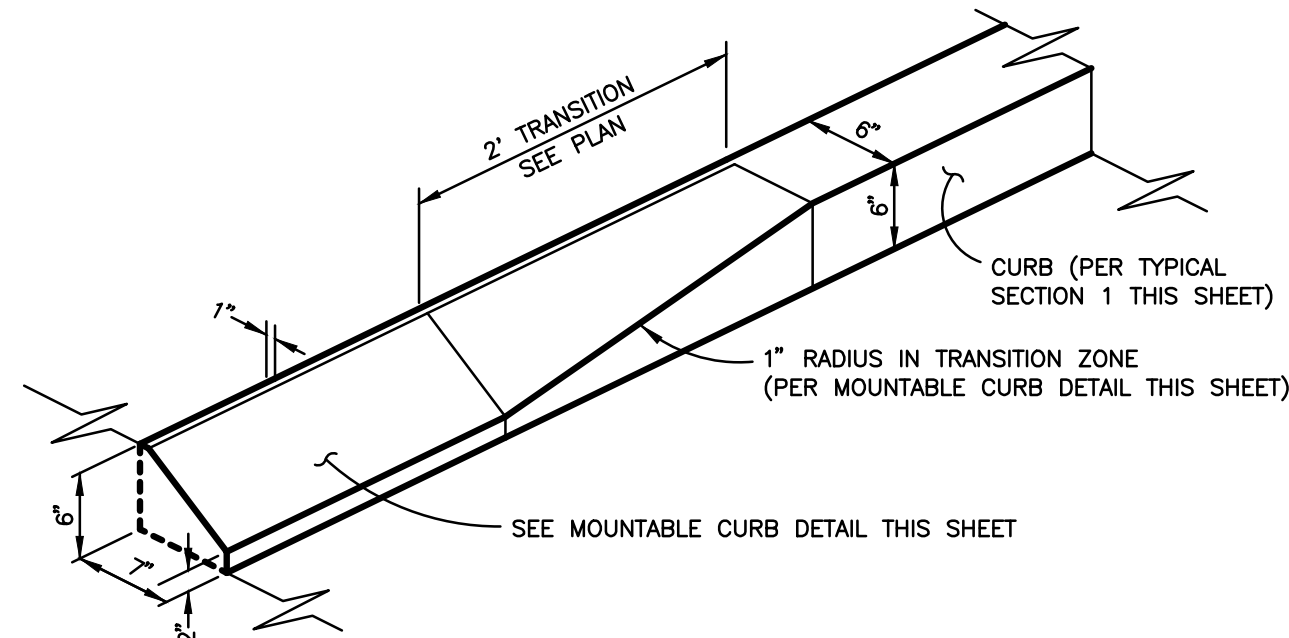


CURB TRANSITION
NOT TO SCALE

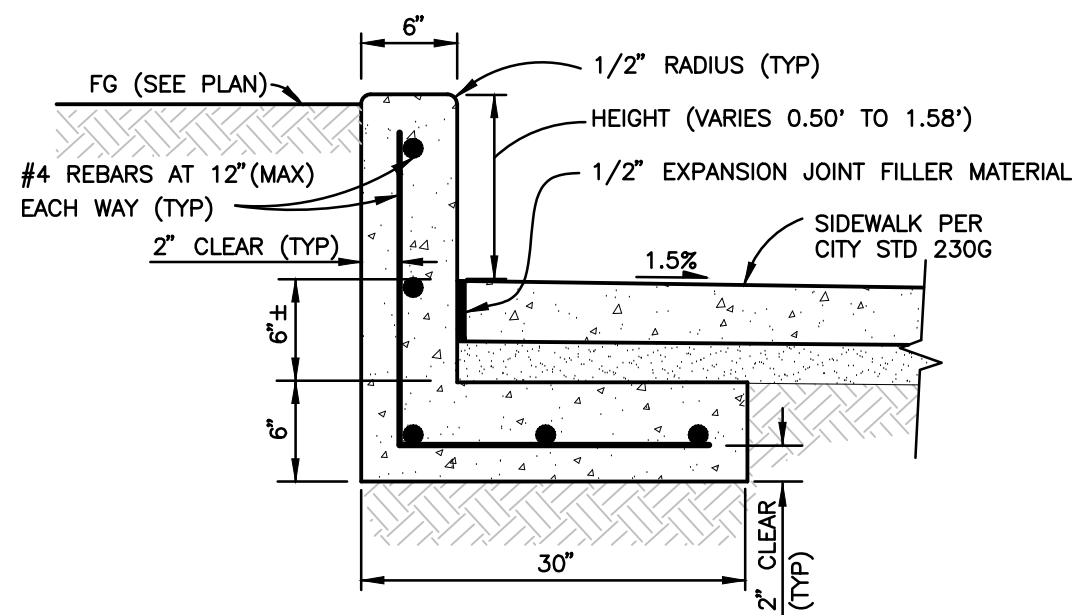

RETAINING CURB
NOT TO SCALE

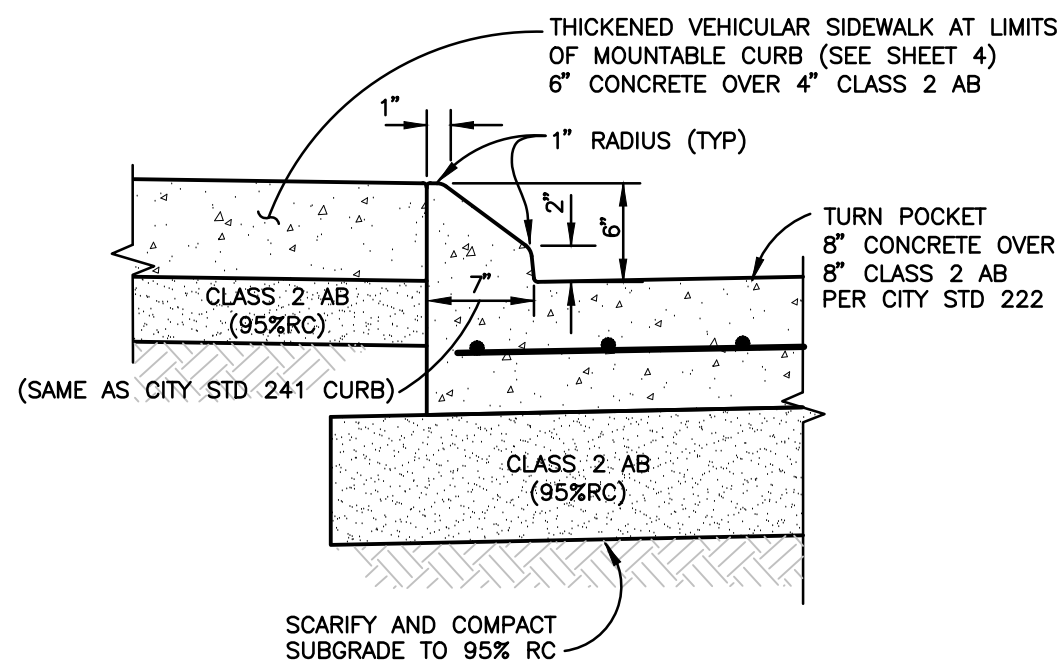


MOUNTABLE CURB
NOT TO SCALE

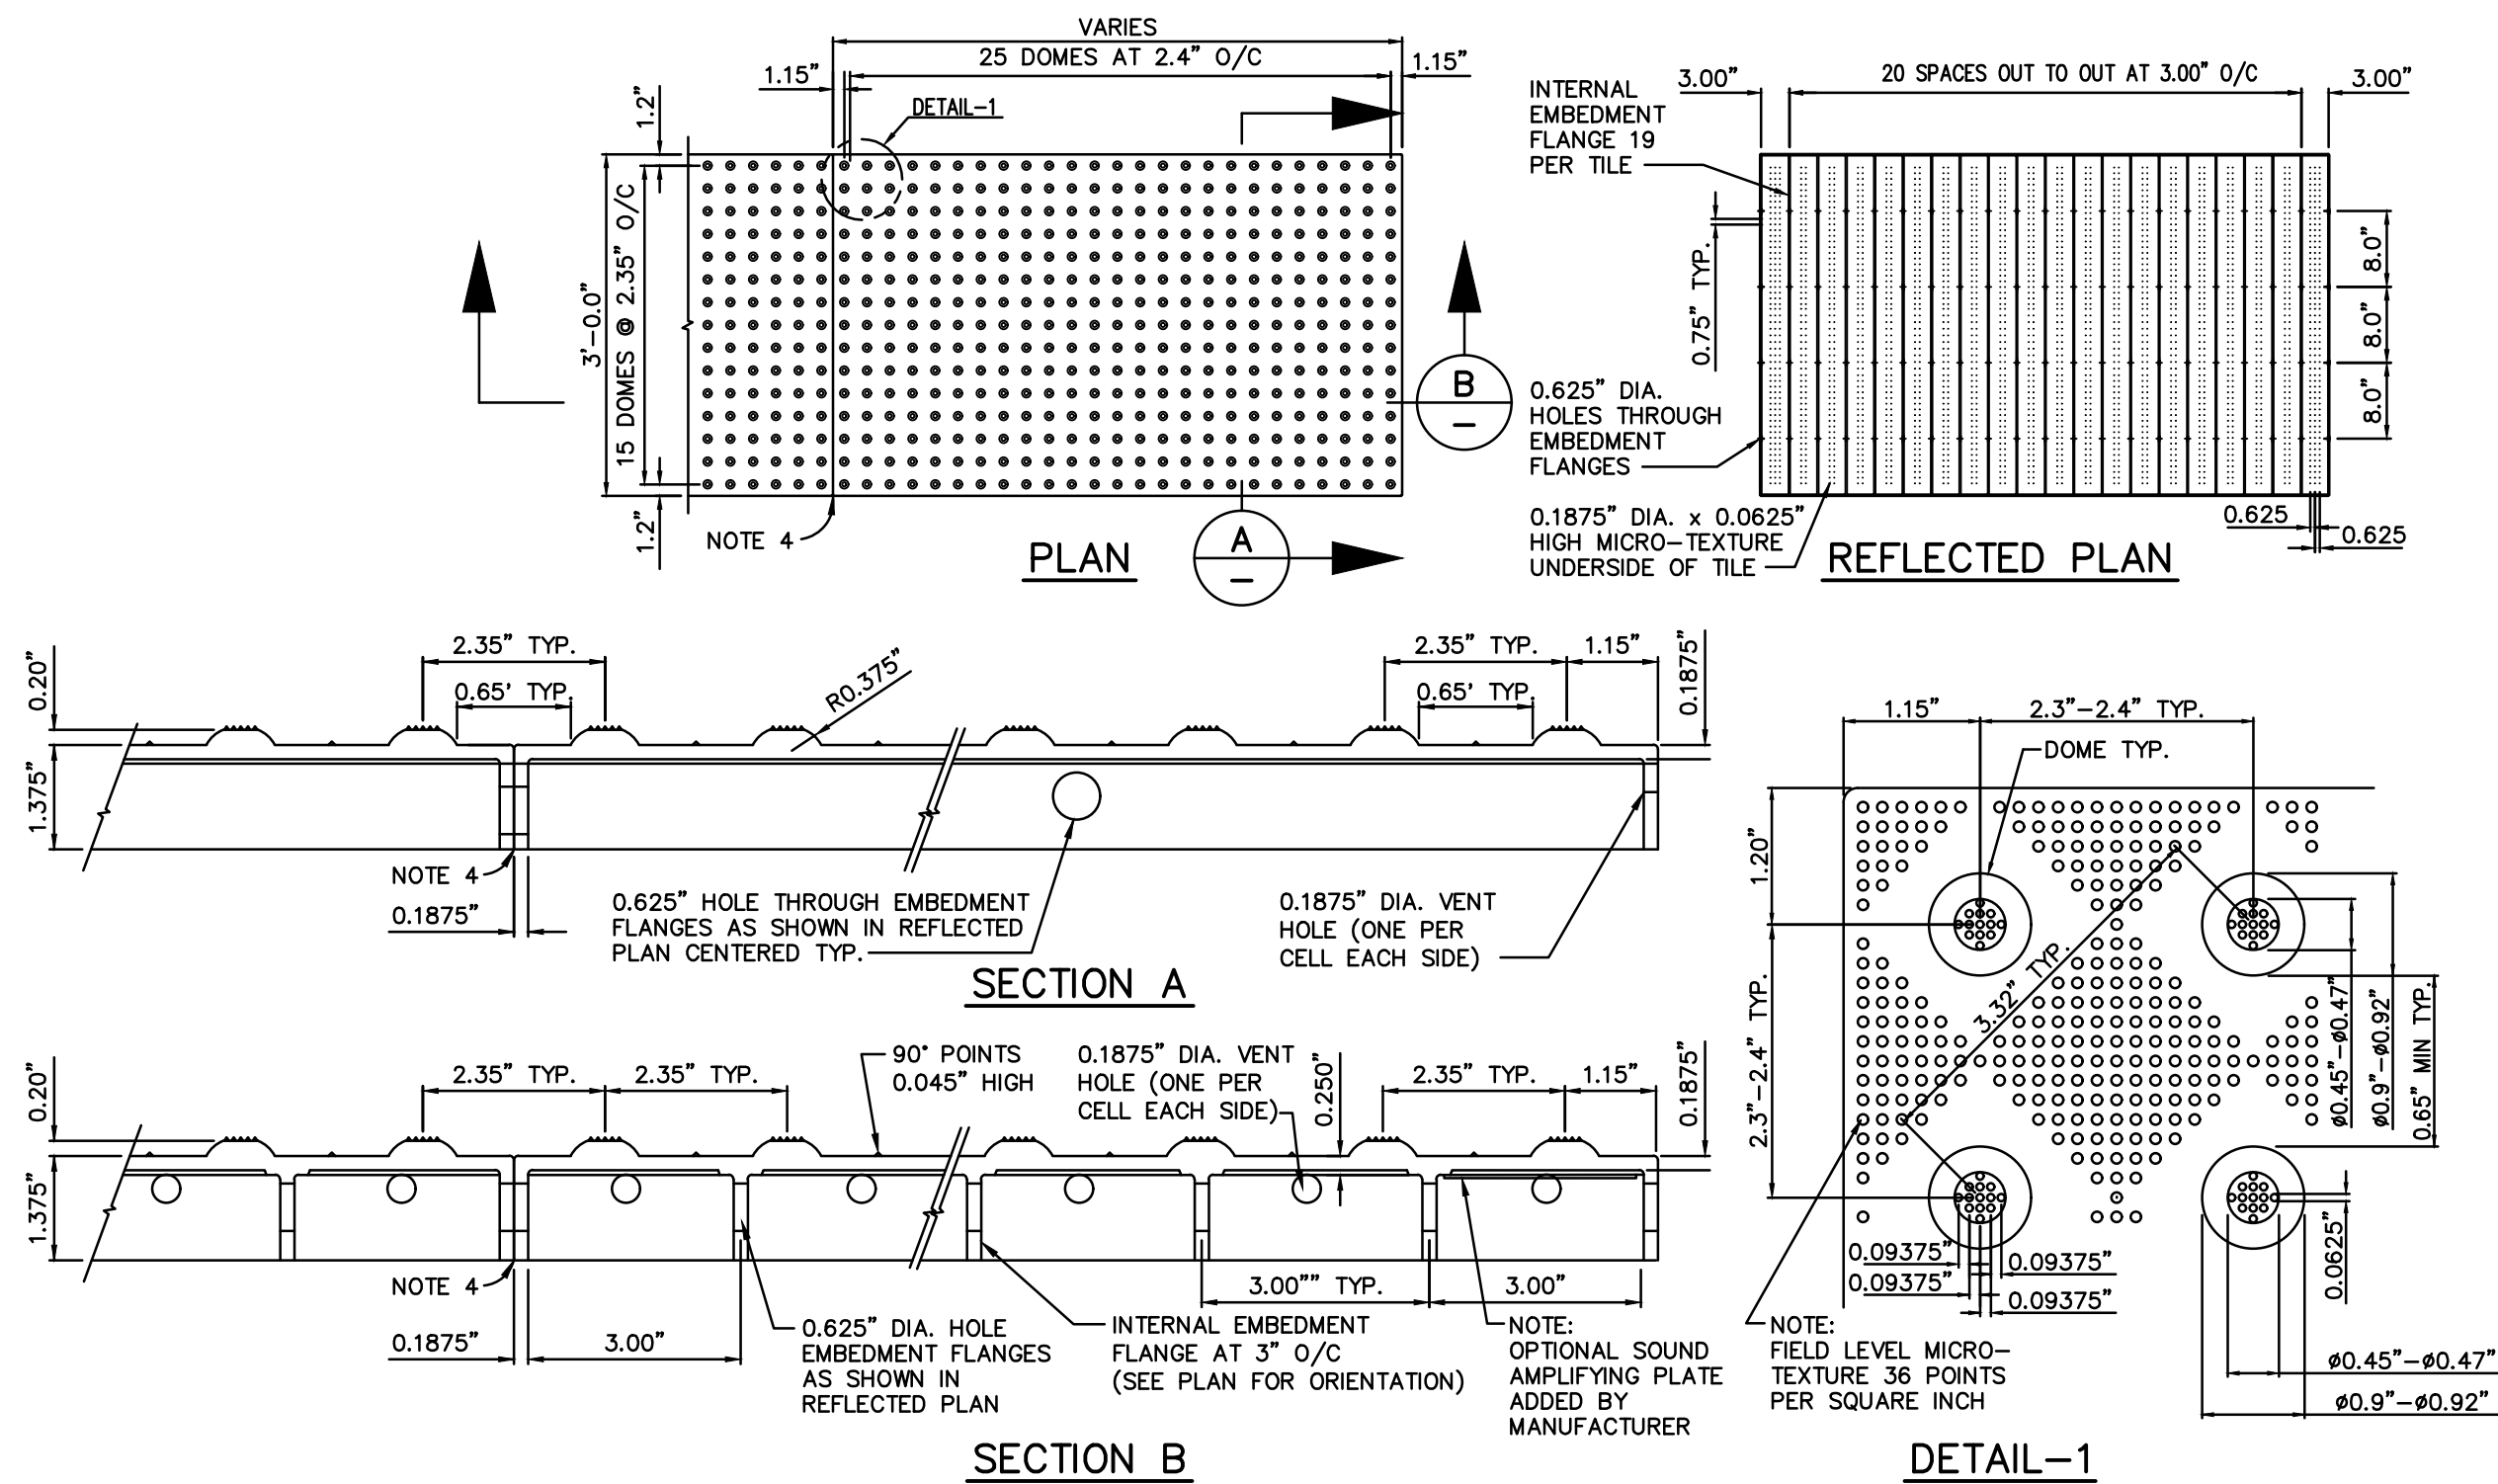

NOTES

1. DETAIL FOR 36"x60" SHOWN. DETAIL FOR OTHER SIZE TILES SIMILAR.
2. TILE COLOR TO BE YELLOW.
3. TILES TO BE PLACED FULL WIDTH OF RAMP, EXCLUDING FLARES, AND A MINIMUM LENGTH OF 3FT IN THE DIRECTION OF TRAVEL.
4. WHEN PLACING SEPARATE TILES TOGETHER, ADJACENT TILES SHALL MAINTAIN TRUNCATED DOMES CENTER-TO-CENTER AND BASE-TO-BASE SPACING BETWEEN THE SQUARE GRIDS, AS WELL AS LINEAL ALIGNMENT.

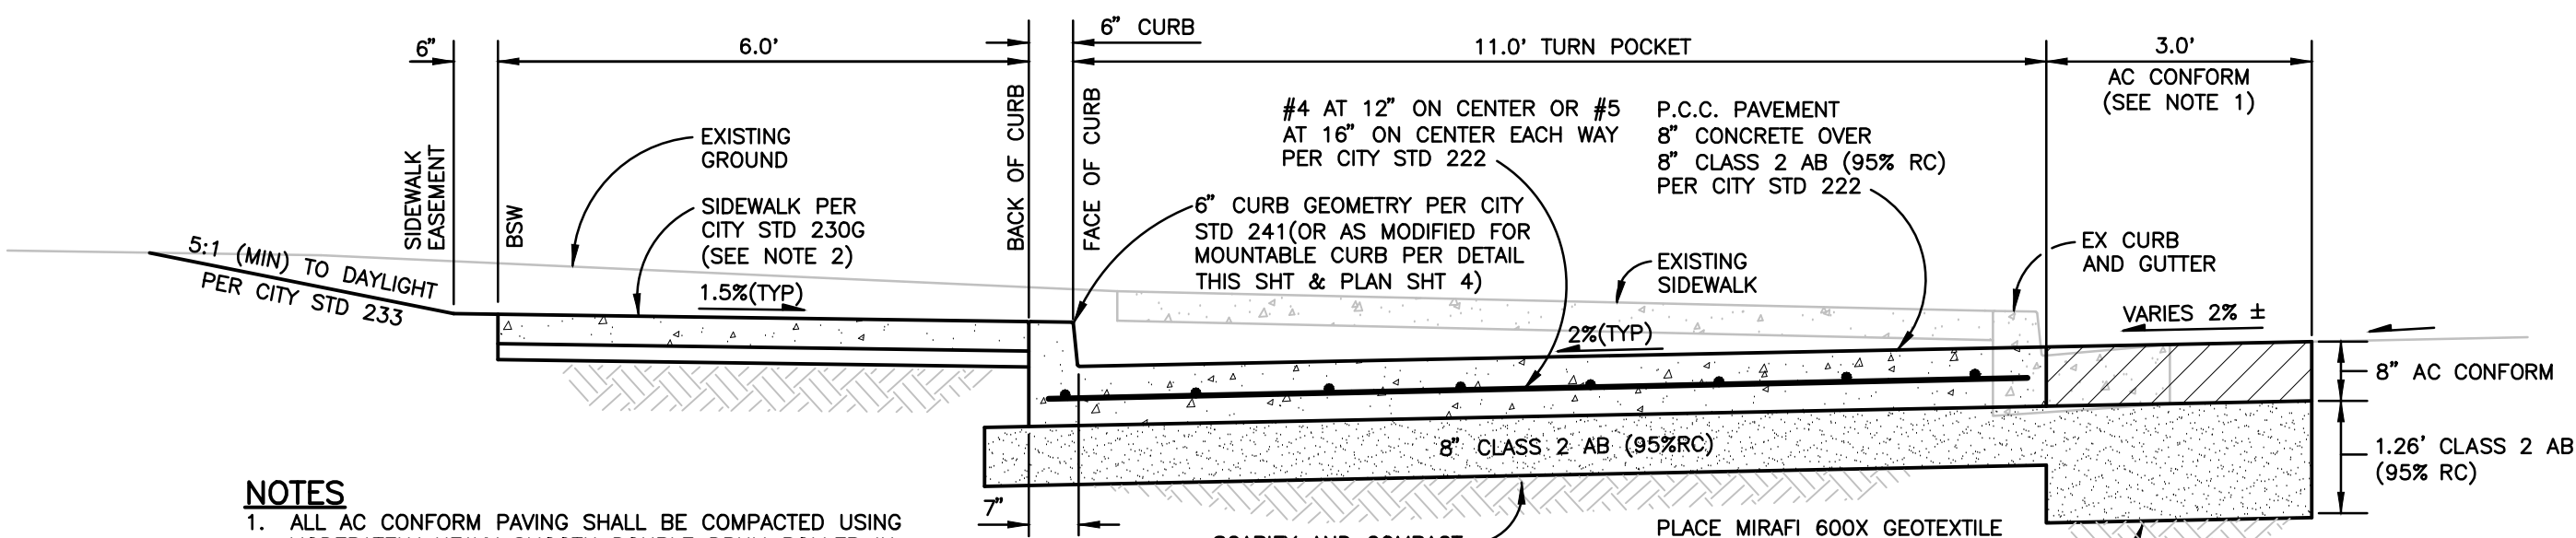**EMBEDDED
DETECTABLE WARNING SURFACE**
NOT TO SCALE





















TYPICAL SECTION
NOT TO SCALE

1
4

NOTES

                  1. ALL AC CONFORM PAVING SHALL BE COMPACTED USING MODERATELY HEAVY SMOOTH DOUBLE DRUM ROLLER IN ORDER TO ACHIEVE SATISFACTORY COMPACTION RESULTS. SUCH AS DYNAPAC DTR 75 OR WACKER NEUSON RD7A (MIN 24" NOMINAL WIDTH AND MIN 1500 LB MASS).
2. SEE SHEET 4 FOR LIMITS OF THICKENED VEHICULAR SIDEWALK.

CONDUCTOR TABLE														
AWG	CIRCUIT													
														
NO. 14	Ø1										3(AB)			
	Ø2	6			3	3	3		3	3	3	3	3	
	Ø3	3				3	3				3	3	3	
	Ø4	3			3	3					3	3	3	3
	Ø5	3				3	3	3						
	Ø6	6			3(N)	3	3	3						
	Ø7	3				3	3		3					
	Ø8	6				6	6		3					
	OLA	2,2(N)			2(N)	2	2	2						
	OLB	4			2	2	2		2	2	2	2	2	
	OLC	2			2(N)	2					2(N)	2(N)	2(N)	2(N)
	Ø2P	4			2	2	2		2	2	2	2	2	
	Ø4P	4			2	2					2	2	2	2
	Ø6P	4			2(N)	2	2							
	Ø8P	4				4	4	2	2					
	APS(Ø2P)	1			1	1	1		1		1	1	1	1
	APS(Ø4P)	2		1(N)	1						1	1	1	
	APS(Ø6P)	1		1(N)		1	1							
	APS(Ø8P)	2				2	2	1	1	1				
	PPB COMMON	1		1(N)	1(N)	1	1	1	1	1	1	1	1	1
	SPARES	3		3(N)	3(N)	3	3	3	3	3	3	3	3	3
	PEC	1			1									
	TOTAL No. 14	63	0	5	26	48	41	15	21	12	20	20	20	12
NO. 8	SIGNAL NEUTRAL	1		1(N)	1	1	1	1	1	1	1	1	1	1
	LIGHTING	4			2	2	2	2			2	2	2	2
	EQUIP. GROUND	1	1	1(N)	1	1	1	1	1	1	1	1	1	1
	SERVICE		2											
	TOTAL No. 8	6	3	2	4	4	4	4	2	2	4	4	4	4
VIDS	VIDEO DETECTION	1(N)				1(N)								
SIC	24PR INTERCONNECT	2			2						2	2	2	
EVU CABLE	CHANNEL A	1				1								
	CHANNEL B	1				1	1	1						
	CHANNEL C	1				1								
	CHANNEL D	1				1	1	1						
	TOTAL EV CABLES	4				4	2	2						
CONDUIT SIZE (INCHES)		2-3"(N)	2"(N)	2"(N)	3"(N)	3"(N)	3"(N)	2.5"(E)	4"(E)	4"(E)	3"(E)	3"(E)	2.5"(E)	2"(E)
CONDUIT FILL (PERCENT)		15	5	7	13	20	17	15	4	3	8	12	18	15

(N) = NEW CONDUCTORS AND CABLES
ALL CONDUCTORS AND CONDUITS ARE EXISTING TO REMAIN UNLESS OTHERWISE NOTED

POLE AND EQUIPMENT SCHEDULE													
No.	STANDARD			VEHICLE SIGNAL				PED SIGNAL		APS		LED LUMINAIRE	SPECIAL REQUIREMENTS
	TYPE	SMA	LMA	MAST	ARM	POLE		ø	MTG	ø	ARROW		
				MTG	ø	MTG	ø						
Ⓐ	26-3-100 (N)	45	12	MAT (N) MAS (N)	6	SV-1-T (N)	6+OLA	6P	SP-1-T (N)	-	-	101 (N)	SNS "B St", R3-18, PEU
Ⓑ	APS POST (N)	-	-	-	-	-	-	-	-	6P (N), 4P (N)	RIGHT (N) LEFT (N)	-	MOUNT PUSH BUTTON 3'6" FROM SIDEWALK ELEVATION.
Ⓒ	26-3-100 (N)	45	12	MAT (N) MAS (N)	3	SV-2-T (N)	3 4+OLC	4P	SP-1-T (N)	-	-	101 (N)	PHASE 3 TENON TO BE MOUNTED BACKWARD, R3-4 (N), R61-17 (N), EVA (E), EVC (E), GRIDSMART CAMERA (N)
Ⓓ	19-2-70 (E)	25	12	MAT	3	SV-1-T	8	6P	SP-1-T	6P (N)	RIGHT (N)	101	EX SNS
Ⓔ	18-4-70 (E)	30	12	MAS	5	SV-2-T	5 6+OLA	8P	SP-1-T	8P (N)	RIGHT (N)	101	EX R3-1
Ⓕ	17 (E)	15	-	MAS	2	SV-1-T	2+OLB	2P	SP-1-T	8P (N)	LEFT (N)		EX SNS
Ⓖ	19 (E)	30	-	MAT	7	SV-2-TA	7 8	8P	SP-1-T	2P (N)	RIGHT (N)	-	EX R3-1
Ⓗ	16 (E)	15	12	MAT	4	SV-1-T (N)	4+OLC (N)	4P	SP-1-T	2P (N)	LEFT (N)	101	EX SNS
Ⓘ	18-4-70 (E)	30	-	MAT	2	SV-1-T	2+OLB	2P	SP-1-T	4P (N)	RIGHT (N)	-	EX R3-18

ALL EQUIPMENT IS EXISTING TO REMAIN UNLESS OTHERWISE NOTED
(N)= NEW SIGNAL EQUIPMENT



City of Santa Rosa

Santa Rosa

w-trans

490 Mendocino Avenue, Suite 201
Santa Rosa, CA 95401
(707) 542-9500 Fax (707) 542-9590

CONTRACT NO.
C02408

SHEET 9 OF 11

FILE NO. 2023-0025

City of Santa Rosa

B STREET AND 3RD STREET RIGHT TURN POCKET IMPROVEMENTS

TRAFFIC SIGNAL SCHEDULES

SCALE: AS SHOWN
DWN BY: ACM

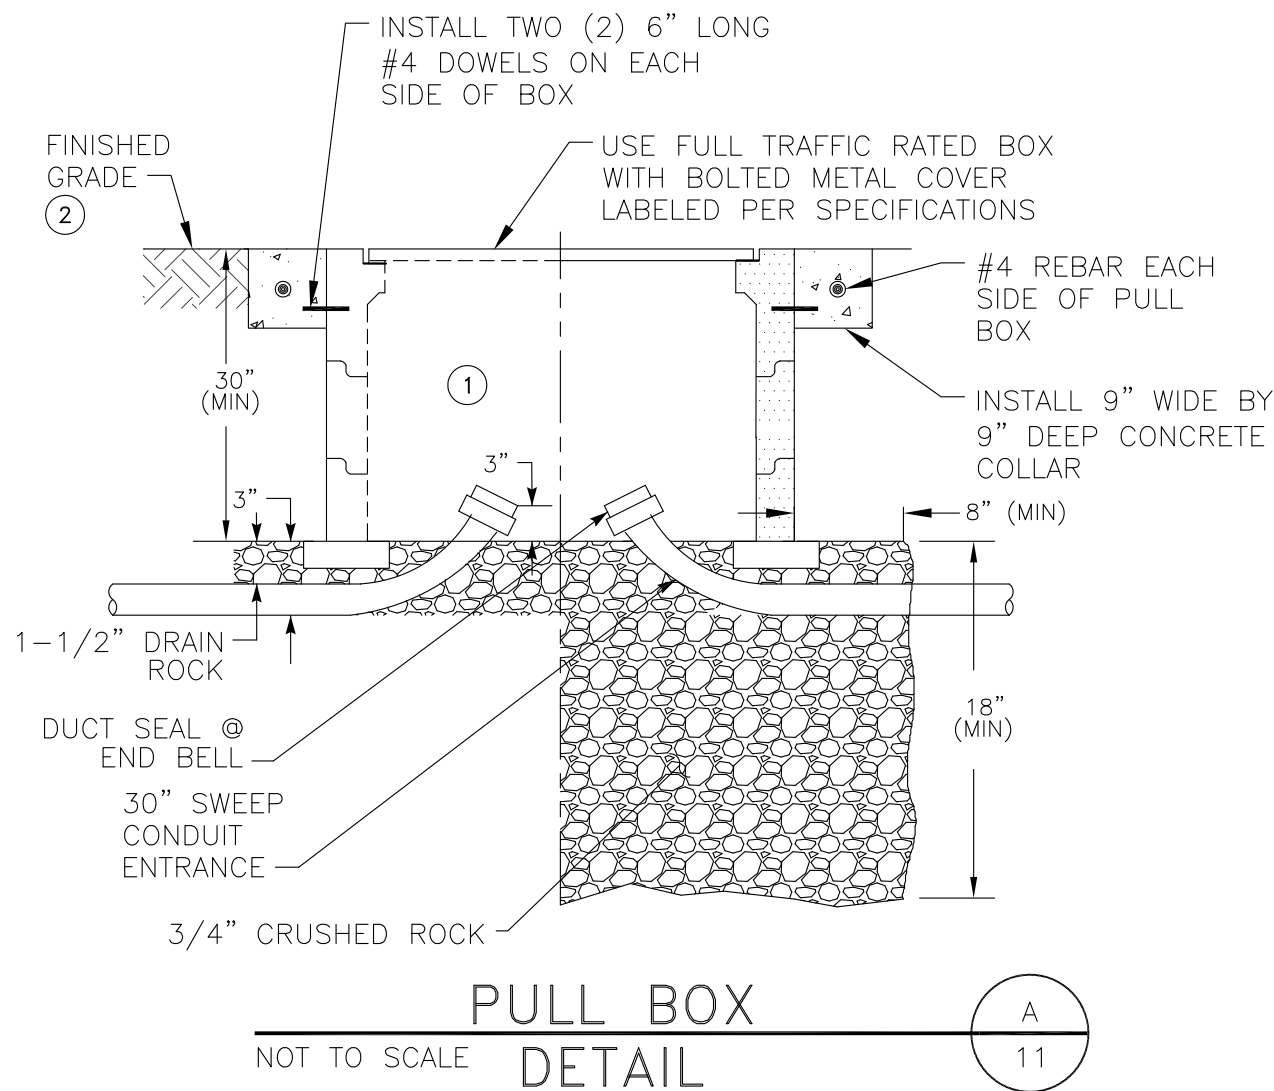
DATE: JULY 2024
CHK BY: AP

NO. DATE


REVISION

BY


\\ateem_fs\ATEEM_Files\ACADDWG\2024\2405B\2405B5HT011.dwg 7/3/2024 3:38 PM ATEEM



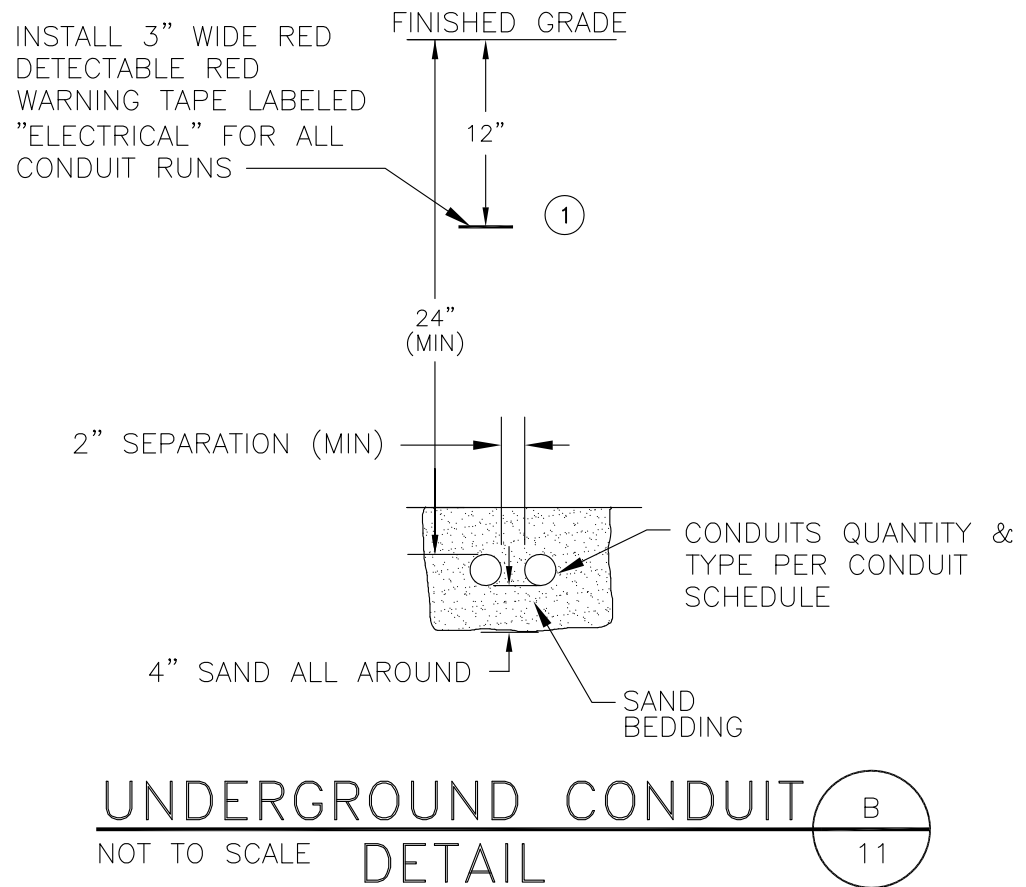
- NOTES: ① TRAFFIC RATED CHRISTY B2436 OR EQUAL, MINIMUM BOX SIZE. PROVIDE LARGER AT NO ADDITIONAL COST TO OWNER.
- ② ADD EXTENSIONS WHERE NECESSARY TO RAISE COVER TO FINISHED GRADE.



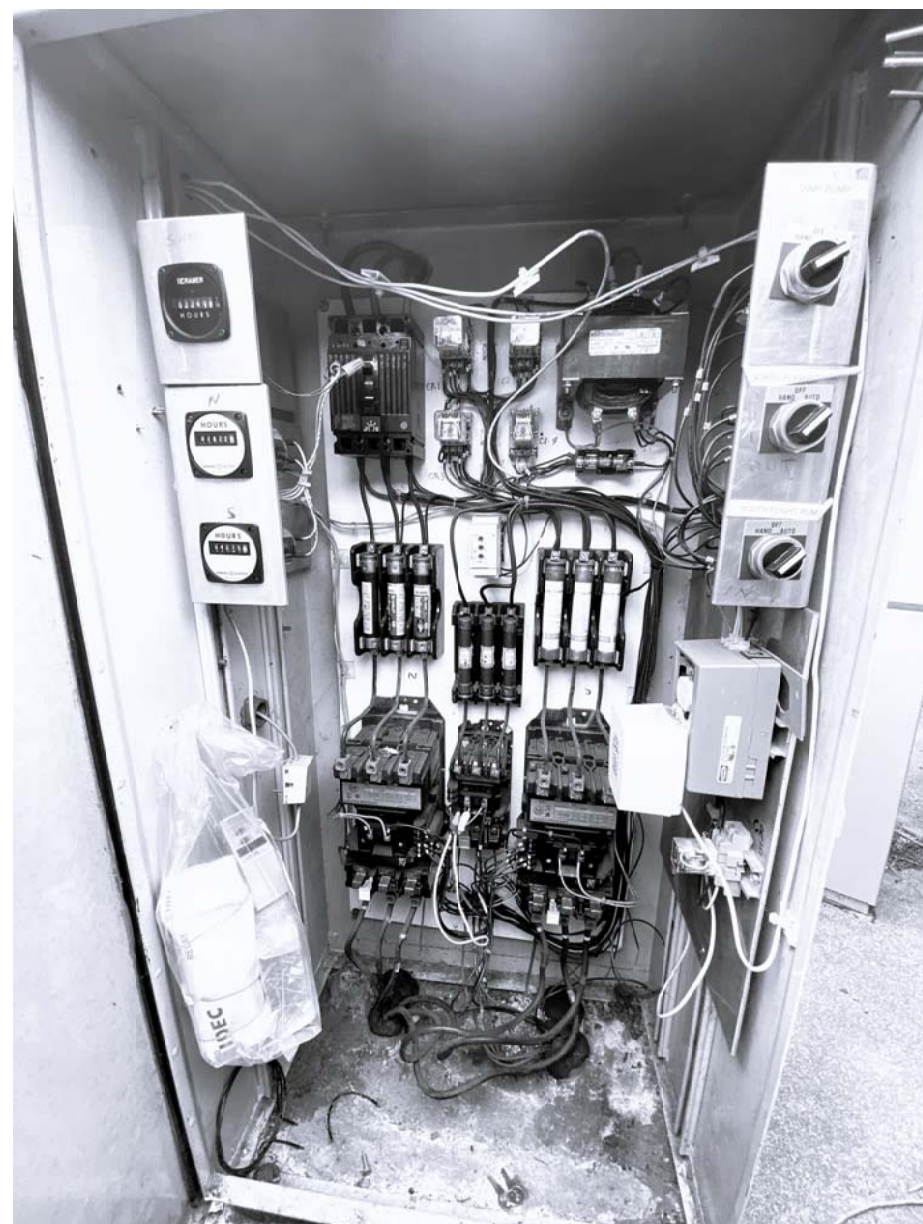- NOTES: ① TRENCHING & COMPACTED BACKFILL PER CITY STANDARDS.



EXISTING ELECTRICAL PANEL PHOTO

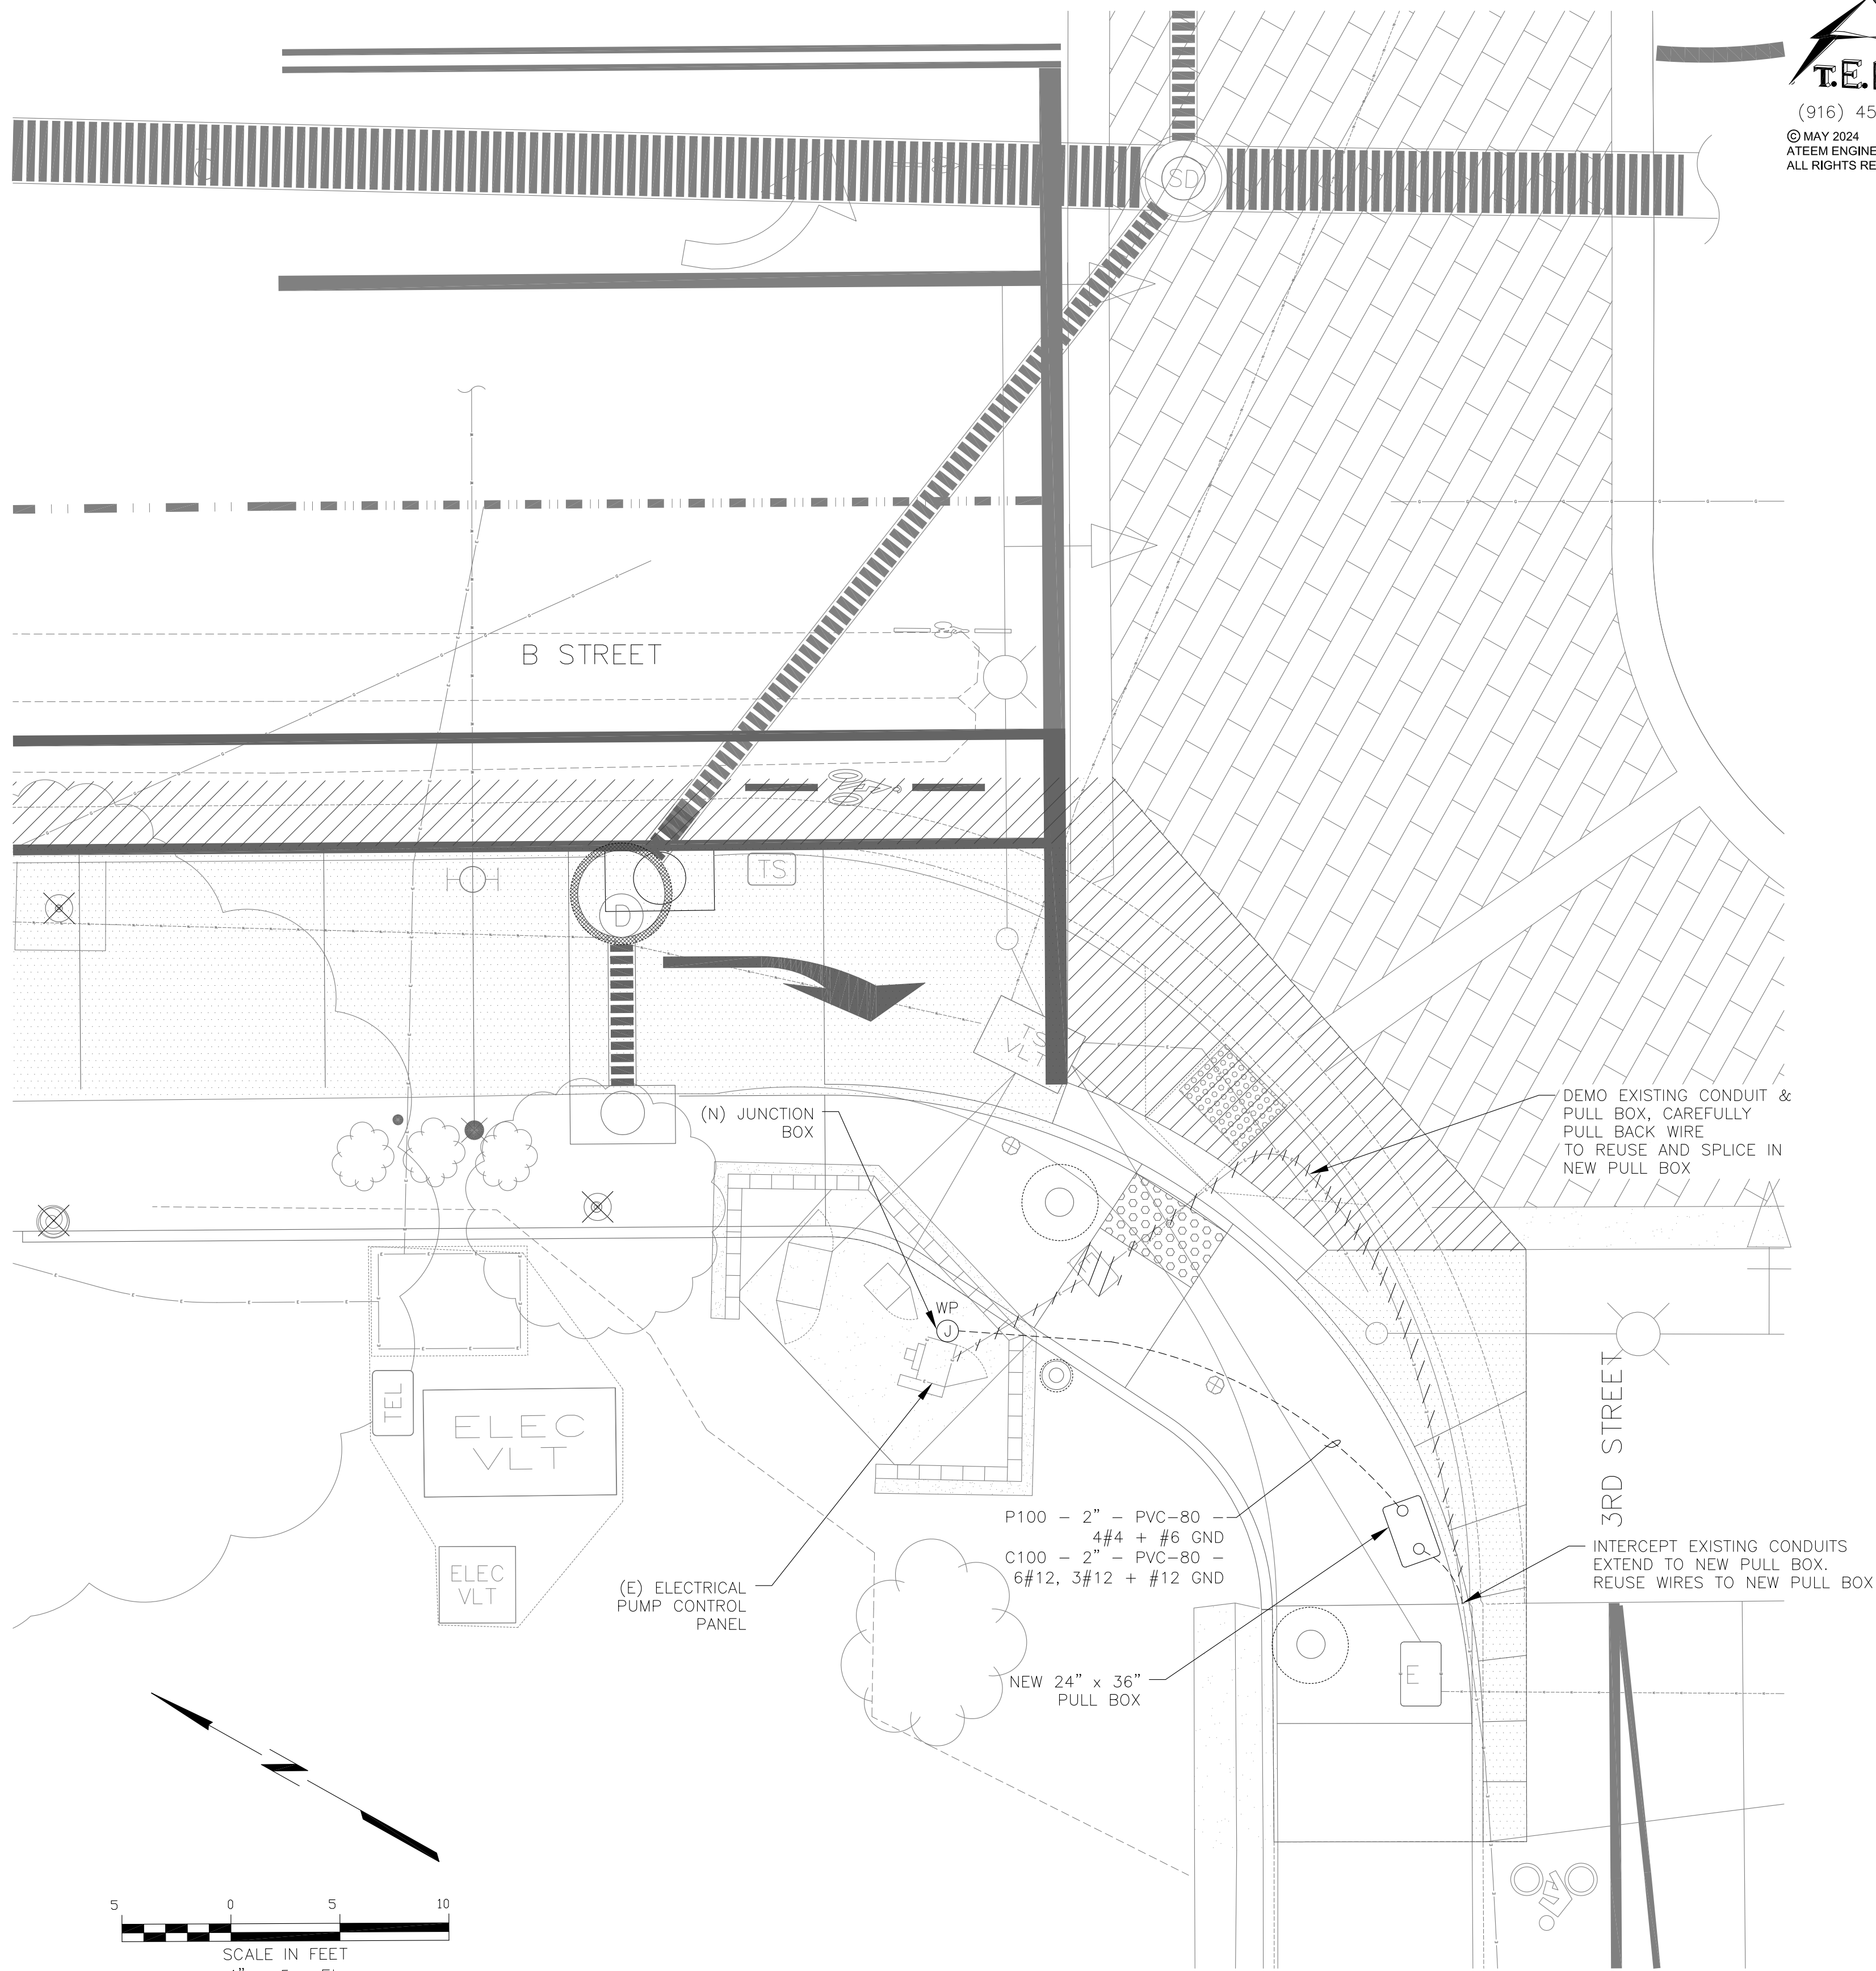

CURB RAMPS WEST SIDE (B STREET/3 RD STREET) ELECTRICAL PLAN

NO.	DATE	REVISION	BY

DATE: MAY 2024	CHK BY: SWK
SCALE: AS SHOWN	DWN BY: ZKV