





BEFORE EXCAVATING
CALL U.S.A.
UNDERGROUND SERVICE ALERT
CALL 811
TWO WORKING DAYS BEFORE ALL
PLANNED WORK OPERATIONS

IMPROVEMENT PLANS FOR LA PALOMA AVE, EAST HAVEN DR & ROGERS WY SEWER AND WATER SYSTEM IMPROVEMENTS

CONTRACT No. C00308

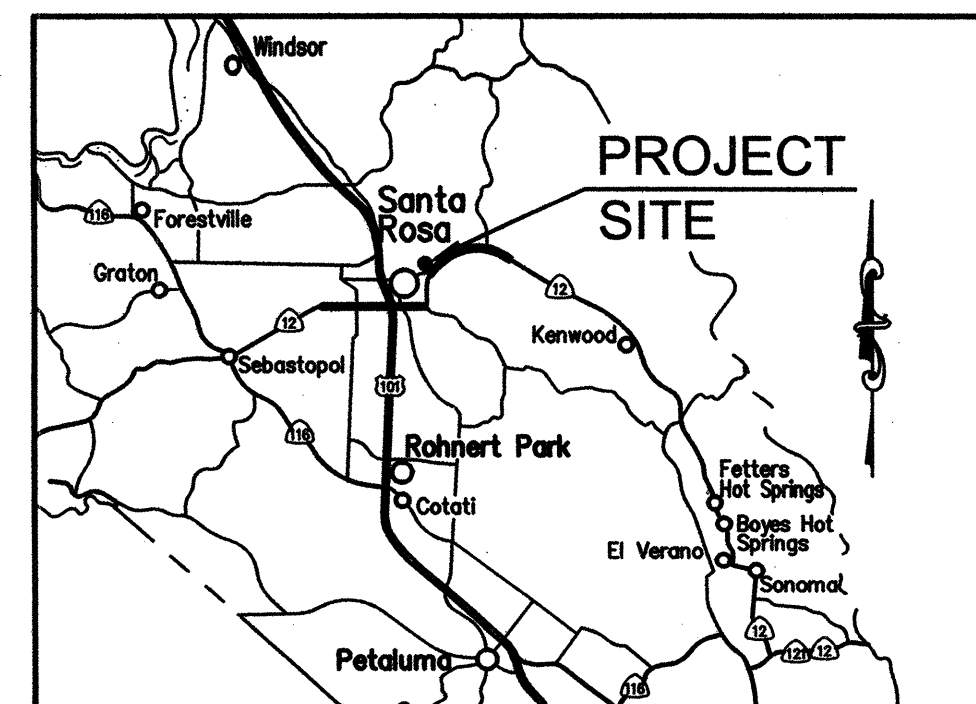

VICINITY MAP
NOT TO SCALE

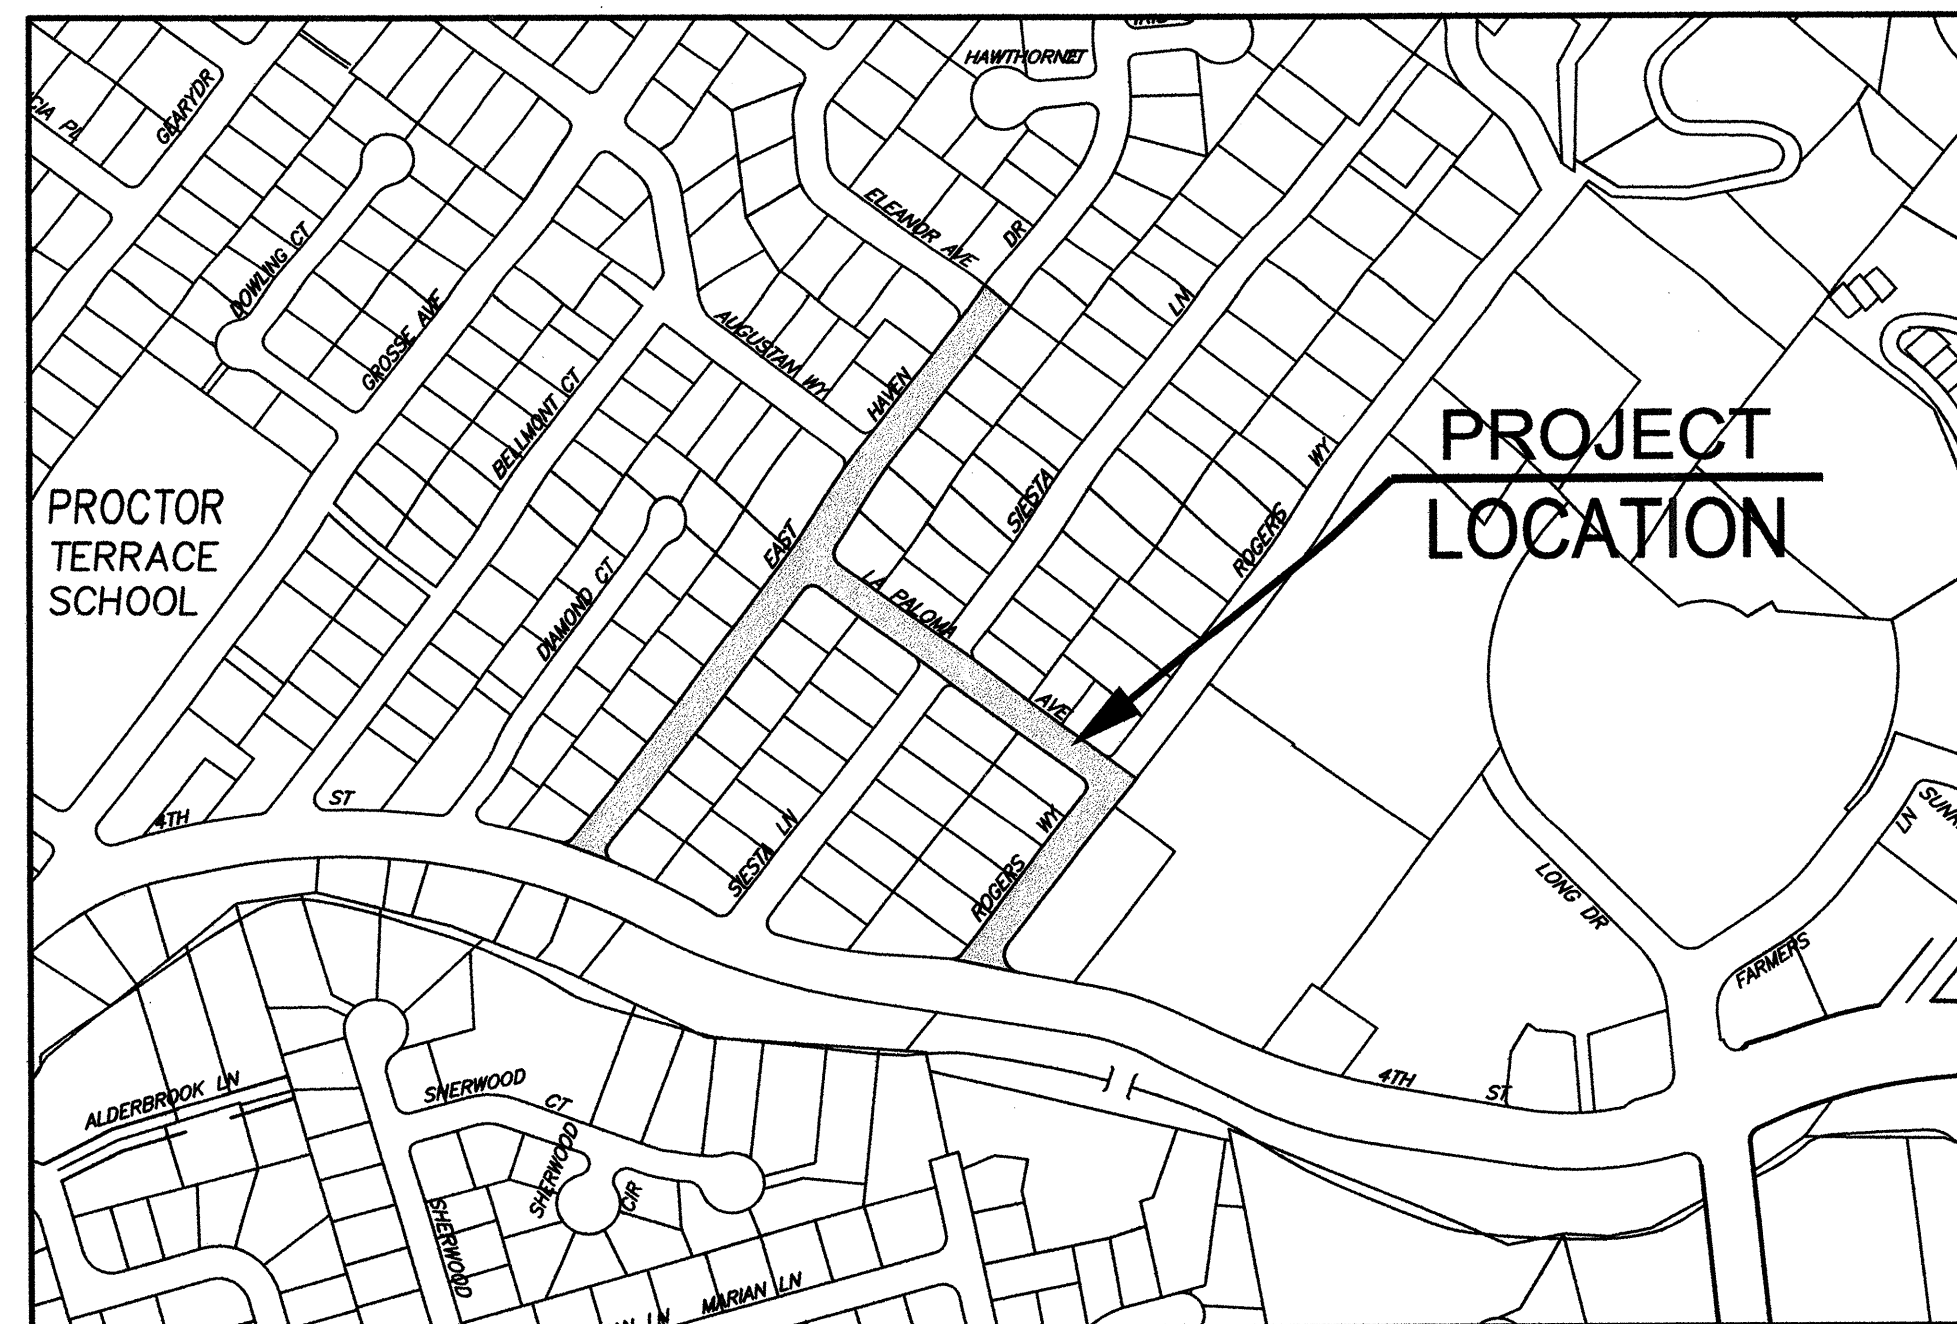

LOCATION MAP
NOT TO SCALE

INDEX OF SHEETS

Sheet Number	Sheet Title
1	TITLE SHEET
2	LEGEND, ABBREVIATIONS & GENERAL NOTES
3	SURVEY CONTROL PLAN
4	EAST HAVEN DR - PLAN & PROFILE STA. 10+75 TO STA. 15+75
5	EAST HAVEN DR - PLAN & PROFILE STA. 15+75 TO STA. 19+50
6	EAST HAVEN DR - PLAN & PROFILE STA. 19+50 TO STA. 23+50
7	LA PALOMA AVE - PLAN & PROFILE STA. 30+41.11 TO STA. 33+50
8	LA PALOMA AVE - PLAN & PROFILE STA. 33+50 TO STA. 36+50
9	ROGERS WAY - PLAN & PROFILE STA. 40+75 TO STA. 45+25
10	CURB RAMP DETAILS - EAST HAVEN AT LA PALOMA (SE)
11	CURB RAMP DETAILS - EAST HAVEN AT LA PALOMA (NW)
12	CURB RAMP DETAILS - EAST HAVEN AT FOURTH ST
13	CURB RAMP DETAILS - LA PALOMA AT SIESTA (N)
14	CURB RAMP DETAILS - LA PALOMA AT SIESTA (S)
15	CURB RAMP DETAILS - LA PALOMA AT ROGERS (NE)
16	CURB RAMP DETAILS - LA PALOMA AT ROGERS (SE)
17	CURB RAMP DETAILS - ROGERS AT FOURTH
18	EAST HAVEN DR CROSS SECTIONS - STA. 12+75 TO STA. 17+50
19	EAST HAVEN DR CROSS SECTIONS - STA. 17+75 TO STA. 22+50
20	LA PALOMA AVE CROSS SECTIONS - STA. 30+41.11 TO STA. 35+00
21	LA PALOMA AVE CROSS SECTIONS - STA. 35+25 TO STA. 36+02
22	ROGERS WAY CROSS SECTIONS - STA. 41+50 TO STA. 45+19.55
23	STRIPING PLAN - EAST HAVEN DR
24	STRIPING PLAN - LA PALOMA AVE AND ROGERS WAY
25	DETAILS

FINAL PAY ITEM

ROADWAY EXCAVATION 1,879 CY

RECORD PLAN DATA

PROJECT START:	WATER SERVICE TYPE:
PROJECT END:	MANUFACTURER:
GEN. CONTRACTOR:	FIRE HYDRANT TYPE:
SUPERINTENDENT:	MANUFACTURER:
UNDERGROUND CONTRACTOR:	INSPECTOR:
FOREMAN:	CONSTRUCTION MANAGER:
SEWER PIPE TYPE:	RECORD PLANS BY:
MANUFACTURER:	ADDITIONAL INFO:
SEWER FITTINGS MANUFACTURER:	
M.H. MANUFACTURER:	
WATER PIPE TYPE:	
WATER VALVE MANUFACTURER:	
WATER VALVE MANUFACTURER:	
WATER FITTINGS MANUFACTURER:	

PLANS PREPARED BY:

DESIGNED: WJK
DRAWN: WJK
CHECKED: SRV
PROJECT NO. 12-4014

BY:
STEVEN R. VAN SAUN, RCE 86180
DATE: 2/13/20

Coastland Civil Engineering, Inc.
1400 Neotomas Avenue, Santa Rosa, CA 95405
707.571.8005 707.571.8037 Fax

Signature	Dept.	By	Revision	No.	Date	DATE	SCALE	AS SHOWN	DWN BY	WJK	CHK BY	SRV	APPROVED: Deputy Director - Engineering	By	DATE	DATE	DATE	DATE
	Design/Const					FEBRUARY 2020												
	Survey																	
	TPW Field Svc's																	
	Water Dept Ops																	
	Traffic																	
	Permitting																	
	Storm Water																	

CITY OF SANTA ROSA
CAPITAL IMPROVEMENT PROJECT
LA PALOMA AVE, EAST HAVEN DR & ROGERS WY
SEWER AND WATER SYSTEM IMPROVEMENTS

CONTRACT NO. C00308

SHEET 1 OF 25

FILE NO. 2019-0050

Images: Xrefs: Data: -d.dwg:CSA-ENGINEERS STAMPS-C00308.dwg:CSA-ENGINEERS STAMPS-PLAN-2019.dwg
Print: F: C:\30 Projects\124014 La Paloma\DWG\124014-C00308.dwg Layout Name: 2 Plot Date: Feb 11, 2020 at 11:47

LEGEND

	EXISTING	NEW
SINGLE 1" WATER SERVICE		
WATER MAIN, GATE VALVE, CROSS, & TEMPORARY BLOW OFF		N/A
1" WATER SERVICE WITH TWO METERS		N/A
SINGLE 2" WATER SERVICE		N/A
4" MANIFOLD SERVICE		N/A
NEW WATER SERVICE, WATER METER WITH (E) BACK FLOW PREVENTION DEVICE		N/A
FIRE HYDRANT ASSEMBLY AND TEE		
WATER VAULT		N/A
SEWER LATERAL & CLEANOUT (DISTANCE FROM MAIN TO CLEANOUT)		
SEWER MAIN, MANHOLE & CLEANOUT AND FLOW DIRECTION		
ABANDONED SEWER PIPE		
STORM DRAIN		
STORM DRAIN CATCH BASIN		
SIDEWALK DRAIN DROP INLET		N/A
GAS		N/A
STREET LIGHT & ELECTRICAL		N/A
TELEPHONE		N/A
ABANDONED FACILITY		N/A
JOINT POLE AND GUY ANCHOR		N/A
STREET LIGHT		N/A
CITY MONUMENT		
STREET ADDRESS		N/A
A.P.N.	125-221-019	N/A
PROPERTY CORNER		N/A
PROPERTY LINE		N/A
FLOW LINE		N/A
ASPHALT CONCRETE	N/A	
TRENCH PAVING	N/A	
CONCRETE SIDEWALK & CURB RAMP		
DETECTABLE WARNING SURFACE	N/A	
LANDSCAPE VEGETATION - HEDGE		N/A
PG&E POT HOLE AND NUMBER	N/A	N/A
SURVEY CONTROL POINT		N/A
DECIDUOUS TREE / SHRUBS		N/A
SIGNS		N/A
POTHOLE		N/A

ABBREVIATIONS

AC	ASPHALT CONCRETE	GB	GRADE BREAK	TYP	TYPICAL
ACP	ASBESTOS CEMENT PIPE	G SER	GAS SERVICE	UG	UNDERGROUND
APN	ASSESSORS PARCEL NUMBER	IC	INTERCONNECT	UPC	UNIFORM PLUMBING CODE
ARV	AIR RELEASE VALVE	IG	INVERT GRADE	USA	UNDERGROUND SERVICE ALERT
BC	BEGIN CURVE	INV	INVERT GRADE	VC	VERTICAL CURVE
BFP	BACK FLOW PREVENTER	LF	LINEAR FEET	VCP	VITRIFIED CLAY PIPE
BO	BLOWOFF	LG	LIP OF GUTTER	VLT	VAULT
BRC	BEGIN REVERSE CURVE	LT	LEFT	VAR	VARIES
BSW	BACK OF SIDEWALK	PCC	POINT OF COMPOUND CURVE	WM	WATER MAIN
BWV	BACKWATER VALVE	PH	POTHOLE	WS	WATER SERVICE
BVC	BEGIN VERTICAL CURVE	PED	PEDESTRIAN	W SER	WATER SERVICE
CB	CATCH BASIN	PL	PROPERTY LINE	WTR, W	WATER
C&G	CURB & GUTTER	PVI	POINT OF VERTICAL	< PT	ANGLE POINT
CI	CAST IRON		INTERSECTION		
CL	CENTERLINE	PRV	PRESSURE REDUCING VALVE		
CLC	CONTROL LINE COORDINATE	OD	OUTSIDE DIMENSION		
CMP	CORRUGATED METAL PIPE	OH	OVERHEAD UTILITY		
CO	CLEANOUT	RC	RELATIVE COMPACTION		
CONC	CONCRETE	RCP	REINFORCED CONCRETE PIPE		
CR	CURB RETURN	R&R	REMOVE & REPLACE		
DET	DETECTOR	RT	RIGHT		
DI	DROP INLET	SD	STORM DRAIN		
DWY	DRIVEWAY	SDMH	STORM DRAIN MANHOLE		
EC	END CURVE	SS	SANITARY SEWER		
EFC	EAST FACE OF CURB	SS LAT	SANITARY SEWER LATERAL		
ELEC	ELECTRIC	SSMH	SANITARY SEWER MANHOLE		
ELEV	ELEVATIONS	SSCO	SANITARY SEWER		
EP	EDGE OF PAVEMENT		CLEANOUT		
EVC	END VERTICAL CURVE	STL	STEEL PIPE		
EX,(E)	EXISTING	STD	STANDARD		
FBG	FEET BELOW GRADE	SW	SIDEWALK		
FC	FACE OF CURB	TB	TOP OF BANK		
FG	FINISHED GRADE	TC	TOP OF CURB		
FL	FLOW LINE	TEL	TELEPHONE		
FLG	FLOW LINE OF GUTTER	TG	TOP OF GRATE		
FSW	FRONT OF SIDEWALK	TOP	TOP OF PIPE		
G	GAS	TS	TRAFFIC SIGNAL		

GENERAL NOTES


- ALL WORKMANSHIP, MATERIALS AND CONSTRUCTION SHALL CONFORM TO THE CITY OF SANTA ROSA STANDARD PLANS, THE CONSTRUCTION SPECIFICATIONS FOR PUBLIC IMPROVEMENTS, THE SPECIAL PROVISIONS FOR THIS PROJECT AND THE STATE STANDARD SPECIFICATIONS AND STANDARD PLANS. THE CONTRACTOR IS RESPONSIBLE FOR UNDERSTANDING ALL STANDARDS PERTAINING TO THIS PROJECT.
- THE CONTRACTOR SHALL CALL UNDERGROUND SERVICE ALERT (USA) AT 811 NO LESS THAN 2 WORKING DAYS PRIOR TO ANY EXCAVATION FOR MARK OUTS OF EXISTING UNDERGROUND FACILITIES IN ACCORDANCE WITH SECTION 5-1.36E OF THE SPECIAL PROVISIONS.
- THE LOCATIONS OF UNDERGROUND UTILITIES AND OTHER OBSTACLES SHOWN ON THE PLANS ARE BASED ON THE BEST AVAILABLE INFORMATION. THE CONTRACTOR SHALL POTHOLE AND DETERMINE THE EXACT LOCATION OF ALL POTENTIAL CONFLICTS IN ACCORDANCE WITH U.S.A. LAWS AND THESE SPECIAL PROVISIONS AND THE STANDARD SPECIFICATIONS. IF ANY UNMARKED UTILITIES ARE ENCOUNTERED, OR IF UNABLE TO LOCATE A MARKED UTILITY AFTER POT HOLING, THE CONTRACTOR SHALL IMMEDIATELY NOTIFY THE OWNER OF THAT UTILITY AND THE ENGINEER.
- THE CONTRACTOR SHALL PROTECT AND PRESERVE CITY MONUMENTS. THE CONTRACTOR SHALL COORDINATE WITH THE CITY ENGINEER 10 WORKING DAYS IN ADVANCE FOR REFERENCING OF EXISTING MONUMENTS TO BE DISTURBED. THE CONTRACTOR SHALL RECONSTRUCT DISTURBED MONUMENTS IN ACCORDANCE WITH CITY STANDARD 280.
- OVERHEAD UTILITY SERVICE DROPS ARE NOT SHOWN ON THE PLANS. THE CONTRACTOR SHALL INVESTIGATE THE SITE AND BE AWARE OF LIMITED CLEARANCES UNDER OVERHEAD UTILITY LINES AND LOW HANGING TREE BRANCHES. THE CONTRACTOR'S TRUCKS AND EXCAVATION EQUIPMENT SHALL BE SIZED SO THAT OVERHEAD WIRES AND TREE BRANCHES ARE NOT DAMAGED.
- ALL EXCAVATED MATERIAL SHALL BE DISPOSED OF AS GENERATED AND AT NO TIME SHALL THE CONTRACTOR PLACE EXCAVATED MATERIAL AT THE WORK SITE.
- THE CONTRACTOR SHALL ONLY REMOVE EXISTING TREES OR SHRUBS AS NOTED ON THE PLANS OR AS DIRECTED BY THE ENGINEER.
- FOR CLARITY OF EXISTING SUBSURFACE CONDITIONS, NOT ALL CROSSWALKS, STOP BARS, OR EXISTING PAVEMENT MARKINGS ARE SHOWN ON THE PLANS. TRAFFIC STRIPES, RAISED PAVEMENT MARKERS AND PAVEMENT MARKINGS DAMAGED DUE TO THE CONTRACTOR'S OPERATIONS SHALL BE REPLACED PER CITY OF SANTA ROSA TRAFFIC STANDARDS PART III, TRAFFIC MARKINGS. PATCHING OF DAMAGED MARKINGS WILL NOT BE ALLOWED WITHOUT PRIOR APPROVAL FROM THE ENGINEER. ALL DAMAGED RAISED PAVEMENT (NON-REFLECTIVE) MARKERS MUST BE CERAMIC.
- ATTENTION IS DIRECTED TO THE CONTRACTOR THAT PEA GRAVEL, RIVER RUN, OR SLOUGHING MATERIAL MAY BE ENCOUNTERED IN EXISTING UTILITY TRENCHES THROUGHOUT THE PROJECT.
- IN THE EVENT THAT HISTORIC REMAINS OF PREHISTORIC OR HISTORIC HUMAN ACTIVITIES ARE ENCOUNTERED DURING THE PROJECT ALL GROUND DISTURBING ACTIVITY IN THE VICINITY OF THE FINDS SHALL CEASE AND THE ENGINEER SHALL BE IMMEDIATELY CONTACTED. WORK SHALL NOT RESUME UNTIL AN ARCHEOLOGIST HAS COMPLETED AN EVALUATION OF SIGNIFICANCE.

INTERCONNECT NOTES

- TRAFFIC SIGNAL INTERCONNECT IS KNOWN TO BE INSTALLED IN 4th STREET. CONTRACTOR SHALL BE RESPONSIBLE FOR LOCATING AND POTHOLING. ANY REPAIR TO INTERCONNECT SHALL BE DONE UNDER CITY INSPECTION.
- ALL LOOP DETECTION DAMAGED BY CONSTRUCTION TO BE REPLACED, EXCEPT AS NOTED. THE LOOPS IN ROGERS WAY ARE NOT ACTIVE AND DO NOT NEED TO BE REPLACED IF DAMAGED, BUT THE EXISTING DETECTOR HANDHOLES AND RELATED CONDUITS ARE TO BE KEPT FUNCTIONAL FOR FUTURE USE, TO THE SATISFACTION OF THE ENGINEER.
- WHERE CAMERA DETECTION IS USED AT INTERSECTIONS, ALL ADVANCE LOOP DETECTION MUST BE REPLACED IF DAMAGED.
- TRAFFIC SIGNAL INTERCONNECT WHERE LOCATED BY USA CAN BE VERY SHALLOW. CONTRACTOR SHALL BE RESPONSIBLE FOR ANY DAMAGE WHERE LOCATED. ANY REPAIR TO INTERCONNECT OR ELECTRICAL SHALL BE INSPECTED BY THE CITY OF SANTA ROSA PUBLIC WORKS ELECTRICAL DEPARTMENT. IF DAMAGED THE ENTIRE RUN OF SIGNAL INTERCONNECT CABLE SHALL BE REPLACED WITHOUT SPLICES, CONTROLLER TO CONTROLLER.


CONSTRUCTION NOTE DESIGNATIONS

- (D1) = STORM DRAIN AND RELATED ITEMS.
(R1) = ROADWAY AND RELATED ITEMS.
(S1) = SEWER AND RELATED ITEMS.
(T1) = TRAFFIC STRIPING AND RELATED ITEMS.
(W1) = WATER AND RELATED ITEMS.

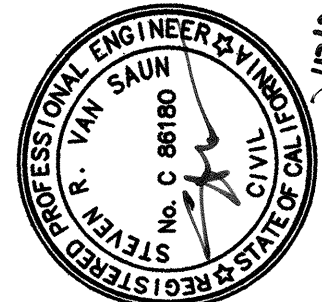


SCALE:	AS SHOWN	DATE:	REVISION	BY
DWN BY:	WJK	CHK BY:	SRV	
APPROVED:	Deputy Director - Engineering	DATE:	2/25/2020	
By:	LORI URBANEK			

CITY OF SANTA ROSA CAPITAL IMPROVEMENT PROJECT LA PALOMA AVE, EAST HAVEN DR & ROGERS WY SEWER AND WATER SYSTEM IMPROVEMENTS	CONTRACT NO. C00308
LEGEND, ABBREVIATIONS & GENERAL NOTES	SHEET 2 OF 25
	FILE NO.2019-0050

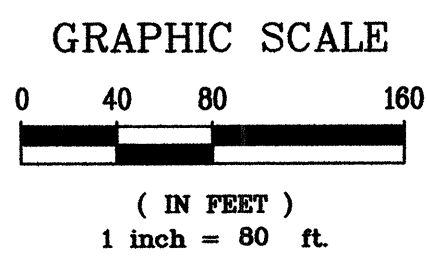

East Haven Drive Centerline Alignment Control Table				
Number	Length	Direction	Start Coordinate	End Coordinate
L1	1275.00	S36° 52' 55.61"W	N=1927693.88 E=6363432.59	N=1926674.04 E=6362667.37

Rogers Way Centerline Alignment Control Table				
Number	Length	Direction	Start Coordinate	End Coordinate
L3	615.00	S36° 45' 24.19"W	N=1926975.78 E=6363635.87	N=1926483.05 E=6363267.84

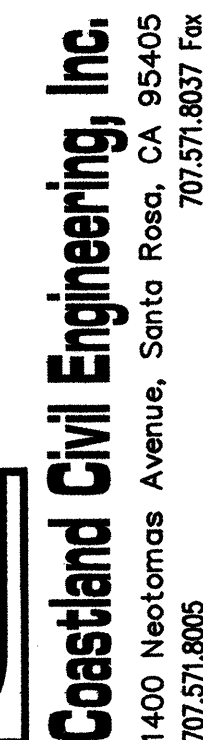

SCALE:	AS SHOWN	DATE:	FEBRUARY 2020	NO.	DATE	REVISION	BY
DWN BY:	WUK	---	---	CHK BY:	SRV		
APPROVED: Deputy Director -- Engineering							
 Date 2/25/2023							

CITY OF SANTA ROSA
CAPITAL IMPROVEMENT PROJECT
LA PALOMA AVE, EAST HAVEN DR & ROGERS WY
SEWER AND WATER SYSTEM IMPROVEMENTS
SURVEY CONTROL PLAN

CONTRACT NO. C00308
SHEET 3 OF 25
FILE NO.2019-005

FILE NO.2019-0050

Profile view of a sewer line from station 11+00 to 15+75. The profile shows the existing ground at the control line, the finish ground at the control line, and the sewer pipe. The pipe is 302 LF of 8-inch PVC SS with a slope of 0.004. It includes two manholes: SSMH#24 at station 12+07.44 and SSMH#25 at station 15+13.85. The profile also shows various pipe segments, including 4-inch PVC W, 8-inch PVC W, and 10-inch PVC SS. The profile is labeled "PROFILE" and "HORIZ: 1" = 20' VERT: 1" = 4'".



Key features and data points:

- Station 11+00: 196.8
- Station 11+50: 196.6
- Station 12+00: 196.7
- Station 12+50: 196.4
- Station 13+00: 195.9
- Station 13+50: 195.35
- Station 14+00: 194.9
- Station 14+50: 194.33
- Station 15+00: 194.2
- Station 15+50: 194.0
- Station 15+75: 193.99

Profile details:


- EXISTING GROUND AT CONTROL LINE
- FINISH GROUND AT CONTROL LINE
- 36" MIN
- 8" PVC W (PC 235)
- 140' OF RESTRAINED JOINTS PER CITY STD 850
- 302 LF - 8" PVC SS S=0.004
- (E) 6" VCP
- SSMH#24 RIM=196.72
- STA = 12+07.44 (0.63' RT)
- 8" INV IN = 189.45 (NW)
- 8" INV IN = 189.26 (NE)
- 8" INV OUT = 189.25 (SW)
- SSMH#25 RIM=194.15
- STA = 15+13.85 (0.26' LT)
- 10" INV IN = 186.99 (SW)
- 8" INV IN = 188.04 (NE)
- 10" INV OUT = 186.95 (NW)

Matchline STA. 15+75 SEE SHEET NO. 5

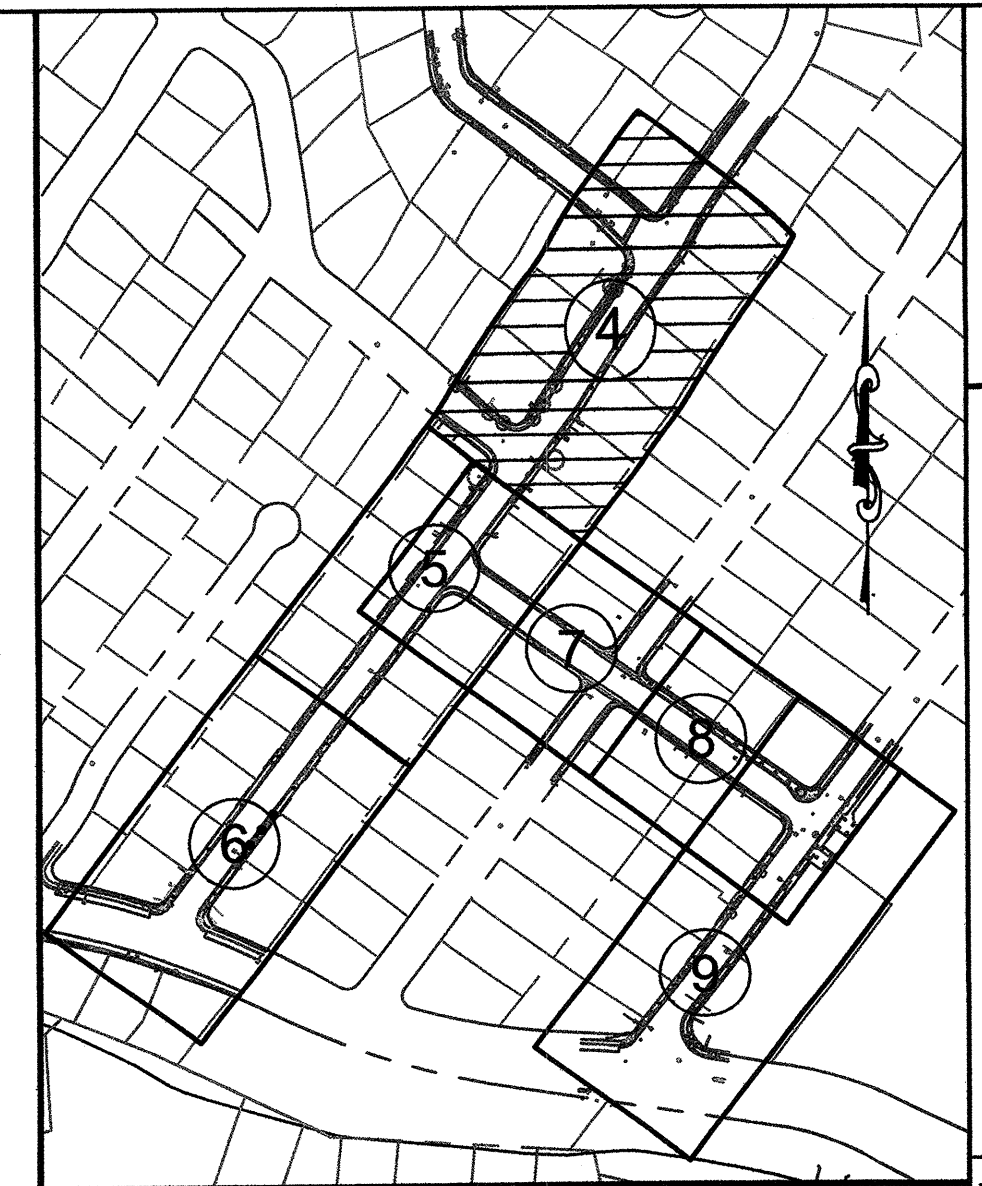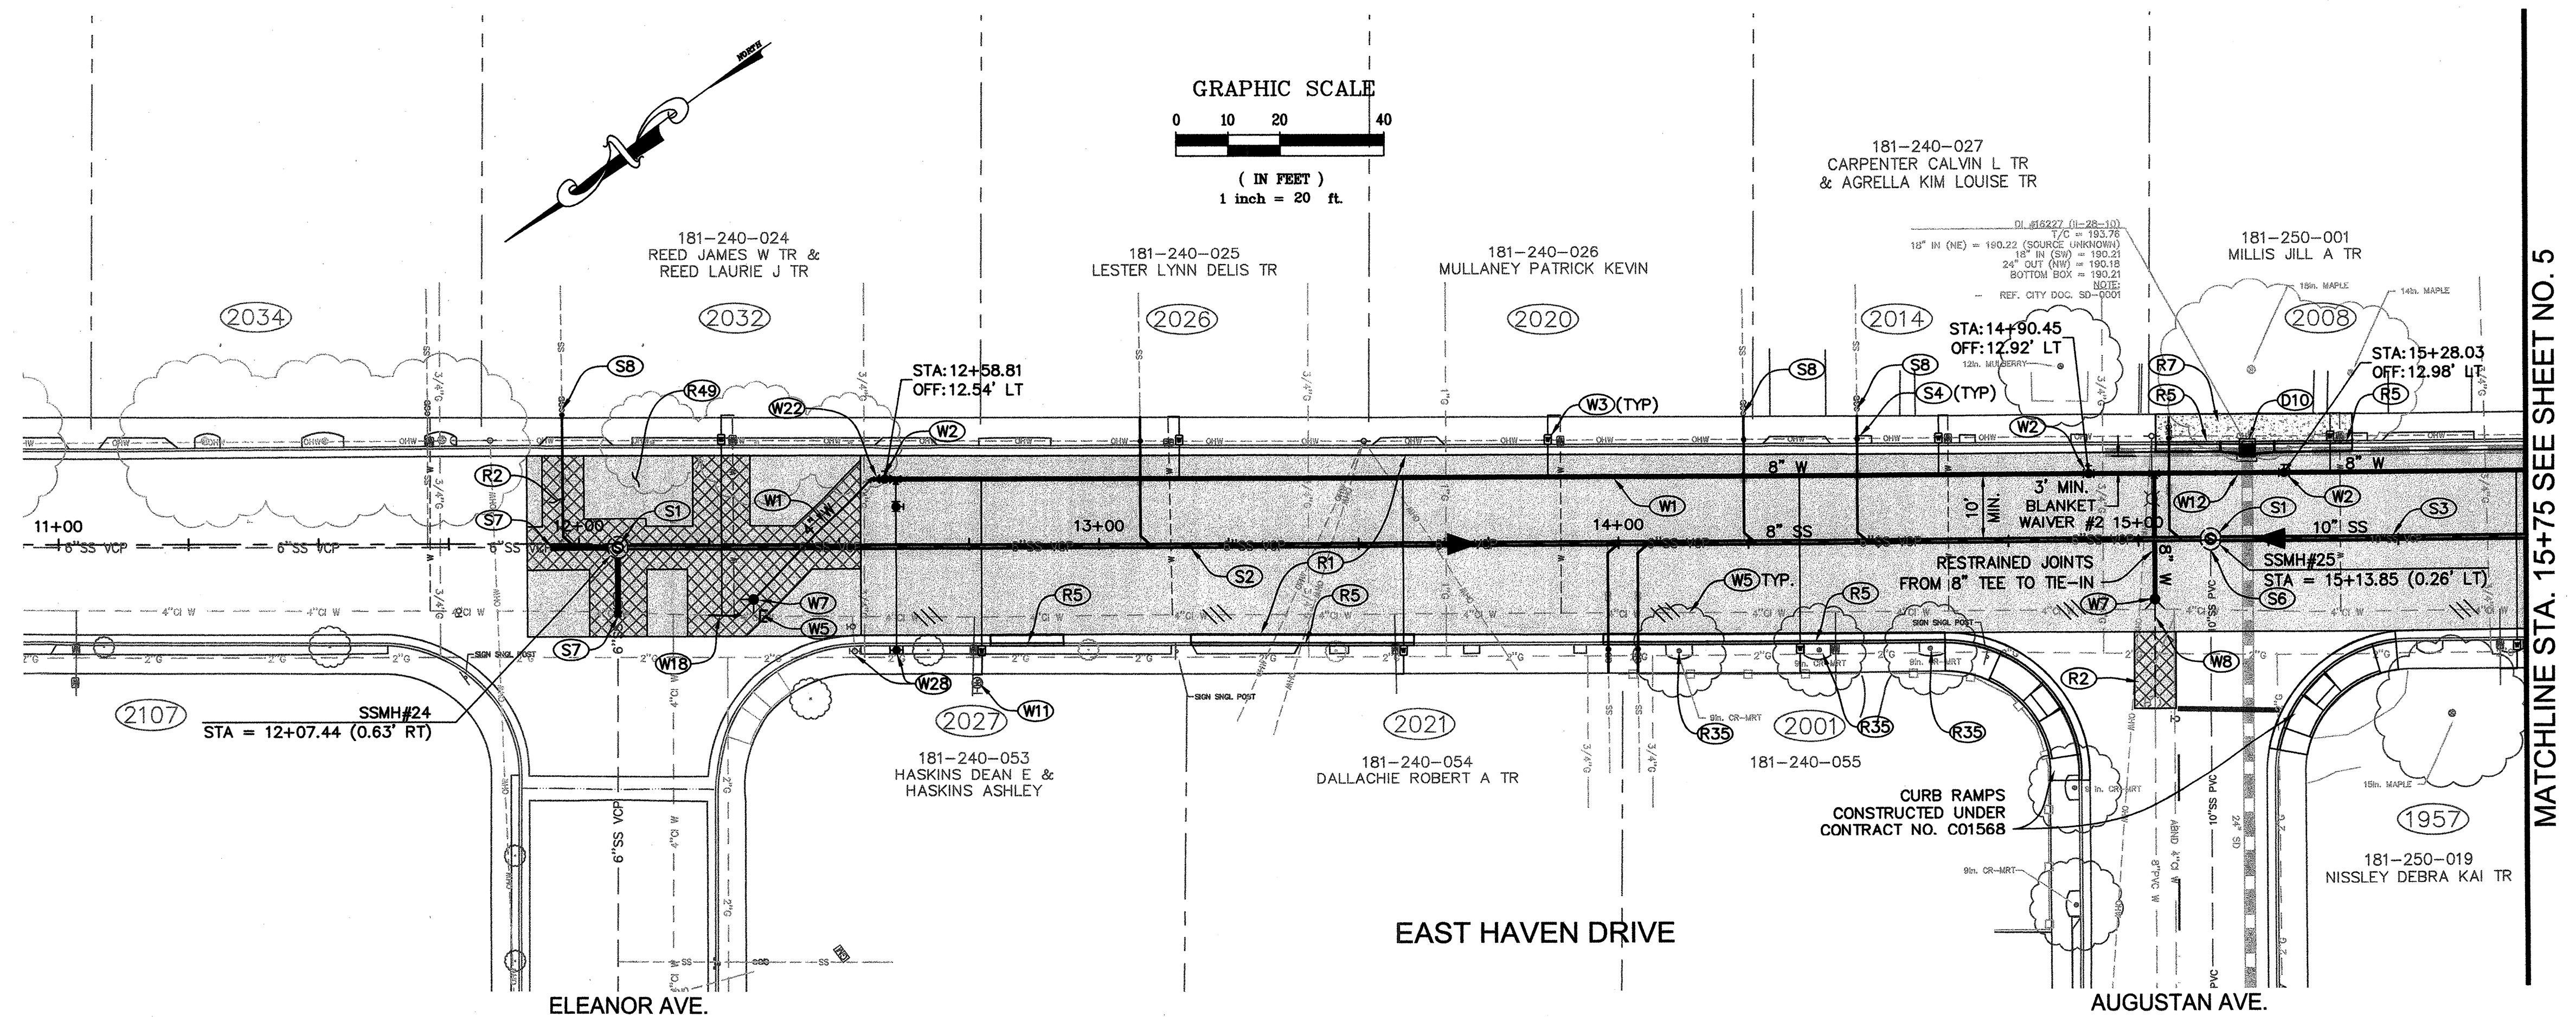

CONSTRUCTION NOTES:



- (R1) REMOVE EXISTING CATCH BASIN AND INSTALL TYPE I CATCH BASIN PER CITY STD. 403.
- (R1) RECONSTRUCT PAVEMENT PER TYPICAL SECTION DETAIL — (1/25)
- (R2) PLACE PERMANENT TRENCH PAVING PER CITY STD 215.
- (R5) REMOVE & REPLACE EXISTING CURB AND GUTTER PER CITY STD 241.
- (R7) REMOVE & REPLACE SIDEWALK PER CITY STD 237.
- (R35) PRUNE ROOTS AND INSTALL ROOT BARRIER.
- (R49) GRIND 0.25' OF EXISTING AC & PLACE 0.25' OF AC SURFACE OUTSIDE PERMANENT TRENCH PAVING FROM STA. 11+90 TO STA. 12+54±
- (S1) REMOVE EXISTING MANHOLE AND INSTALL 48" SANITARY SEWER MANHOLE PER CITY STD 500.
- (S2) REMOVE EXISTING SANITARY SEWER MAIN AND INSTALL 8" SANITARY SEWER MAIN.
- (S3) REMOVE EXISTING SANITARY SEWER MAIN AND INSTALL 10" SANITARY SEWER MAIN.
- (S4) REMOVE EXISTING SANITARY SEWER LATERAL FROM SEWER MAIN TO BACK OF SIDEWALK AND INSTALL 4" SANITARY SEWER LATERAL PER CITY STD 513A.
- (S6) CONNECT EXISTING MAIN TO NEW SSMH PER CITY STANDARDS.
- (S7) INSTALL 10' OF 8" SANITARY SEWER PIPE, 8"x 6" ECCENTRIC REDUCER AND TIE-IN TO EXISTING SEWER MAIN. INSTALL FITTINGS AS REQUIRED UNDER CITY INSPECTION.
- (S8) REMOVE EXISTING SSCO BEHIND SIDEWALK.
- (W1) INSTALL WATER MAIN.
- (W2) INSTALL GATE VALVE PER CITY STD 877.
- (W3) INSTALL 1" WATER SERVICE PLUMBED FOR 5/8"x 3/4" METER PER CITY STD. 863A. CONNECT TO EXISTING WATER SERVICE.
- (W5) REMOVE OR ABANDON EXISTING WATER SYSTEM COMPONENTS (TYP) PER CITY WATER DISTRIBUTION STANDARD SPECIFICATIONS.
- (W7) INSTALL TEMPORARY BLOW OFF PER CITY STD 859 AND SPECIFICATIONS.
- (W8) REMOVE EXISTING PIPE AS REQUIRED TO INSTALL NEW MAIN & CONNECT TO EXISTING 8" WATER VALVE UNDER CITY INSPECTION.
- (W11) RE-CERTIFY BACKFLOW DEVICE AFTER NEW WATER METER INSTALLED PER CITY STANDARDS.
- (W12) HALF WATER MAIN LOWERING BELOW EXISTING 24" SD PER CITY BLANKET WAIVER 6.
- (W18) TIE-IN TO EXISTING WATER MAIN & INSTALL 1" WATER SERVICE PER CONSTRUCTION NOTE W3 AS SINGLE OPERATION. INSTALL FITTINGS AS REQUIRED UNDER CITY INSPECTION.
- (W20) ROPE PIPE PER CITY STDS AS NEEDED. INSTALLATION SHALL NOT EXCEED MANUFACTURER'S RECOMMENDED MAXIMUM DEFLECTION.
- (W22) INSTALL 8"x 4" REDUCER AND FITTINGS AS REQUIRED. UNDER CITY INSPECTION.
- (W28) REMOVE EXISTING FIRE HYDRANT & APPURTENANCES & SALVAGE FIRE HYDRANT TO CITY. INSTALL RESIDENTIAL FIRE HYDRANT PER CITY STD. 857, PROVIDE 4' CLEAR TO BACK OF SIDEWALK.

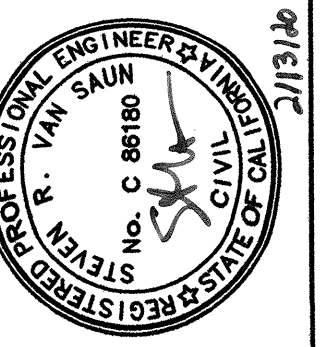

Coastland Civil Engineering, Inc.
1400 Neotomas Avenue, Santa Rosa, CA 95405
707.571.8005 707.571.8037 Fax

CITY OF SANTA ROSA		CONTRACT NO.	NO.	DATE	REVISION	BY
CAPITAL IMPROVEMENT PROJECT		C00308				
LA PALOMA AVE, EAST HAVEN DR & ROGERS WY						
SEWER AND WATER SYSTEM IMPROVEMENTS						
EAST HAVEN DR - PLAN & PROFILE						
STA. 10+75 TO STA. 15+75						
SCALE: AS SHOWN DWG BY: WJK CHK BY: SRV APPROVED: Deputy Director - Engineering By <i>Lori Urbanek</i> Date <u>2/26/2020</u> LORI URBANEK						

Images: 2018_Merged_Aerial.tif; Xrefs: CSR-ENGINEERS STAMPS-PLAN-2016.dwg\24014-TP.dwg;BM07.DWG\24014-RAMPS.DWG
 Path: F:\Civil 3D Projects\24014 La Paloma\DWG\24014-SP.DWG Layout Name: SHT-4 Plot Date: Feb 11, 2020 at 11:37

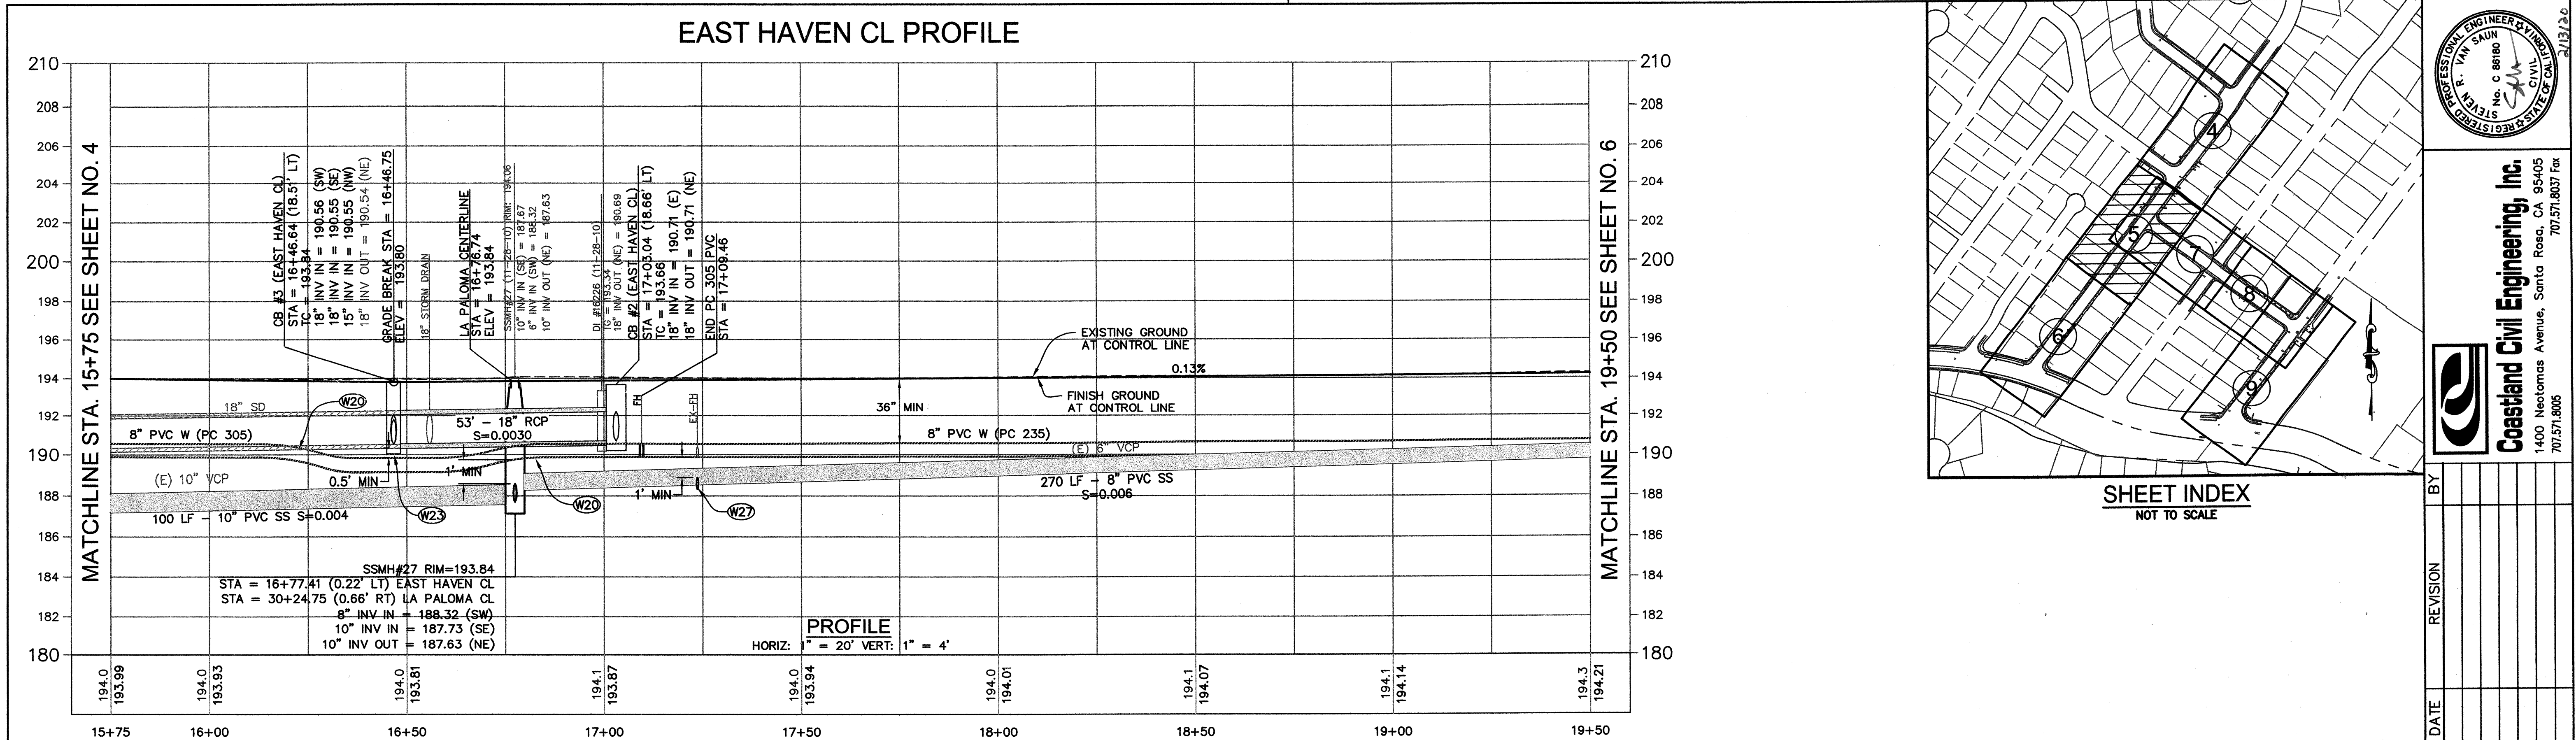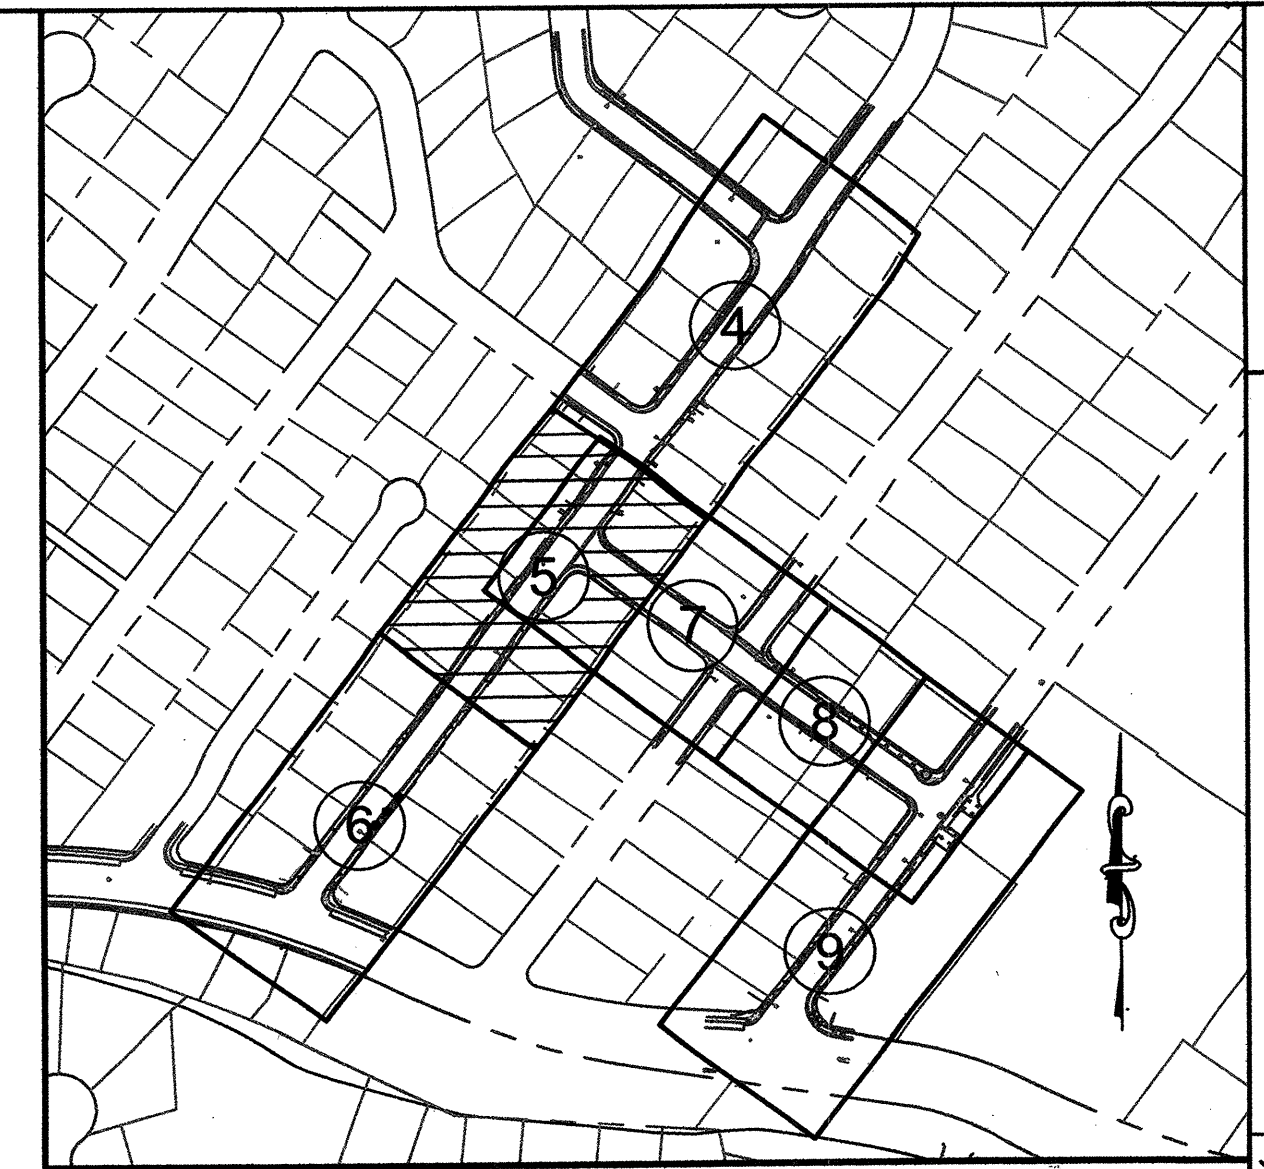

-

CITY OF SANTA ROSA										CONTRACT NO. C00308									
CAPITAL IMPROVEMENT PROJECT																			
LA PALOMA AVE, EAST HAVEN DR & ROGERS WY																			
SEWER AND WATER SYSTEM IMPROVEMENTS																			
EAST HAVEN DR - PLAN & PROFILE																			
STA. 15+75 TO STA. 19+50																			
SCALE: AS SHOWN		---		DATE: FEBRUARY 2020		BY													
DWN BY: WJK		---		CHK BY: SRV		---													
APPROVED: Deputy Director - Engineering																			
By <i>[Signature]</i> Date <i>2-26-2020</i>																			
LORI URBANEK																			
										</									

MATCHLINE STA. 19+50 SEE SHEET NO. 5

PROFILE
HORIZ: 1" = 20' VERT: 1" = 4'

Key Features and Data:

- Station 19+77.39 (0.07' RT):** SSMH#28 RIM=194.24
8" INV IN = 189.98 (SW)
8" INV OUT = 189.96 (NE)
- Station 20+50.00:** GRADE BREAK STA = 20+50.00 ELEV = 194.34
- Station 22+42.23:** GRADE BREAK STA = 22+42.23 ELEV = 193.21
- Station 22+37.78 (0.27' LT):** SSMH#28A RIM=195.19
8" INV OUT = 191.27 (NE)
- Station 22+75.47:** GRADE BREAK STA = 22+75.47 ELEV = 196.72

Pipe Segments:



- 27 LF 8" PVC SS S=0.006
- 8" PVC W (PC 235)
- 258 LF - 8" PVC SS S=0.005 (E) 6" VCP
- 8" PVC W (PC 235)

Grades and Slopes:

- 0.13%
- 0.45%
- 4.54%

Other Notes:


- 107' OF RESTRAINED JOINTS PER CITY STD 850
- EXISTING GROUND AT CONTROL LINE
- FINISH GROUND AT CONTROL LINE
- EXISTING 12" WATER

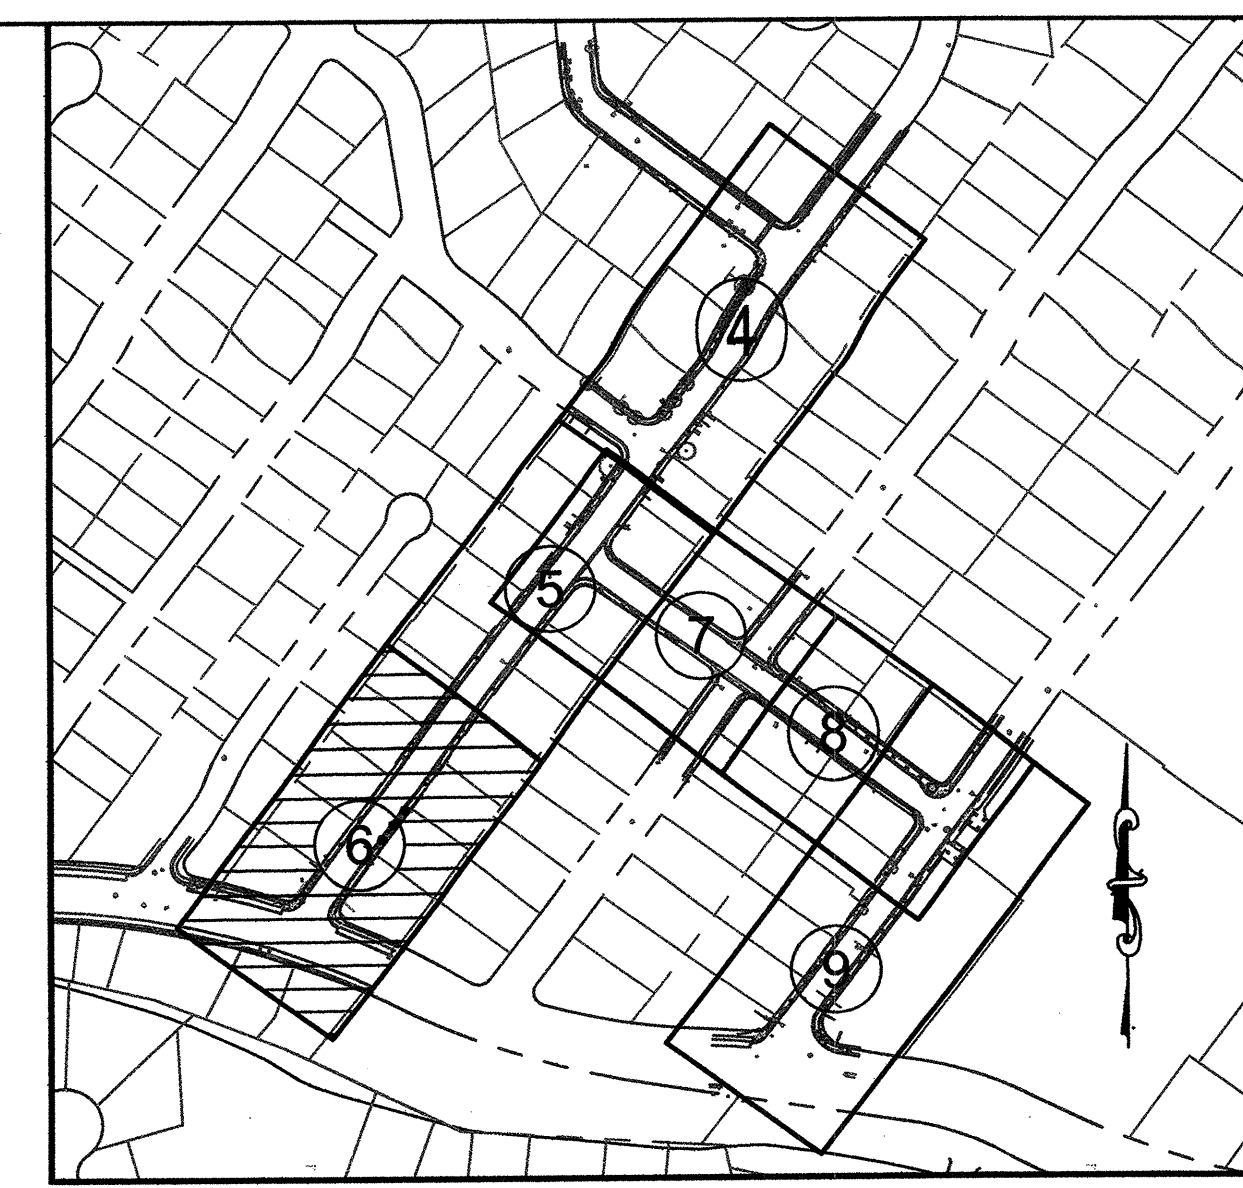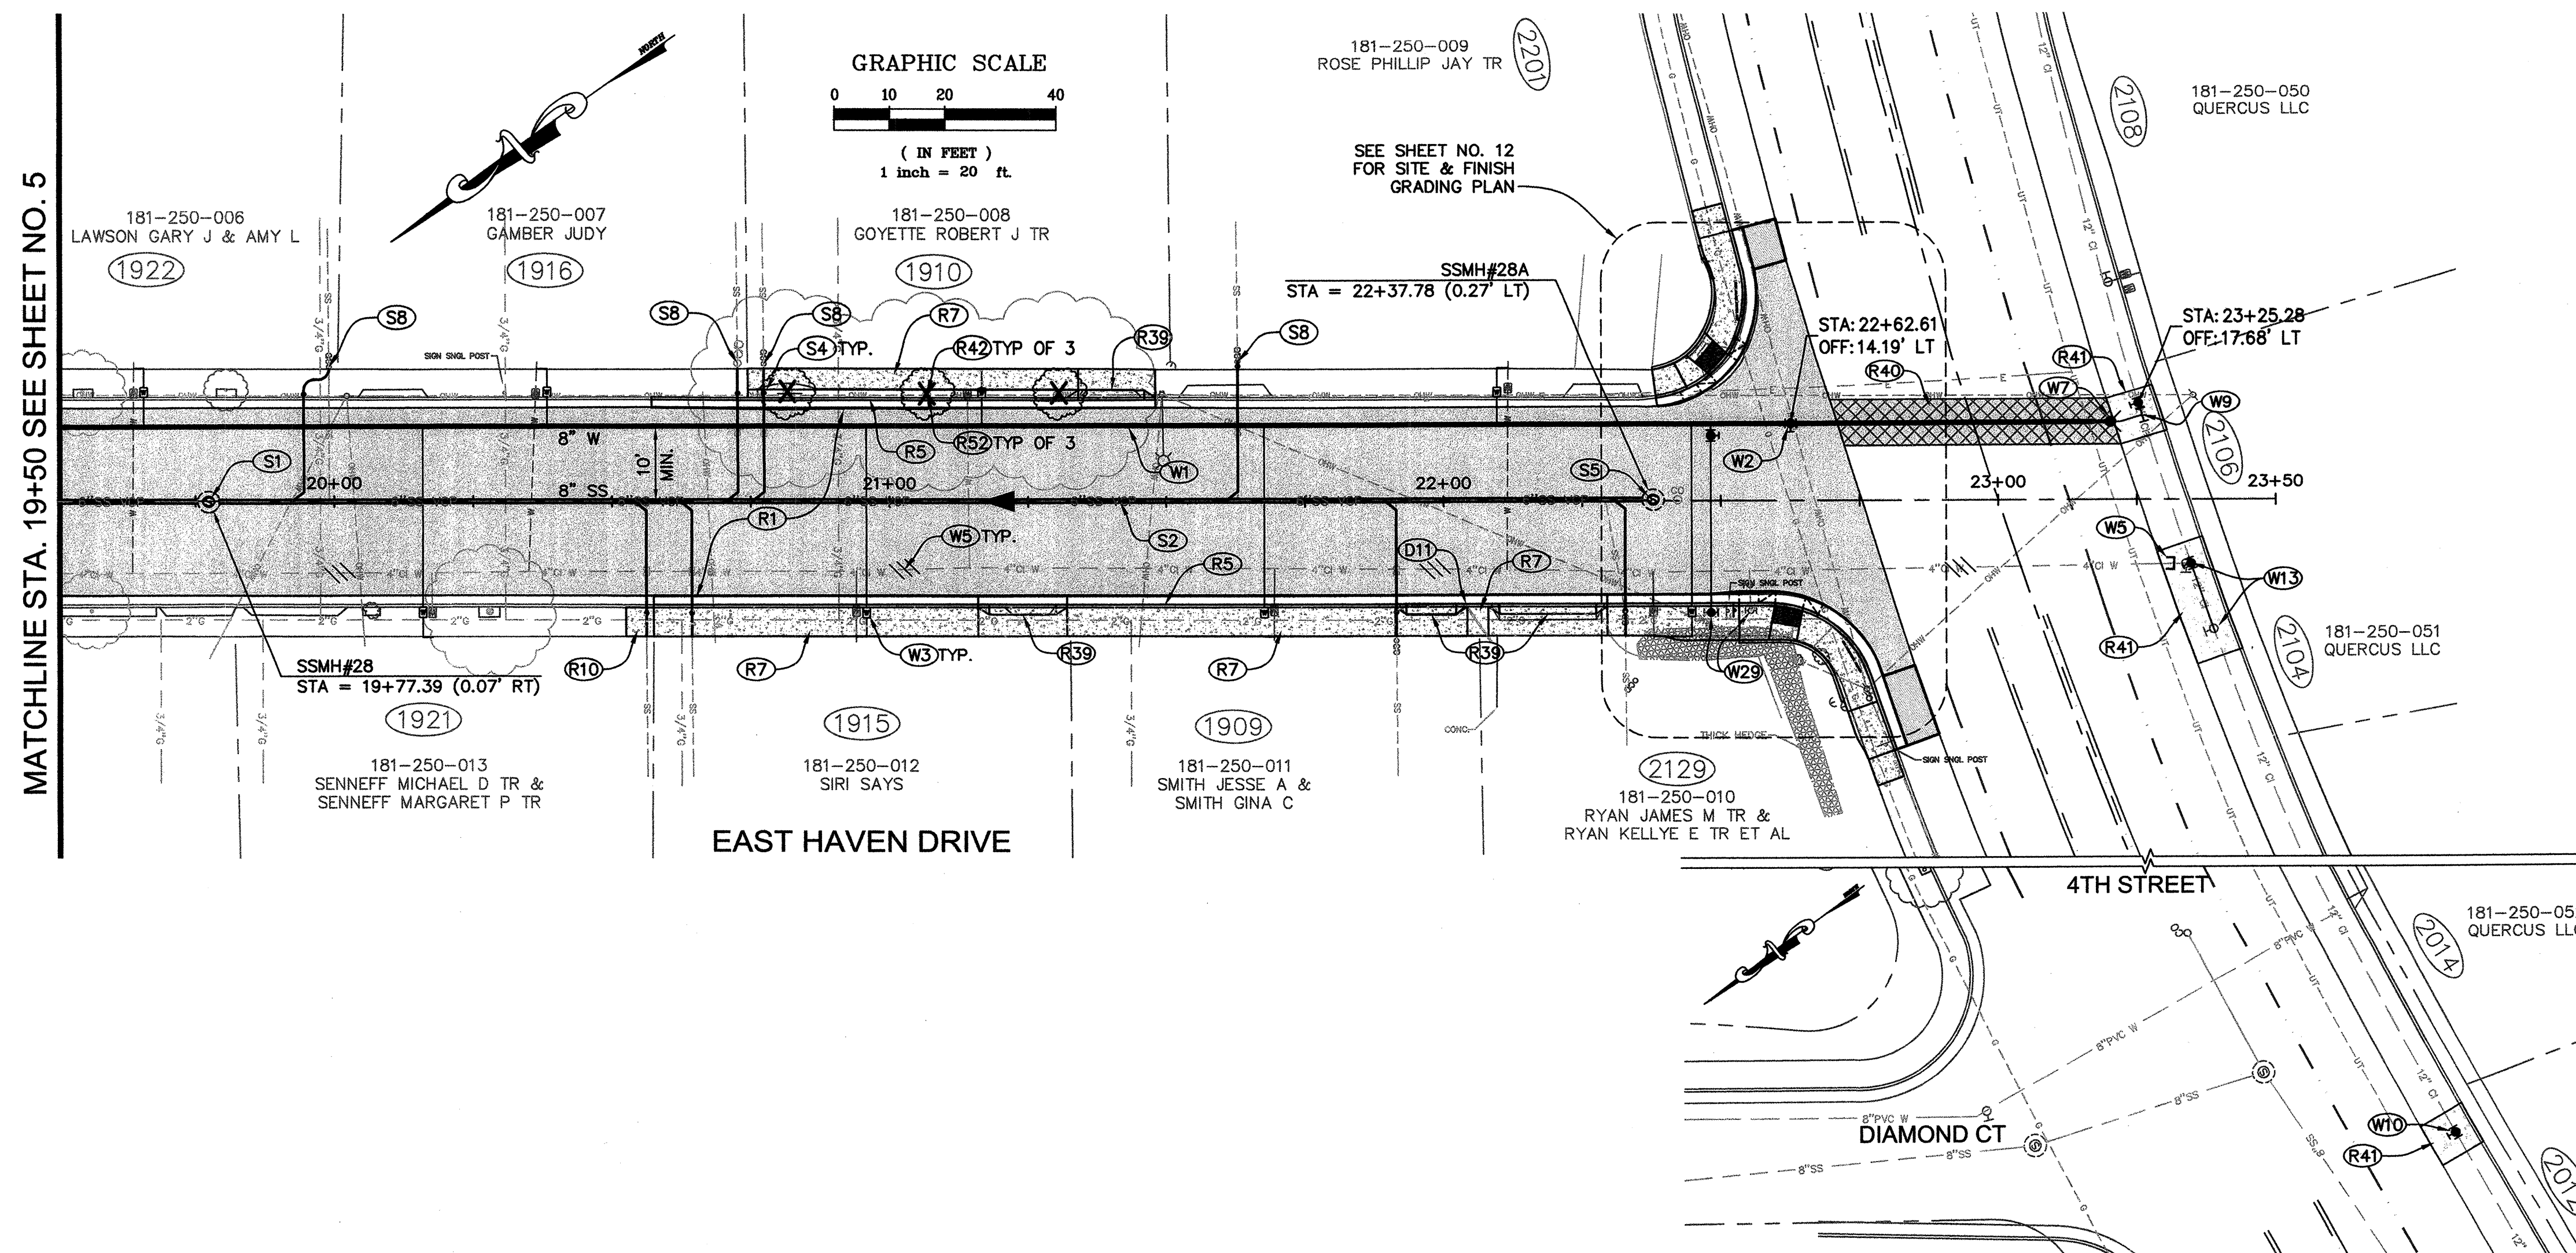

SHEET INDEX
NOT TO SCALE

CONSTRUCTION NOTES:

- (D11) INSTALL SIDEWALK DRAIN PER CITY STD. 406A.
- (R1) RECONSTRUCT PAVEMENT PER TYPICAL SECTION DETAIL $\frac{1}{25}$
- (R5) REMOVE & REPLACE EXISTING CURB AND GUTTER PER CITY STD 241.
- (R7) REMOVE & REPLACE SIDEWALK PER CITY STD 237.
- (R10) INSTALL 5' LONG (OR NEAREST SCORE MARK) SIDEWALK CROSS SLOPE TRANSITION.
- (R39) REMOVE & REPLACE DRIVEWAY PER CITY STD 250B.
- (R40) PLACE PERMANENT TRENCH PAVING PER DETAIL $\frac{6}{25}$
- (R41) REMOVE & REPLACE CONCRETE APRON & CURB PER DETAIL $\frac{4}{25}$
- (R42) REMOVE TREE & GRIND STUMP.
- (R52) PLANT STREET TREE.
- (S1) REMOVE EXISTING MANHOLE AND INSTALL 48" SANITARY SEWER MANHOLE PER CITY STD 500.
- (S2) REMOVE EXISTING SANITARY SEWER MAIN AND INSTALL 8" SANITARY SEWER MAIN.
- (S4) REMOVE EXISTING SANITARY SEWER LATERAL FROM SEWER MAIN TO BACK OF SIDEWALK AND INSTALL 4" SANITARY SEWER LATERAL PER CITY STD 513A.
- (S5) REMOVE EXISTING CLEANOUT AND INSTALL 48" SANITARY SEWER MANHOLE PER CITY STD 500.
- (W1) INSTALL WATER MAIN.
- (W2) INSTALL GATE VALVE PER CITY STD 877.
- (W3) INSTALL 1" WATER SERVICE PLUMBED FOR 5/8"x 3/4" METER PER CITY STD. 863A. CONNECT TO EXISTING WATER SERVICE.
- (W4) REMOVE EXISTING FIRE HYDRANT & APPURTENANCES & SALVAGE FIRE HYDRANT TO CITY. REMOVE & REPLACE PUBLIC FIRE HYDRANT PER CITY STD. 857.
- (W5) REMOVE OR ABANDON EXISTING WATER SYSTEM COMPONENTS (TYP) PER CITY WATER DISTRIBUTION STANDARD SPECIFICATIONS.
- (W7) INSTALL TEMPORARY BLOW OFF PER CITY STD 859 AND SPECIFICATIONS.
- (W9) INSTALL 12"x 8" AND GATE VALVE, CONNECT NEW 8" WATER MAIN TO EXISTING 12" WATER MAIN AS A SINGLE OPERATION UNDER CITY INSPECTION.
- (W10) INSTALL NEW 12" CUT-IN WATER VALVE PER CITY STD 877.
- (W13) REMOVE TEE, 4" & 12" WATER VALVES AND APPROXIMATELY 15' OF EXISTING WATER MAIN AS SHOWN. REPLACE WITH 12" GATE VALVE, 12" PVC WATER (PC235) WATER MAIN AND COUPLERS PER CITY SPECIFICATIONS.
- (W29) REMOVE EXISTING FIRE HYDRANT & APPURTENANCES & SALVAGE FIRE HYDRANT TO CITY. INSTALL COMMERCIAL FIRE HYDRANT PER CITY STD. 857, PROVIDE 4' CLEAR TO BACK OF SIDEWALK.

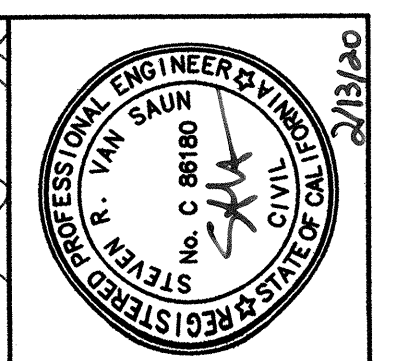

 **Coastland Civil Engineering, Inc.**
1400 Neotomas Avenue, Santa Rosa, CA 95405
707.571.8005 707.571.8037 Fax

[illegible]

SCALE: AS SHOWN	DATE: FEBRUARY 2020
DWN BY: WJK ---	CHK BY: SRV ---

APPROVED: Deputy Director – Engineering


By *Lori Urbanek* Date 2/25/2020

LORI URBANEK

CITY OF SANTA ROSA CAPITAL IMPROVEMENT PROJECT LA PALOMA AVE, EAST HAVEN DR & ROGERS WY SEWER AND WATER SYSTEM IMPROVEMENTS EAST HAVEN DR- PLAN & PROFILE STA. 19+50 TO STA. 23+50	CONTRACT NO. C00308	
	SHEET 6	OF 25
	FILE NO. 2019-0050	

Images: 2018_Merged_Aerial.tif Xrefs: CSR-ENGINEERS STAMPS-PLAN-2016.dwg;124014-TP.dwg;BMO7.DWG;124014-RAMPS.DWG
 Path: F:\Civil 3D Projects\124014 La Poloma\DWG\124014-SF.DWG Layout Name: SHT-6 Plot Date: Feb 11, 2020 at 11:39

Project: 2019-2020 LA Paloma Ave. Improvements
Sheet: 7 of 25
Date: 11/11/2020
Author: J. L. Smith
Checker: J. L. Smith
Title: Engineer

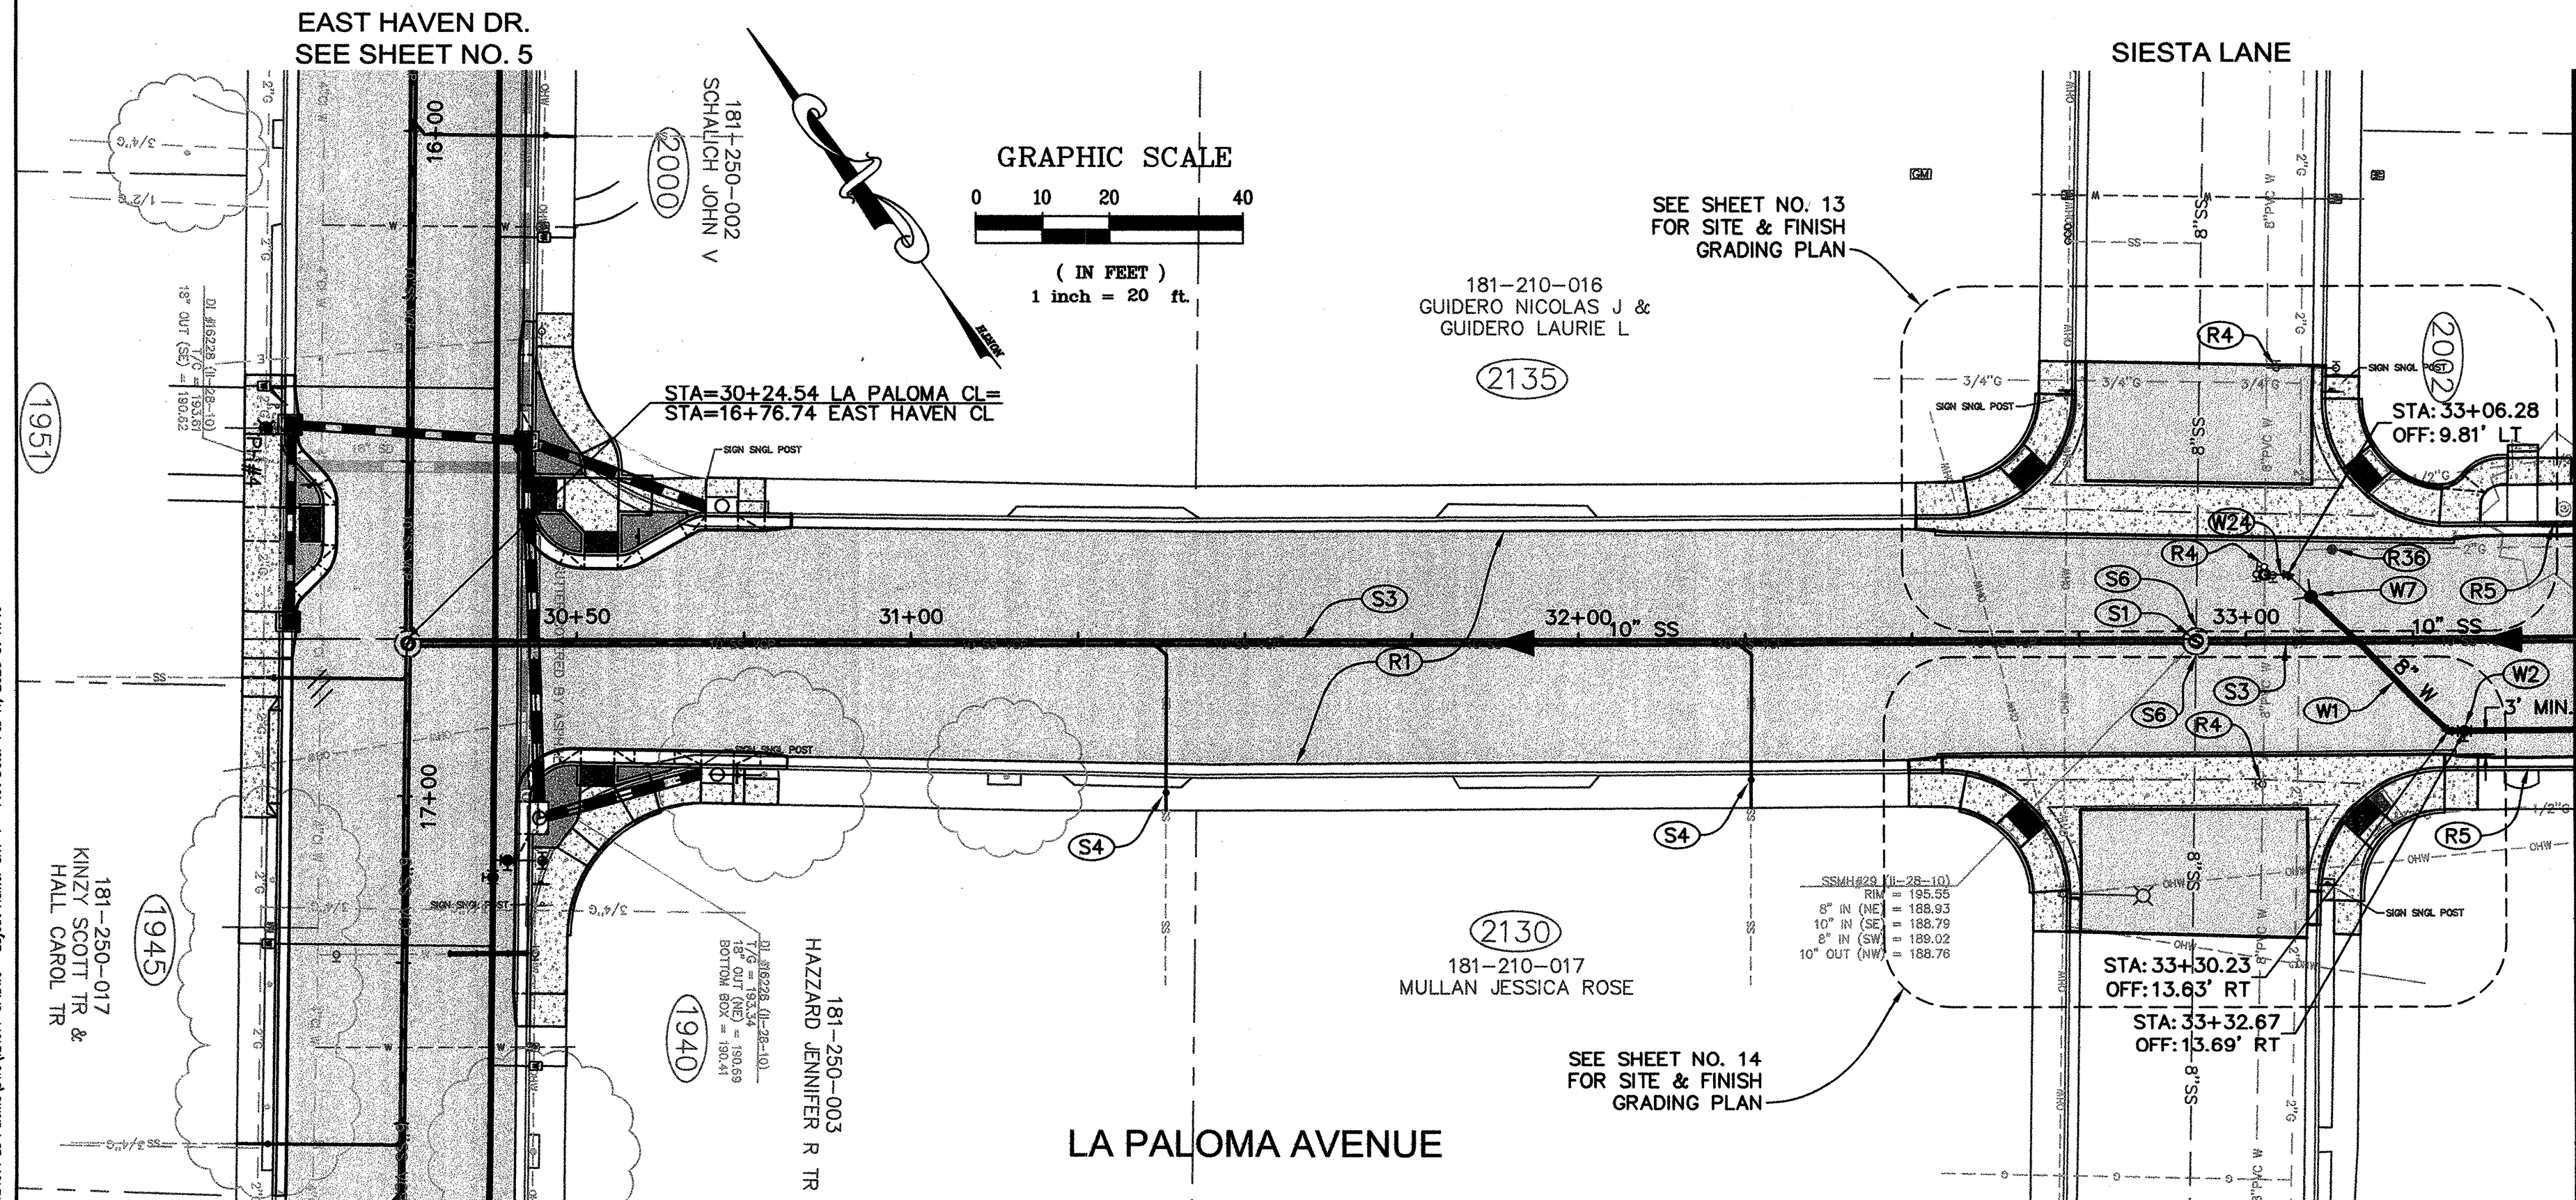

LA PALOMA CL PROFILE

PROFILE
HORIZ: 1" = 20' VERT: 1" = 4'

MATCHLINE STA. 33+50 SEE SHEET NO. 7

EXISTING GROUND AT CONTROL LINE

FINISH GROUND AT CONTROL LINE

0.74%

52' OF RESTRAINED JOINTS PER CITY STD 850

36" MIN

8" PVC W (PC 235)

(E) 10" VCP

269 LF - 10" PVC SS S=0.004

107' OF RESTRAINED JOINTS PER CITY STD 850

SSMH#30 RIM=198.10

STA = 36+19.19 (0.49' LT) LA PALOMA CL

STA = 41+42.16 (0.72' LT) ROGERS CL

10" INV IN = 198.00 (SW)

10" INV IN = 190.00 (NE)

10" INV OUT = 189.90 (NW)

GRADE BREAK STA = 36+02.19 ELEV = 197.81

GRADE BREAK STA = 36+09.86 ELEV = 198.06

(E) SSMH#30 (11'-28"-10) RIM: 198.10

10" INV IN (SW) = 190.84

10" INV IN (NE) = 190.90


10" INV OUT (NW) = 189.00

195.9 195.89 196.3 196.32 196.7 196.72 197.2 197.15 197.5 197.46 197.8 197.78 198.1 198.07

33+50 34+00 34+50 35+00 35+50 36+00 36+50



- (R1) RECONSTRUCT PAVEMENT PER TYPICAL SECTION DETAIL — (1/25)
- (R5) REMOVE & REPLACE EXISTING CURB AND GUTTER PER CITY STD 241
- (R6) REMOVE & REPLACE DRIVEWAY APRON PER CITY STD 250B.
- (S3) REMOVE EXISTING SANITARY SEWER MAIN AND INSTALL 10" SANITARY SEWER MAIN.
- (S4) REMOVE EXISTING SANITARY SEWER LATERAL FROM SEWER MAIN TO BACK OF SIDEWALK AND INSTALL 4" SANITARY SEWER LATERAL PER CITY STD 513A.
- (W1) INSTALL WATER MAIN.
- (W2) INSTALL GATE VALVE PER CITY STD 877.
- (W3) INSTALL 1" WATER SERVICE PLUMBED FOR 5/8"x 3/4" METER PER CITY STD. 863A. CONNECT TO EXISTING WATER SERVICE.
- (W5) REMOVE OR ABANDON EXISTING WATER MAIN PER CITY WATER DISTRIBUTION STANDARD SPECIFICATIONS.
- (W7) INSTALL TEMPORARY BLOW OFF PER CITY STD 859 AND SPECIFICATIONS.

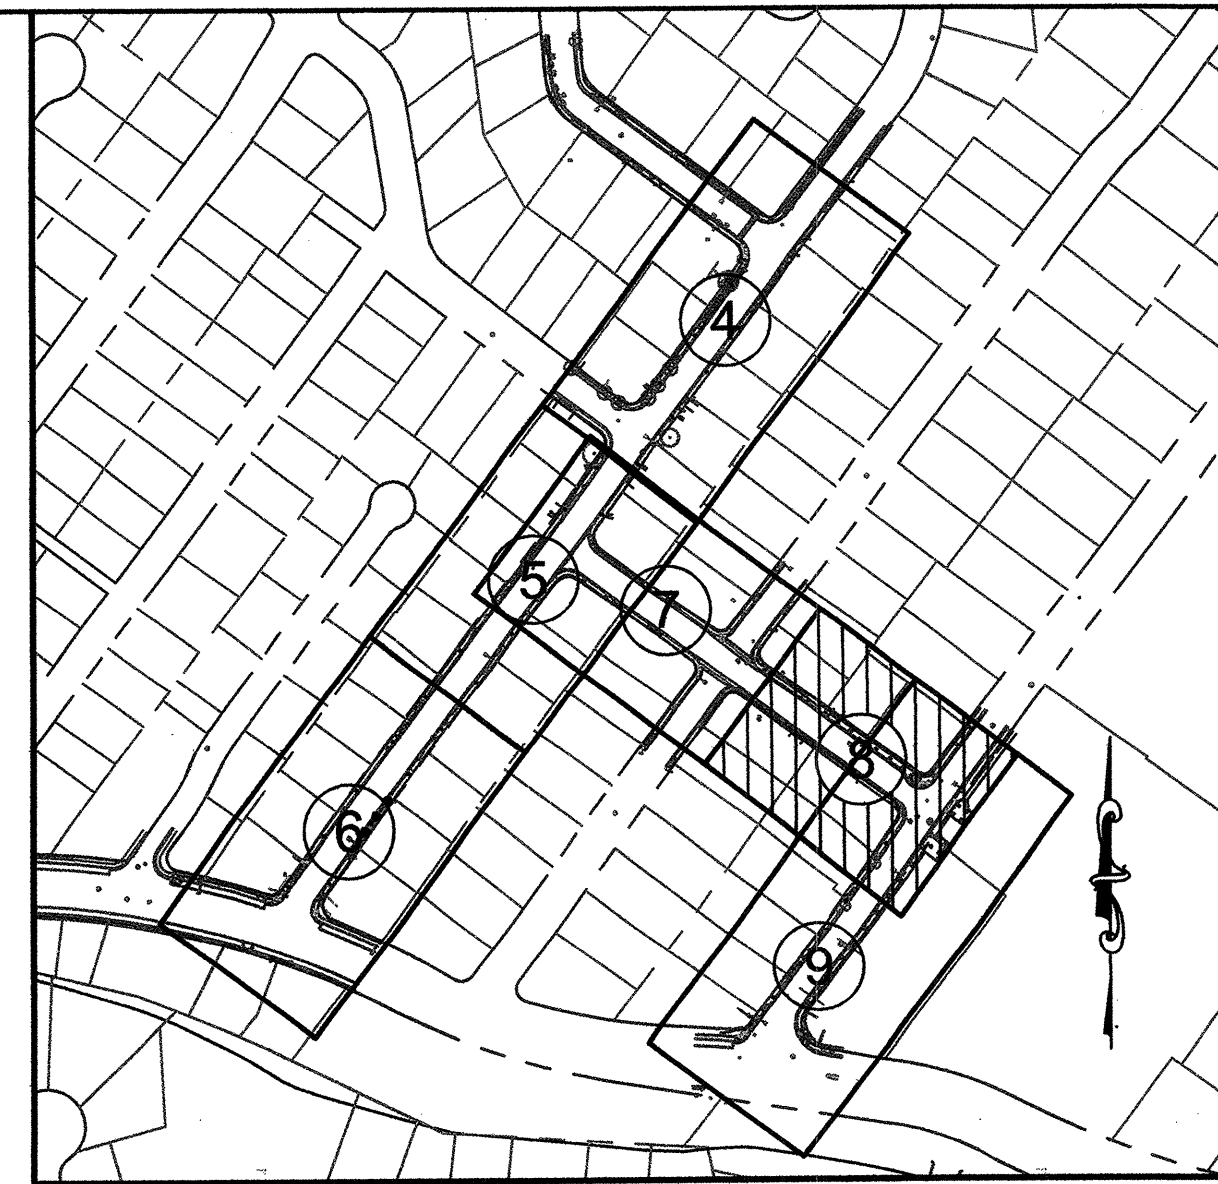

SHEET INDEX
NOT TO SCALE



Coastland Civil Engineering, Inc.

Seotomas Avenue, Santa Rosa, CA 95405
707.571.8037 Fax

SCALE: AS SHOWN	DATE: FEBRUARY 2020	NO.	DATE	REVISION	BY
DWN BY: WJK	CHK BY: SRV				
APPROVED: Deputy Director -- Engineering					
By  Date 2/25/2020 LOCAL LIBRARIAN					



CITY OF SANTA ROSA
CAPITAL IMPROVEMENT PROJECT
LA PALOMA AVE, EAST HAVEN DR & ROGERS WY
SEWER AND WATER SYSTEM IMPROVEMENTS

CONTRACT NO.
C00308

SHEET 8 OF 25

FILE No.2019-0050

ROGERS WAY CL PROFILE

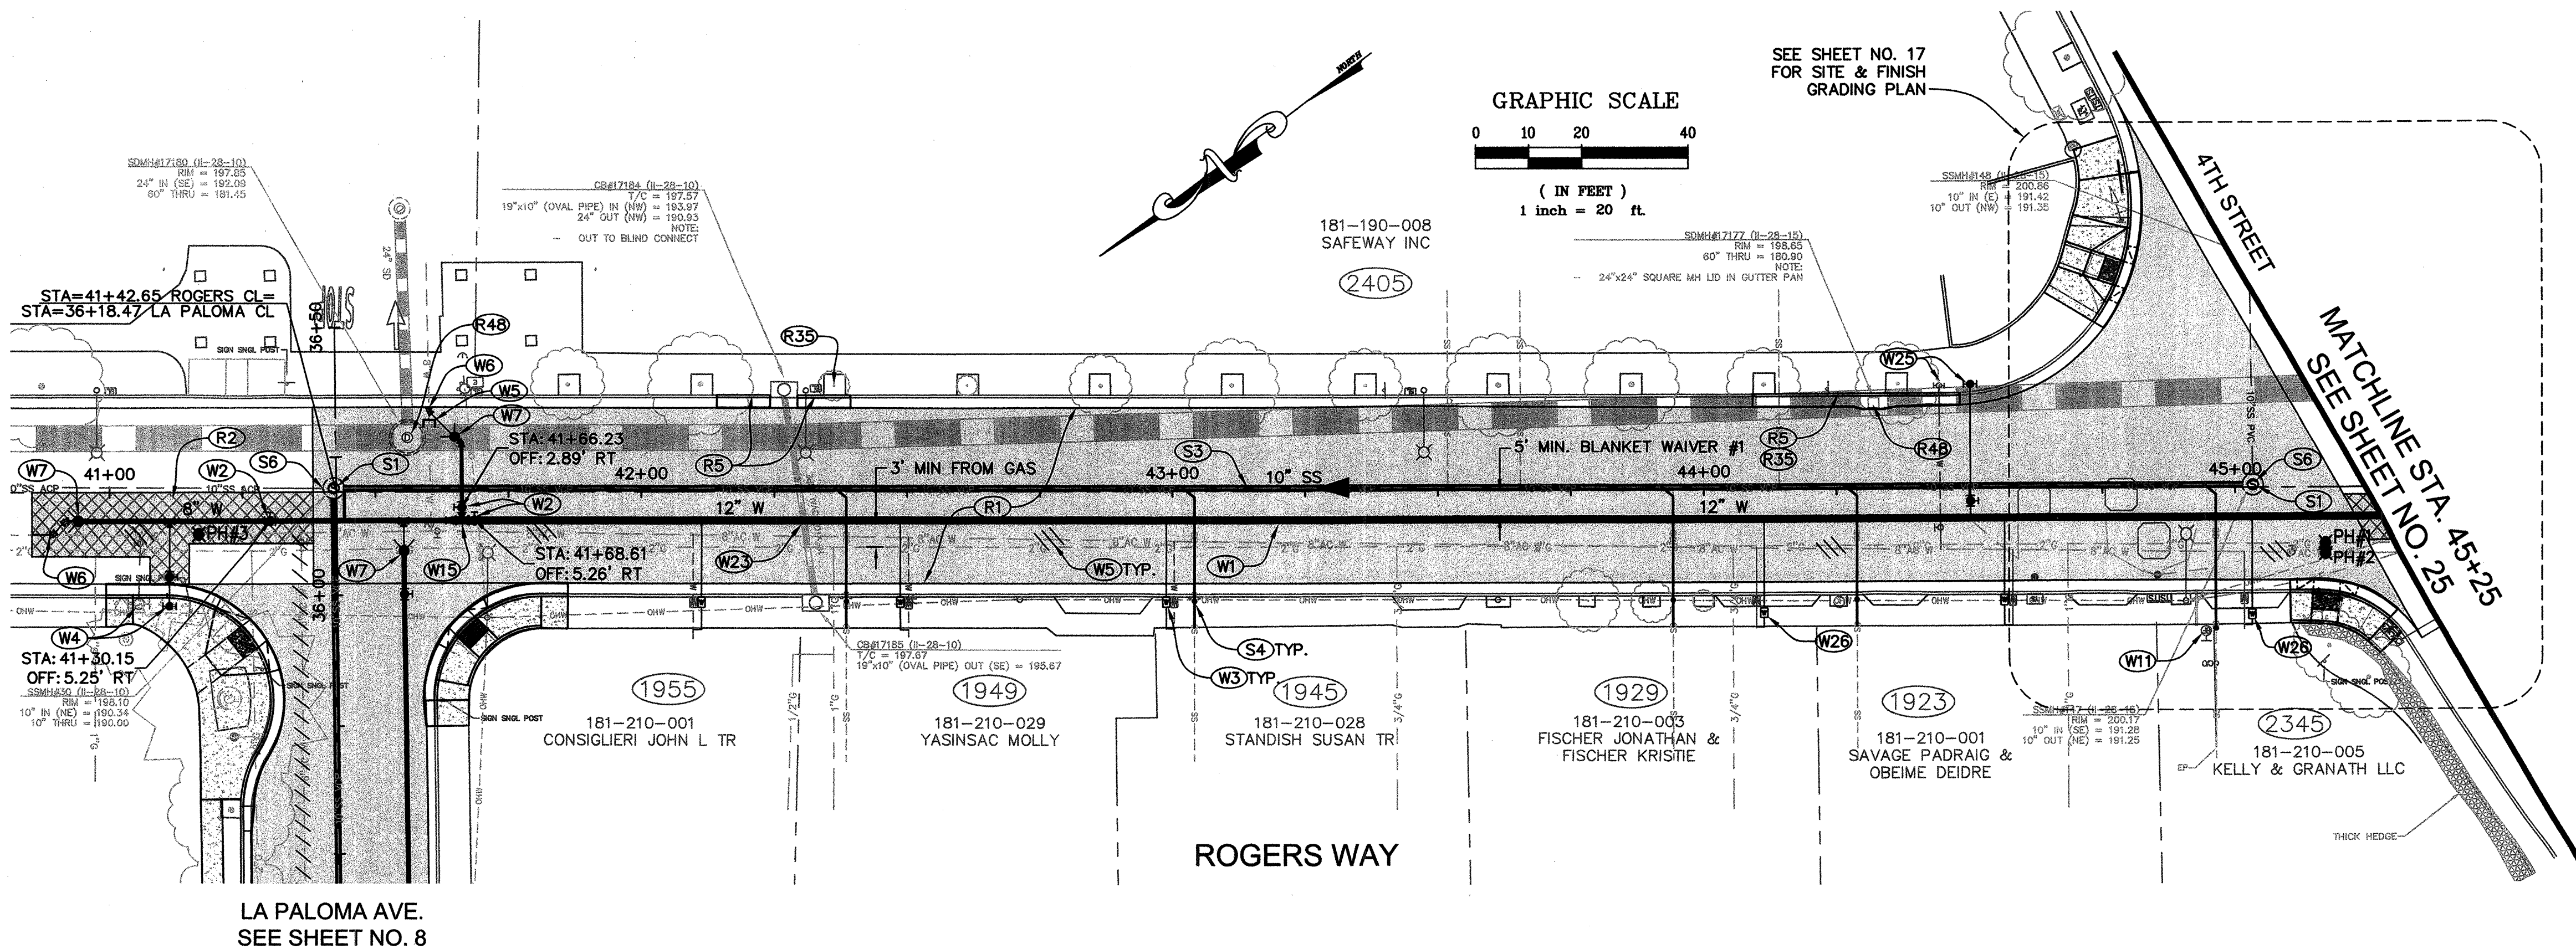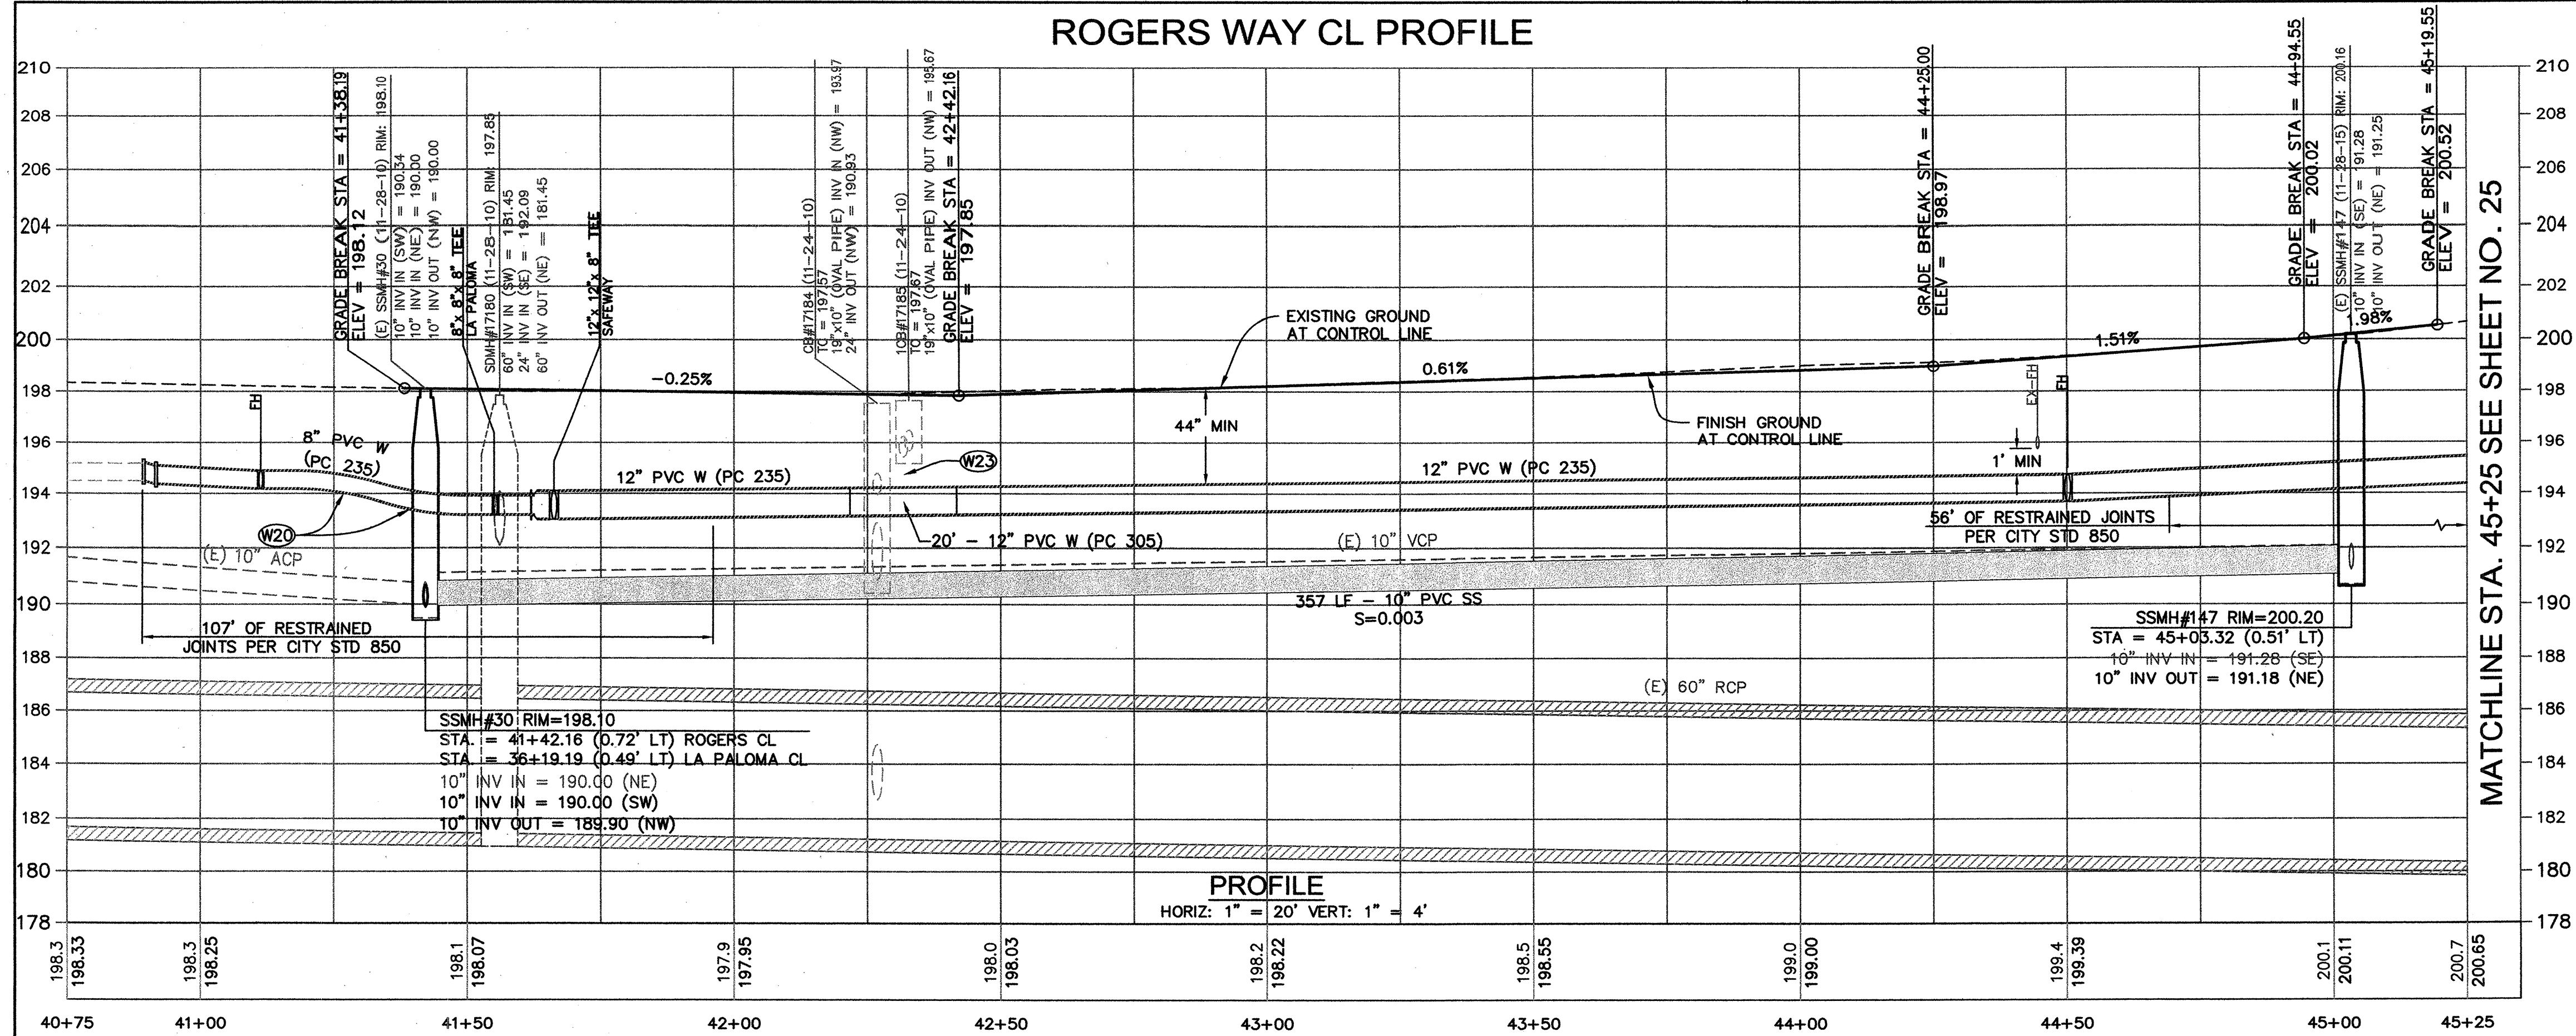

LA PALOMA AVE.
SEE SHEET NO. 8

SHEET INDEX

- CONSTRUCTION NOTES:


1

25

 - (R1) RECONSTRUCT PAVEMENT PER TYPICAL SECTION DETAIL
 - (R2) PLACE PERMANENT TRENCH PAVING PER CITY STD 215.
 - (R5) REMOVE EXISTING CURB AND GUTTER AS REQUIRED TO ACCOMMODATE IMPROVEDMENTS.
 - (R35) PRUNE ROOTS AND INSTALL ROOT BARRIER.
 - (R48) ADJUST STORM DRAIN MANHOLE FRAME & COVER TO FINISH GRADE.
 - (S1) REMOVE EXISTING MANHOLE AND INSTALL 48" SANITARY SEWER MANHOLE PER CITY STD 500.
 - (S3) REMOVE EXISTING SANITARY SEWER MAIN AND INSTALL 10" PVC SANITARY SEWER MAIN PER CITY STANDARDS.
 - (S4) REMOVE OR ABANDON EXISTING SANITARY SEWER LATERAL FROM SEWER MAIN TO BACK OF SIDEWALK AND INSTALL 4" SANITARY SEWER LATERAL PER CITY STD 513A.
 - (S6) CONNECT EXISTING MAIN TO NEW SSMH PER CITY STANDARDS.
 - (W1) INSTALL WATER MAIN.
 - (W2) INSTALL GATE VALVE.
 - (W3) INSTALL 1" WATER SERVICE PLUMBED FOR 5/8"x 3/4" METER PER CITY STD. 863A. CONNECT TO EXISTING WATER SERVICE.
 - (W4) REMOVE EXISTING FIRE HYDRANT & APPURTENANCES & SALVAGE FIRE HYDRANT TO CITY. REMOVE & REPLACE PUBLIC FIRE HYDRANT PER CITY STD. 857.
 - (W5) REMOVE OR ABANDON EXISTING WATER SYSTEM COMPONENTS (TYP) PER CITY WATER DISTRIBUTION STANDARD SPECIFICATIONS.
 - (W6) TIE-IN TO EXISTING WATER MAIN. INSTALL FITTINGS AS REQUIRED UNDER CITY INSPECTION.
 - (W7) INSTALL TEMPORARY BLOW OFF PER CITY STD. 859 AND PER SPECIFICATIONS.
 - (W11) RE-CERTIFY BACKFLOW DEVICE AFTER NEW WATER METER INSTALLED.
 - (W15) INSTALL 12"x 12"x 8" TEE WITH 8"x 12" REDUCER AND GATE VALVES.
 - (W20) ROPE PIPE PER CITY STDS AS NEEDED. INSTALLATION SHALL NOT EXCEED MANUFACTURER'S RECOMMENDED MAXIMUM DEFLECTION.
 - (W23) WATER MAIN UNDER STORM DRAIN PER CITY BLANKET WAIVER 4.
 - (W25) REMOVE & RELOCATE PUBLIC FIRE HYDRANT PER CITY STD. 857.
 - (W26) INSTALL 1" WATER SERVICE PLUMBED FOR 5/8"x 3/4" METER PER CITY STD. 863A WITH TRAFFIC RATED BOX & LID. CONNECT TO EXISTING WATER SERVICE.

POT HOLE DATA

POT HOLE #1 = 2" GAS STEEL PIPE 3.92' DEEP
POT HOLE #2 = 8" WATER CAST IRON PIPE 5.75' DEEP
POT HOLE #3 = 8" AC WATER PIPE 3.42' DEEP

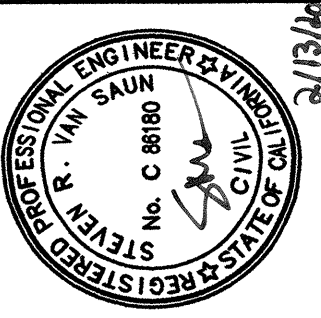



Coastland Civil Engineering, Inc.
 14400 Neotomas Avenue, Santa Rosa, CA 95405
 707.571.8005 Fax 707.571.8037

SCALE: AS SHOWN	DATE: FEBRUARY 2021	NO.	DATE	REVISION	BY
DWN BY: WJK	CHK BY: SRV				
APPROVED: Deputy Director -- Engineering					
By:  Date: 2/25/2021					
LORI URBANEK					

CITY OF SANTA ROSA
CAPITAL IMPROVEMENT PROJECT
LA PALOMA AVE, EAST HAVEN DR & ROGERS WY
SEWER AND WATER SYSTEM IMPROVEMENTS
ROGERS WAY - PLAN & PROFILE
STA.40+75 TO STA. 45+25

CONTRACT NO.
C00308

SHEET 9 OF 25
FILE NO.2019-005

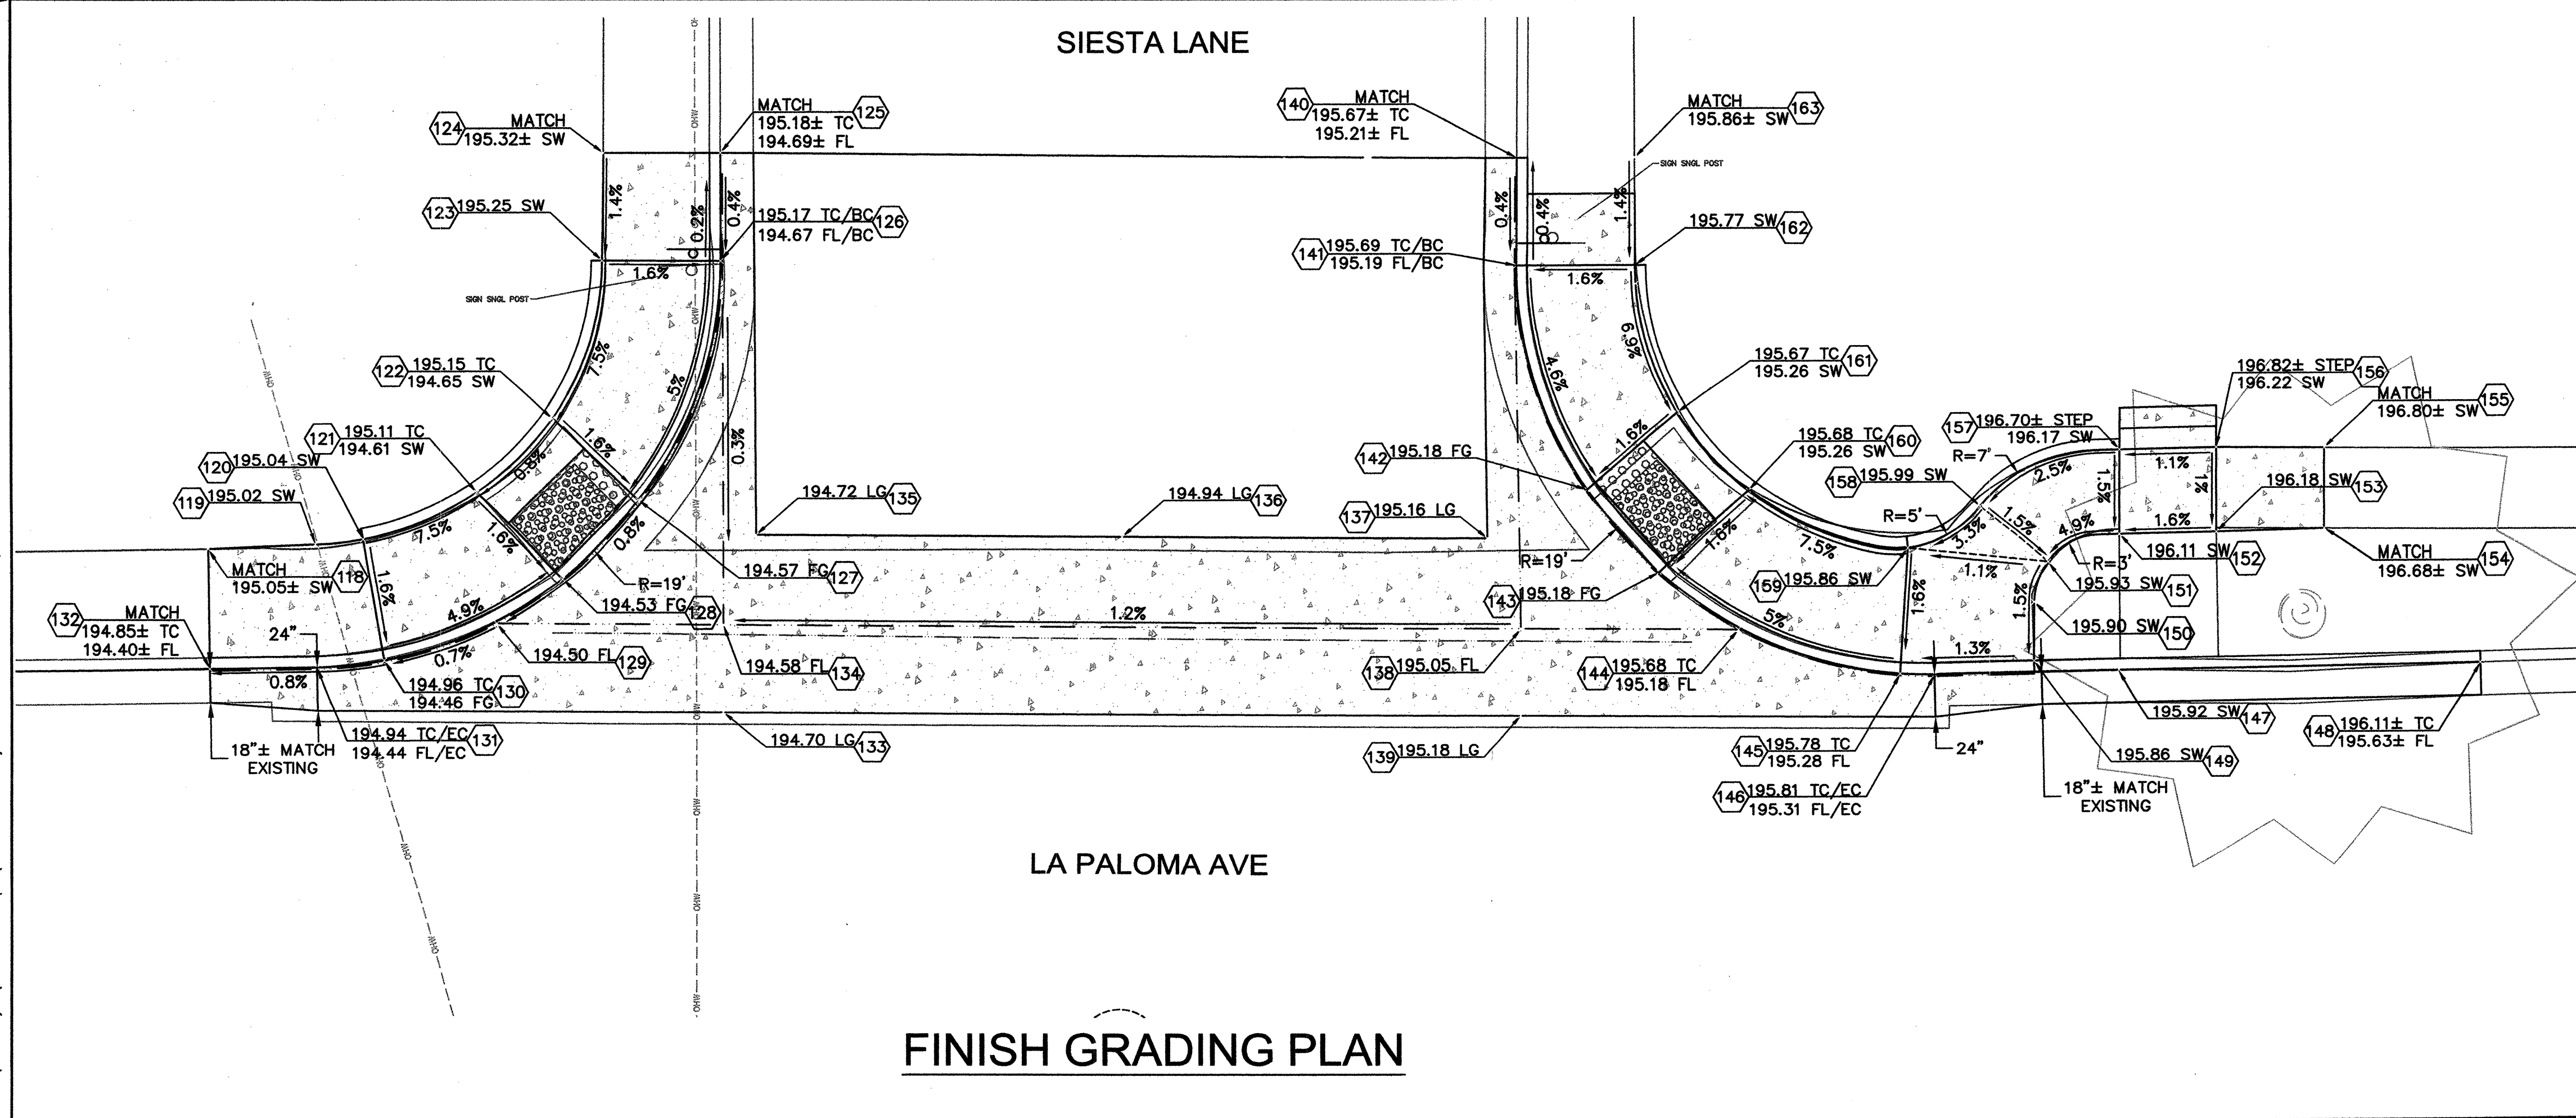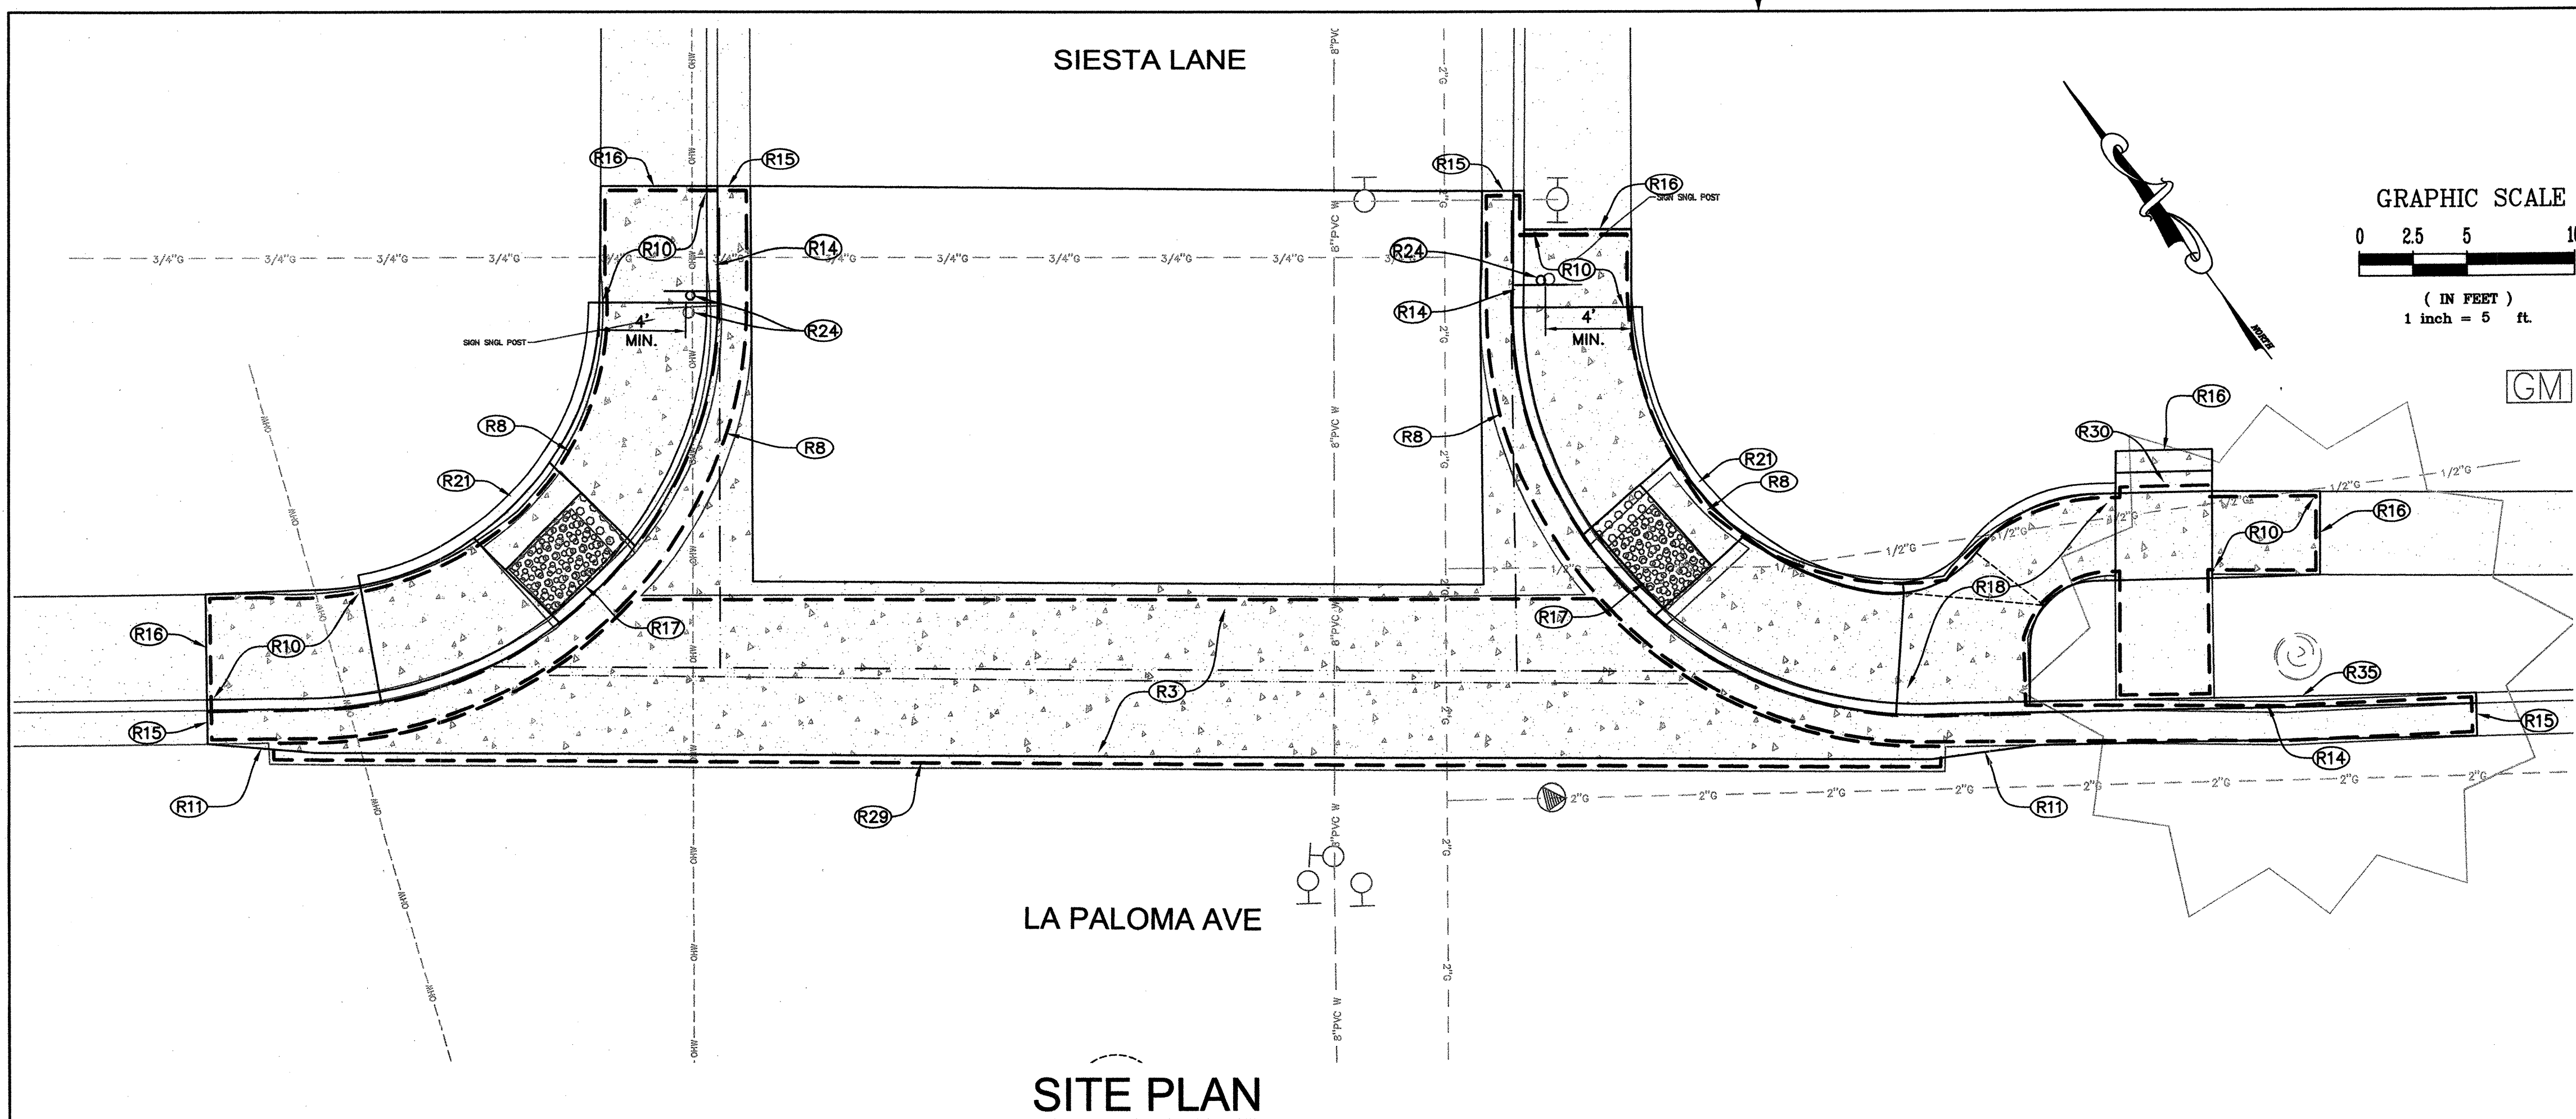

CONSTRUCTION NOTES:


- (R3) CONSTRUCT VALLEY GUTTER PER CITY STD. 243.
- (R8) REMOVE EXISTING CURB, GUTTER AND SIDEWALK.
- (R10) INSTALL 5' LONG (OR NEAREST SCORE MARK)
SIDEWALK CROSS SLOPE TRANSITION.
- (R11) INSTALL 5' LONG GUTTER WIDTH TRANSITION.
- (R14) CONSTRUCT CURB AND GUTTER PER CITY STD 241.
- (R15) CONFORM TO EXISTING CURB AND GUTTER.
- (R16) CONFORM TO EXISTING CONCRETE.
- (R17) INSTALL MODIFIED TYPE C CURB RAMP PER CALTRANS
STD PLAN RSP A88A AND PER FINISH GRADING PLAN.
- (R18) CONSTRUCT CONCRETE SIDEWALK PER CITY STD 237.
- (R21) CONSTRUCT VERTICAL CURB AT

3
25

 SIDEWALK PER DETAIL
- (R24) RELOCATE EXISTING STREET SIGN WHERE SHOWN PER CITY STD. 701.
- (R29) REMOVE EXISTING CONCRETE VALLEY GUTTER.
- (R30) CONSTRUCT CONCRETE STEP PER GRADING PLAN.
- (R35) PRUNE ROOTS AND INSTALL ROOT BARRIER.

PEDESTRIAN RAMP COORDINATE TABLE		
POINT #	NORTHING	EASTING
118	1927098.01	6363267.75
119	1927095.18	6363271.84
120	1927094.02	6363273.73
121	1927092.59	6363279.26
122	1927093.32	6363284.19
123	1927097.97	6363290.59
124	1927101.93	6363293.65
125	1927098.67	6363298.00
126	1927094.67	6363294.99
127	1927087.81	6363285.01
128	1927087.08	6363280.07
129	1927087.30	6363276.44
130	1927089.11	6363271.26
131	1927090.74	6363286.60
132	1927093.67	6363264.58
133	1927077.77	6363282.38
134	1927080.95	6363284.80
135	1927083.23	6363288.41
136	1927072.98	6363301.92
137	1927062.72	6363315.43
138	1927058.59	6363314.26
139	1927055.40	6363311.85
140	1927076.28	6363327.41


PEDESTRIAN RAMP COORDINATE TABLE		
POINT #	NORTHING	EASTING
(41)	1927072.30	6363324.37
(42)	1927061.76	6363320.5
(43)	1927056.77	6363320.91
(44)	1927052.49	6363322.30
(45)	1927046.39	6363327.08
(46)	1927045.40	6363328.33
(47)	1927040.39	6363335.28
(48)	1927030.55	6363348.82
(49)	1927043.09	6363332.38
(50)	1927045.18	6363333.96
(51)	1927046.26	6363335.59
(52)	1927045.20	6363338.93
(53)	1927042.58	6363342.58
(54)	1927039.69	6363346.67
(55)	1927042.74	6363348.99
(56)	1927045.78	6363345.00
(57)	1927048.39	6363341.36
(58)	1927050.13	6363334.57
(59)	1927050.66	6363330.75
(60)	1927057.22	6363326.46
(61)	1927062.21	6363326.06
(62)	1927068.26	6363328.25
(63)	1927073.01	6363331.78

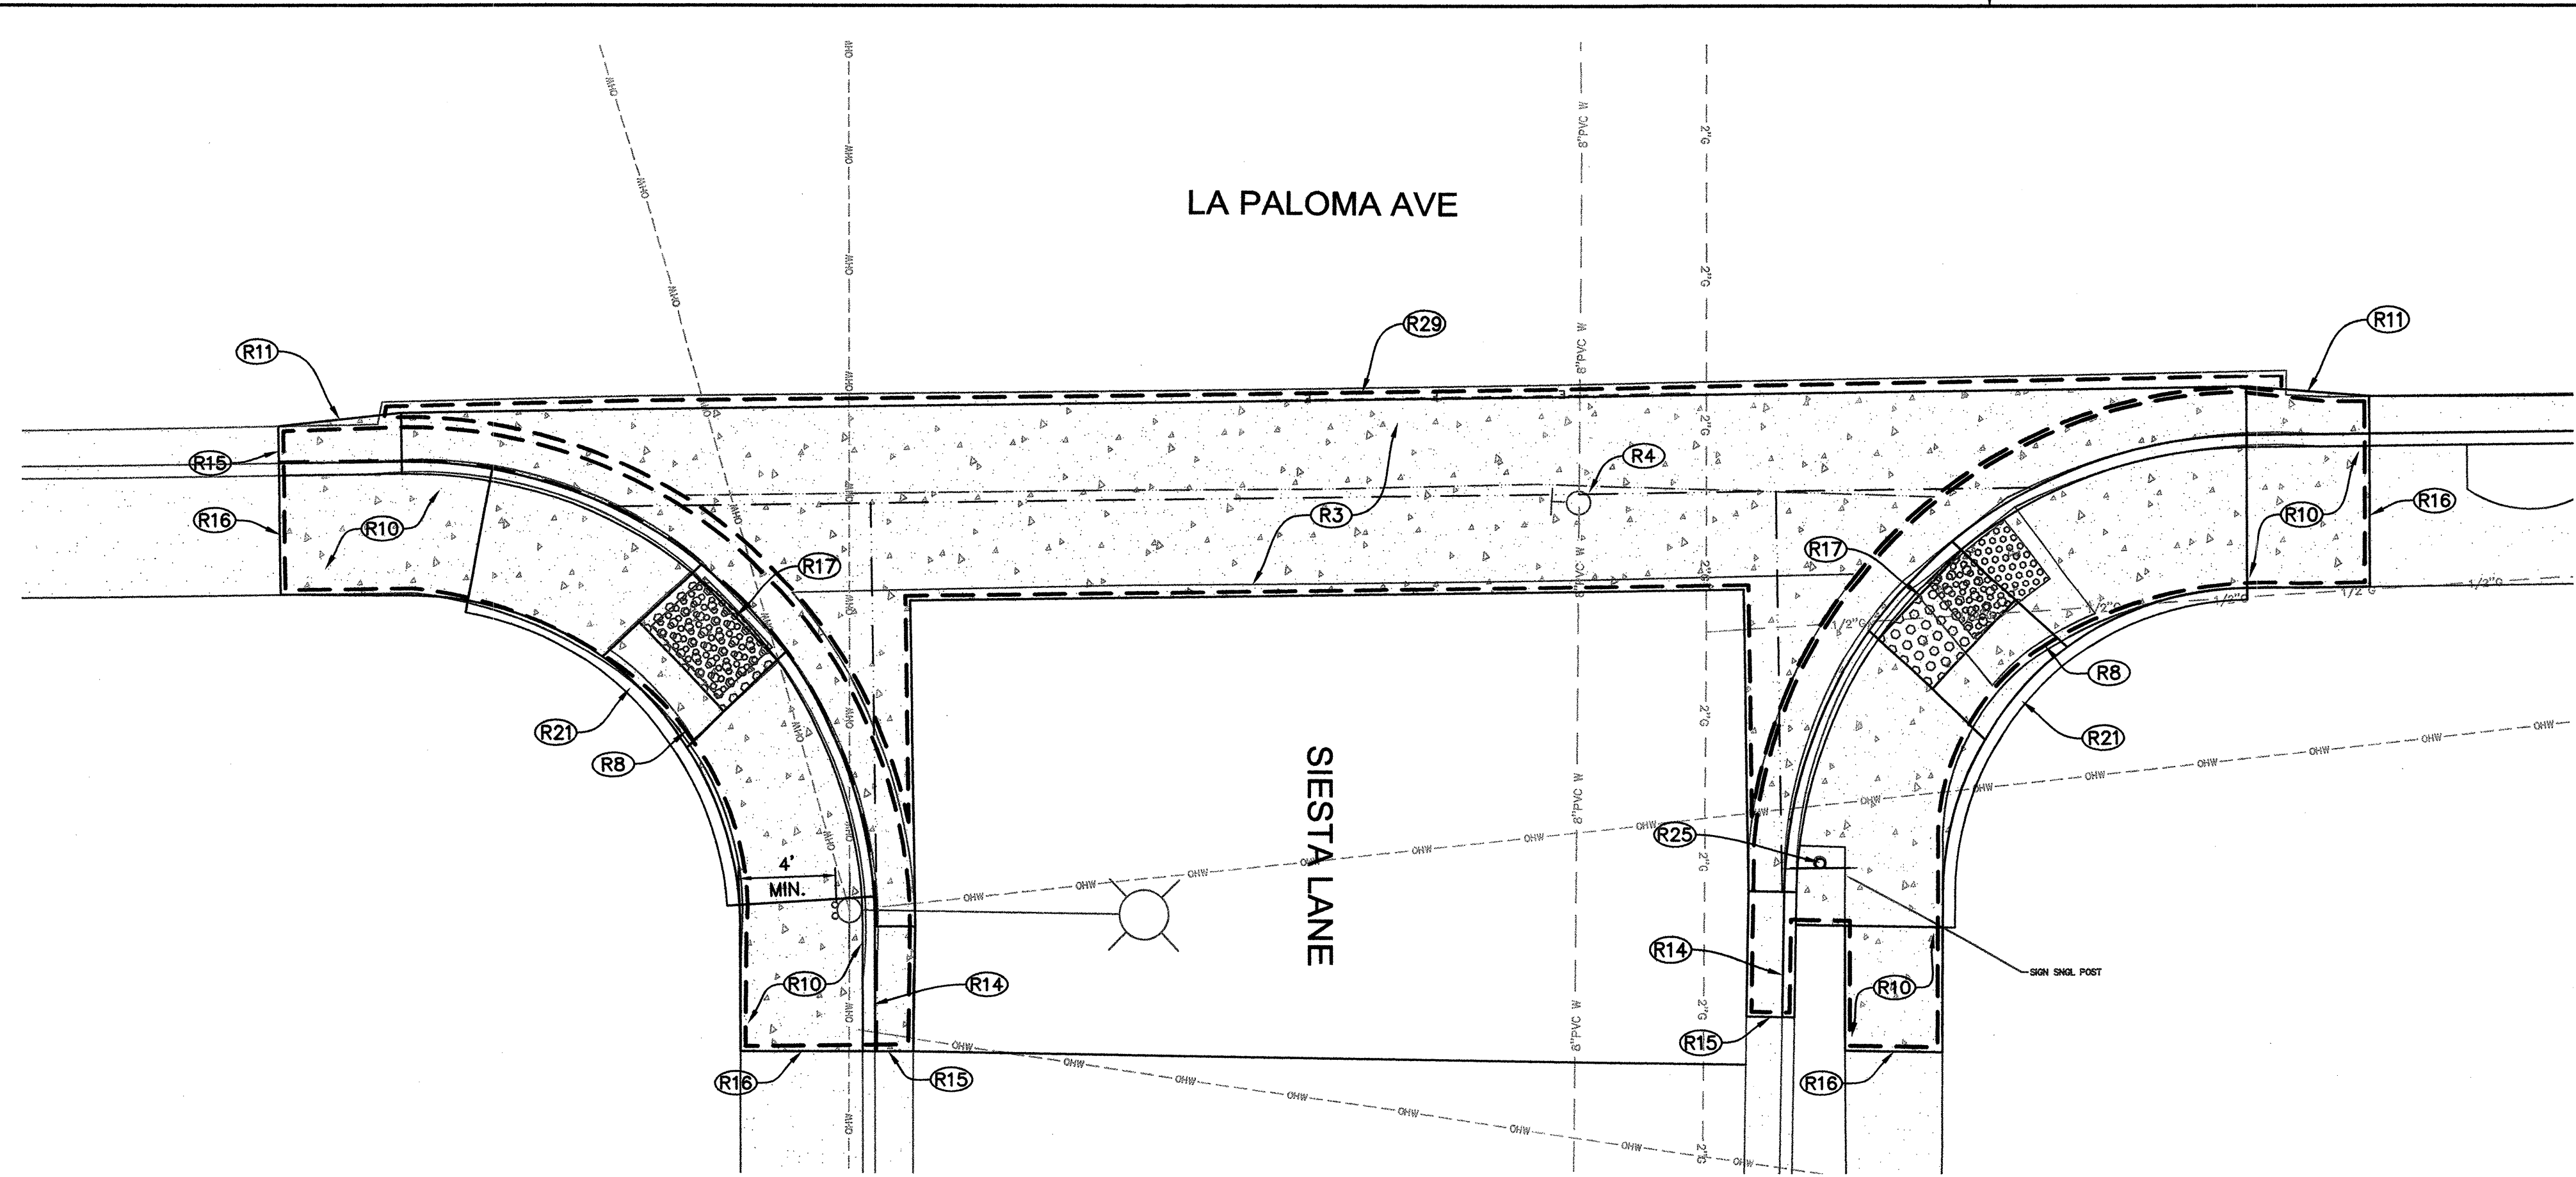

SITE PLAN

CONSTRUCTION NOTES:

- (R3) CONSTRUCT VALLEY GUTTER PER CITY STD. 243.
- (R4) ADJUST WATER VALVE FRAME & COVER TO FINISH GRADE.
- (R8) REMOVE EXISTING CURB, GUTTER AND SIDEWALK.
- (R10) INSTALL 5' LONG (OR NEAREST SCORE MARK) SIDEWALK CROSS SLOPE TRANSITION.
- (R11) INSTALL 5' LONG GUTTER WIDTH TRANSITION.
- (R14) CONSTRUCT CURB AND GUTTER PER CITY STD 241.
- (R15) CONFORM TO EXISTING CURB AND GUTTER.
- (R16) CONFORM TO EXISTING CONCRETE.
- (R17) INSTALL MODIFIED TYPE C CURB RAMP PER CALTRANS STD PLAN RSP A88A AND PER FINISH GRADING PLAN.
- (R21) CONSTRUCT VERTICAL CURB AT SIDEWALK PER DETAIL (3/25)
- (R25) RESET EXISTING STREET SIGN PER CITY STD. 701.
- (R29) REMOVE EXISTING CONCRETE VALLEY GUTTER.

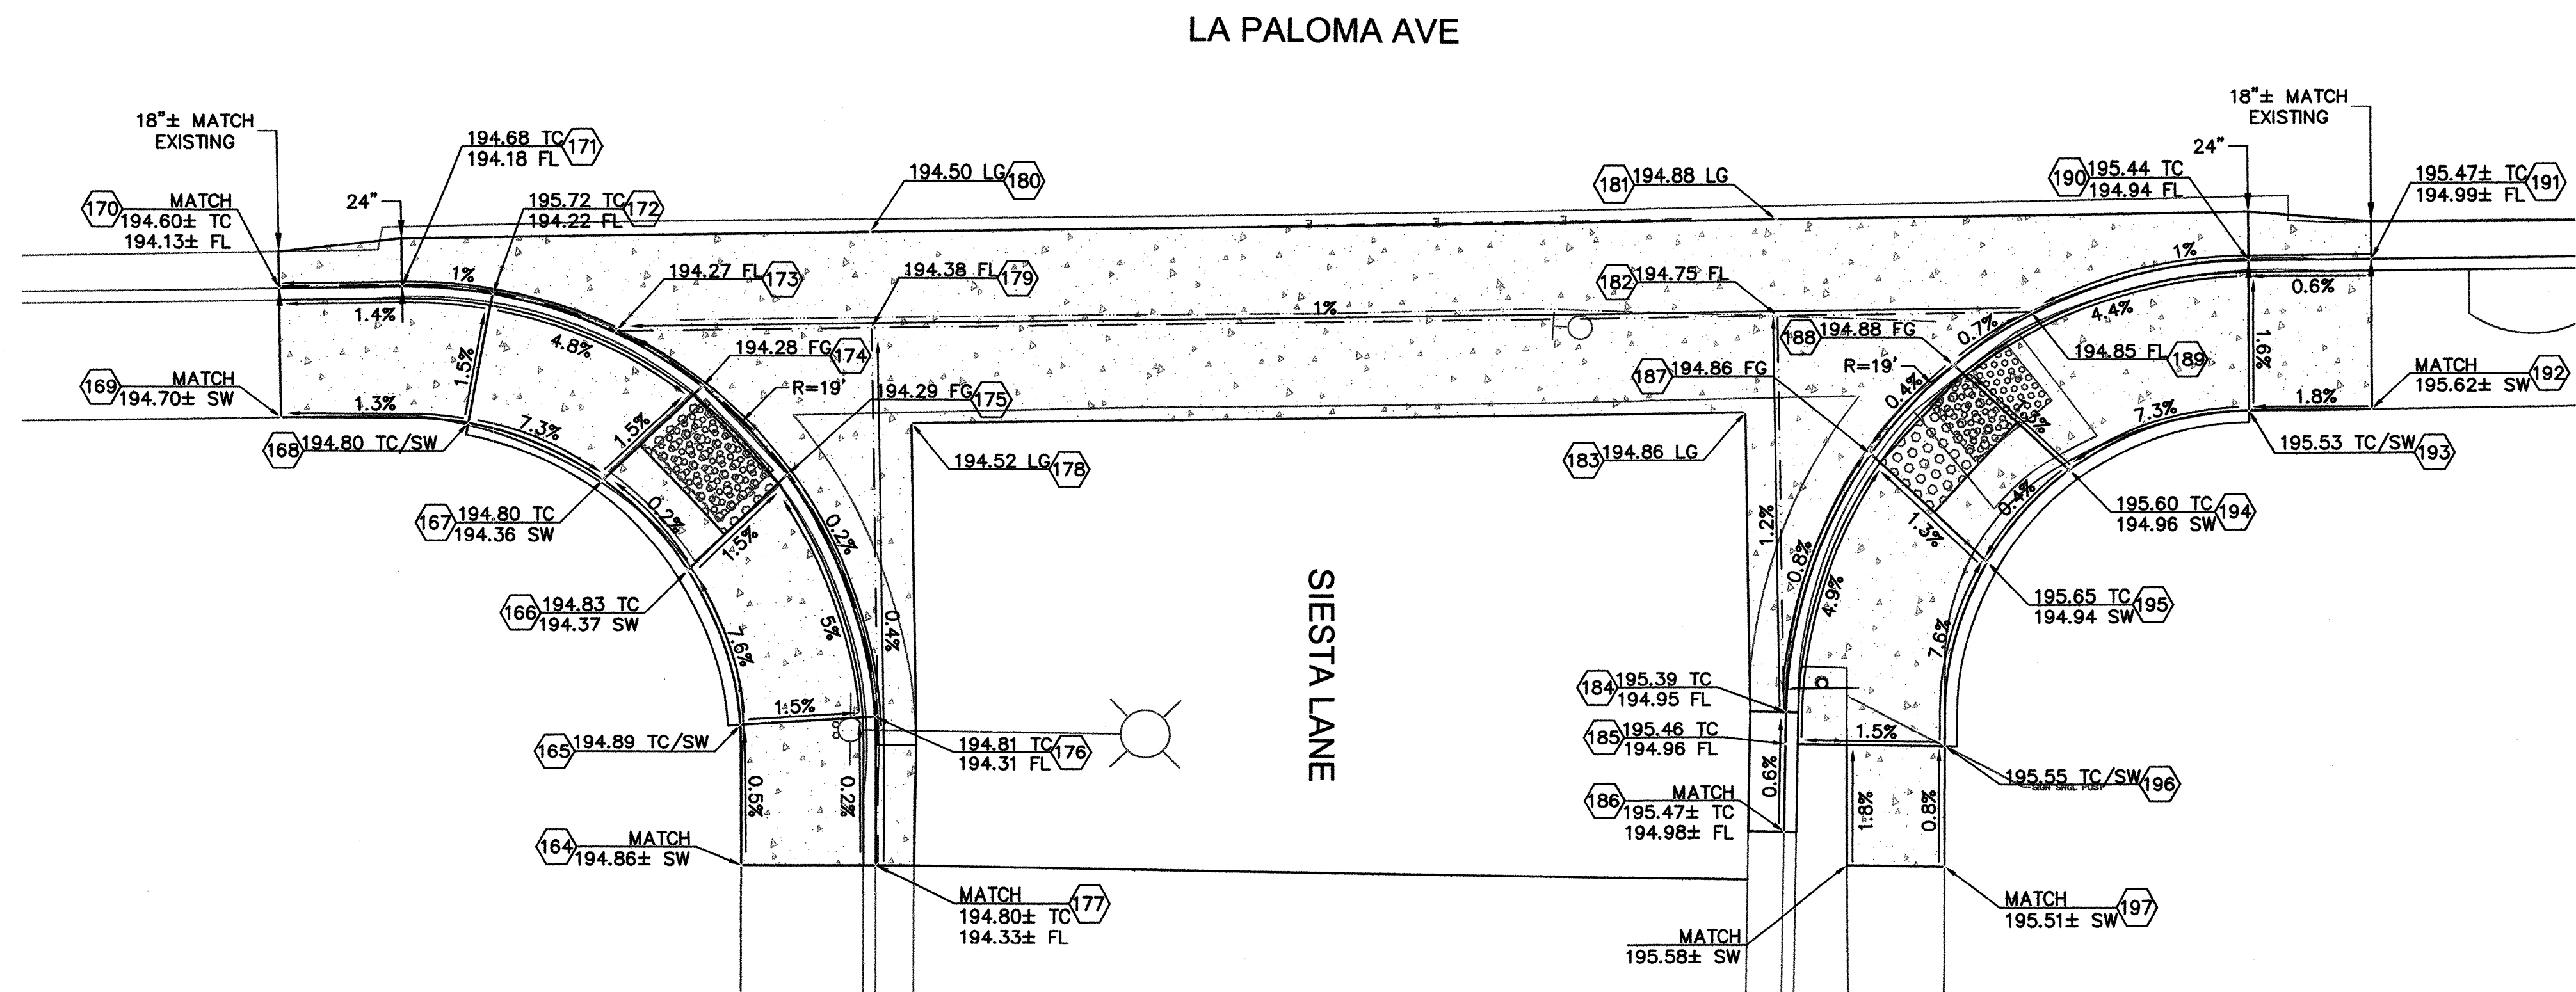

FINISH GRADING PLAN

PEDESTRIAN RAMP COORDINATE TABLE		
POINT #	NORTHING	EASTING
164	1927033.61	6363242.14
165	1927038.32	6363245.62
166	1927044.77	6363247.79
167	1927049.73	6363247.21
168	1927054.88	6363244.23
169	1927059.65	6363238.27
170	1927064.02	6363241.45
171	1927061.08	6363245.50
172	1927058.62	6363248.27
173	1927054.35	6363251.34
174	1927050.38	6363252.74
175	1927045.41	6363253.32
176	1927035.30	6363250.22
177	1927030.32	6363246.53
178	1927044.07	6363258.66
179	1927048.22	6363259.76
180	1927051.46	6363262.11

PEDESTRIAN RAMP COORDINATE TABLE		
POINT #	NORTHING	EASTING
181	1927029.73	6363291.96
182	1927026.49	6363289.60
183	1927024.07	6363286.14
184	1927013.21	6363280.04
185	1927012.16	6363279.22
186	1927009.25	6363276.95
187	1927019.63	6363289.19
188	1927020.53	6363294.11
189	1927020.41	6363297.96
190	1927016.83	6363306.34
191	1927013.86	6363310.36
192	1927008.83	6363306.61
193	1927011.80	6363302.58
194	1927014.25	6363295.26
195	1927013.29	6363290.35
196	1927008.18	6363284.34
197	1927004.20	6363281.33

PROFESSIONAL ENGINEER & SURVEYOR
STATE OF CALIFORNIA
No. C 86180
Civil
2/13/2020

Coastland Civil Engineering, Inc.
1400 Neotomas Avenue, Santa Rosa, CA 95405
707.571.8005

BY

REVISION

DATE

NO.

SCALE: AS SHOWN

DATE: ---

CHK BY: SRV

DWN BY: WUK

CITY OF SANTA ROSA
CAPITAL IMPROVEMENT PROJECT
LA PALOMA AVE. EAST HAVEN DR & ROGERS WY
SEWER AND WATER SYSTEM IMPROVEMENTS

**CURB RAMP DETAILS
LA PALOMA AT SIESTA (S)**

CONTRACT NO.
C00308



SHEET 14 OF 25

FILE NO.2019-0050

APPROVED: Deputy Director - Engineering
By: *Lori Urbanek* Date: 2/13/2020

BY: LORI URBANEK

Project: 2019_Marcel_Arducci_La_Paloma_Sewer_System_Improvements_Series_Plan_2019-05-13.dwg
User: F:\Data_20 Projects\2019 La Paloma Sewer System Improvements\2019-05-13.dwg
Date: Feb 11, 2020 at 11:56

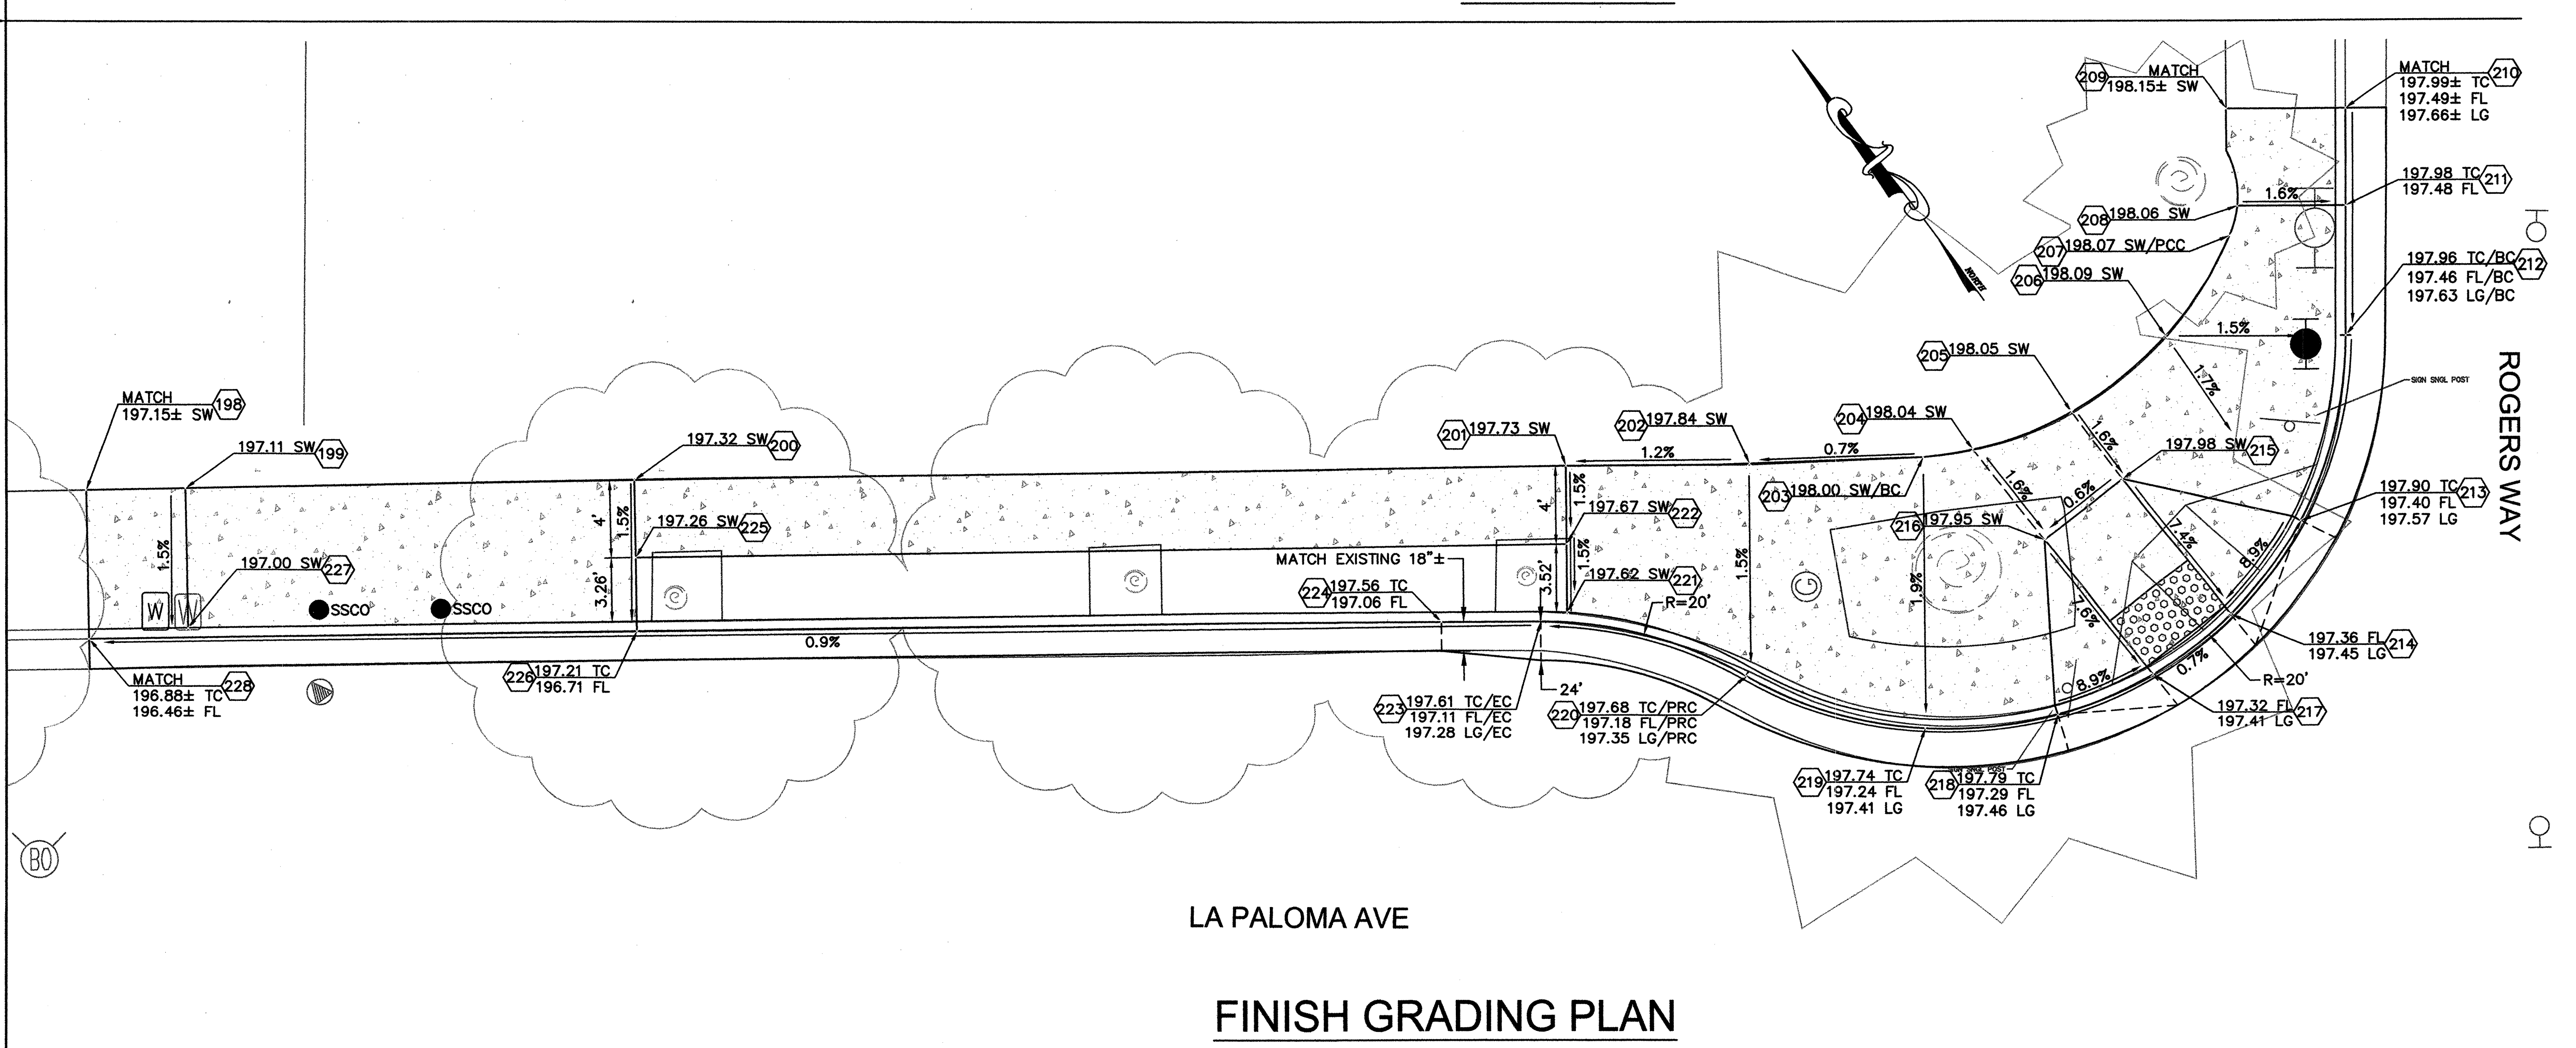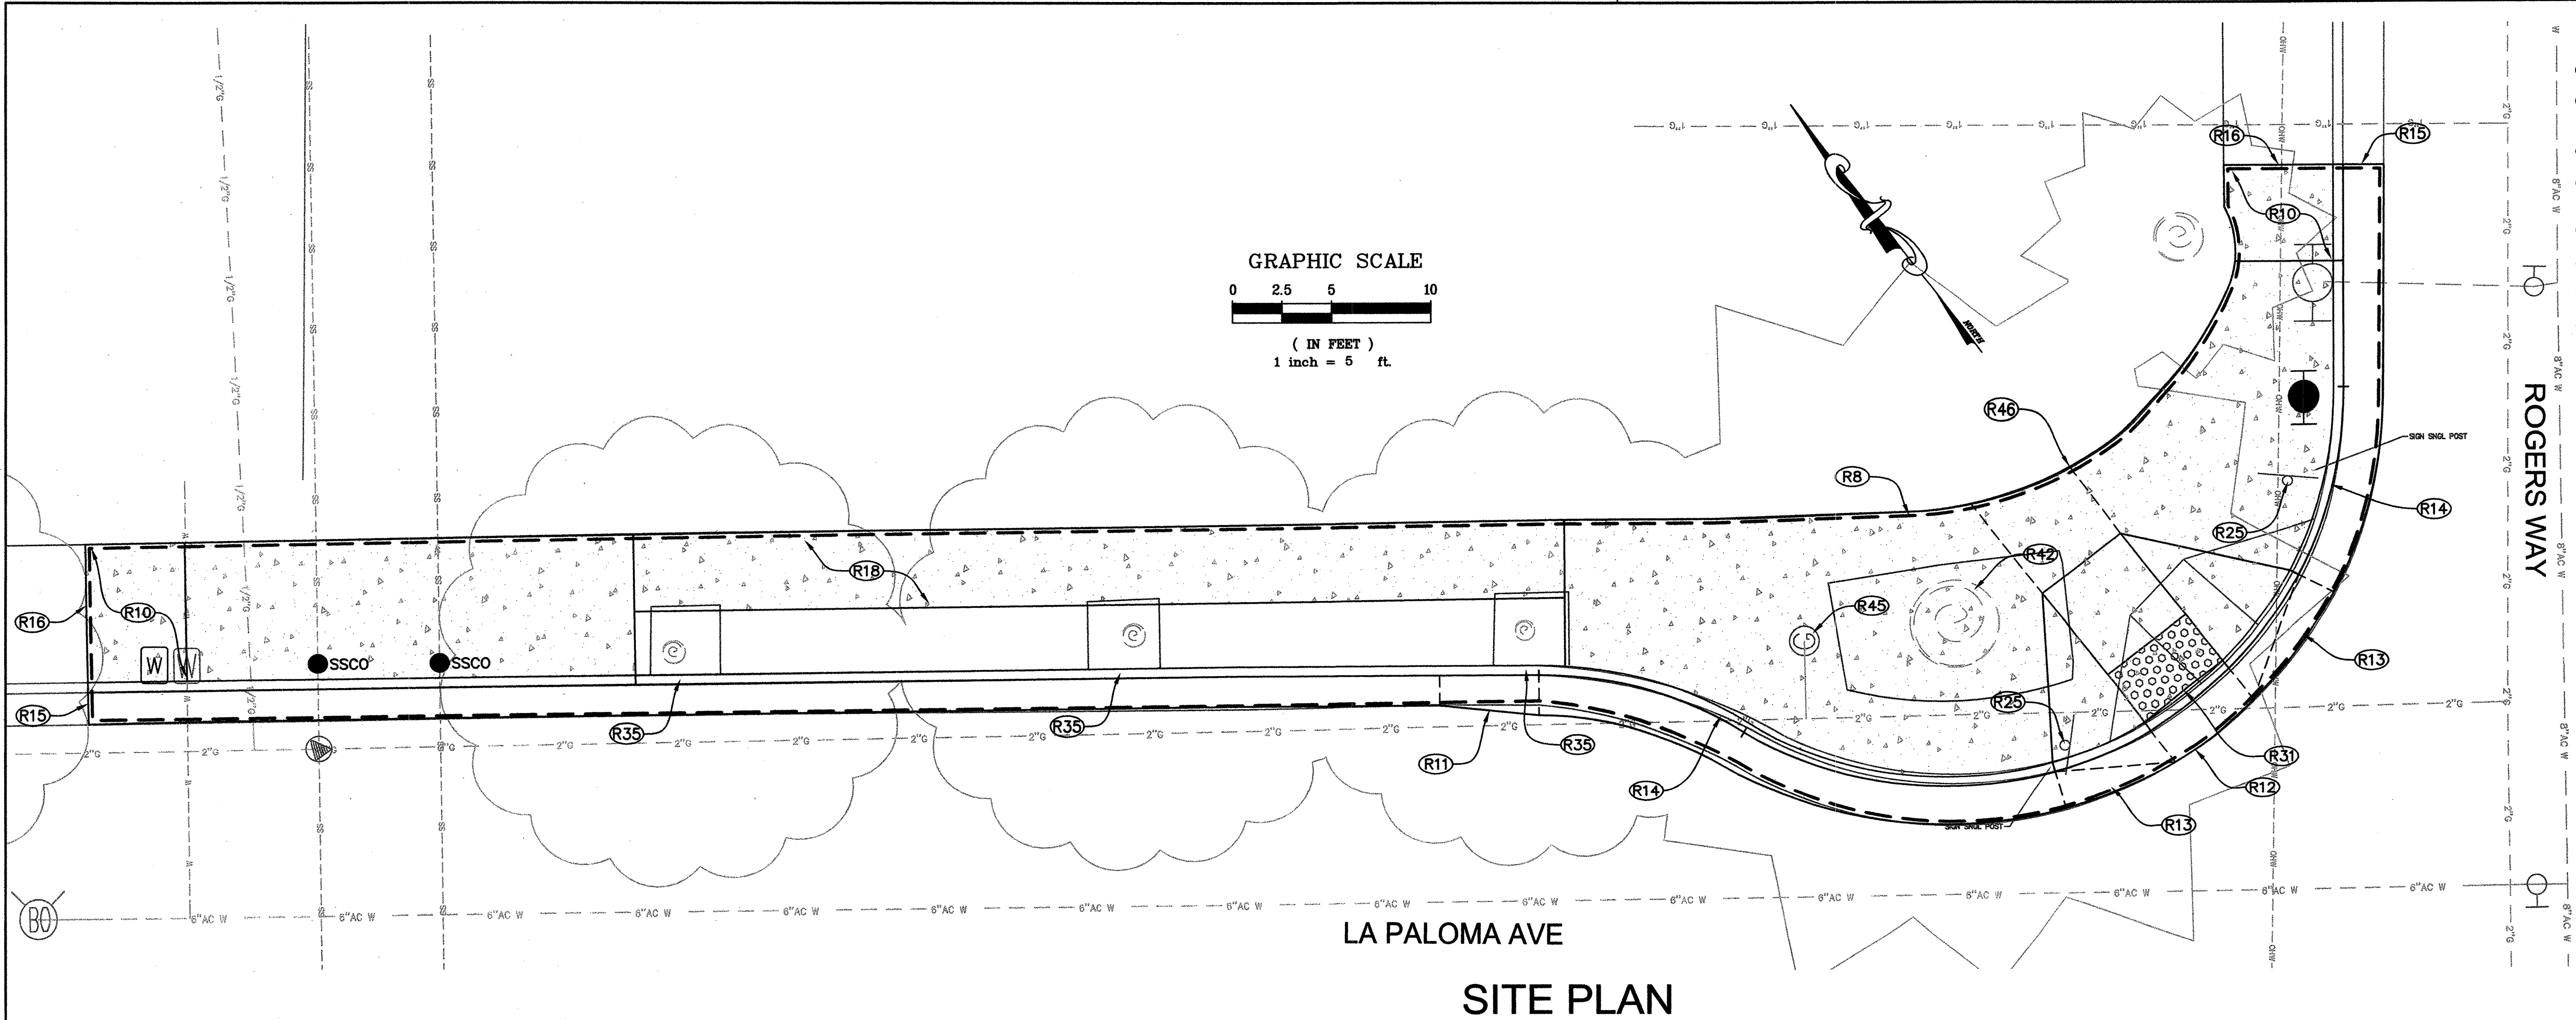

PEDESTRIAN RAMP COORDINATE TABLE		
POINT #	NORTHING	EASTING
198	1926960.14	6363459.25
199	1926957.22	6363463.30
200	1926944.00	6363481.63
201	1926916.43	6363519.61
202	1926910.97	6363527.06
203	1926905.94	6363534.23
204	1926904.74	6363536.46
205	1926903.25	6363541.57
206	1926903.40	6363547.59
207	1926905.42	6363553.15
208	1926906.40	6363554.38
209	1926910.74	6363556.94
210	1926907.13	6363561.74
211	1926903.13	6363558.73
212	1926897.95	6363554.83
213	1926891.92	6363547.47
214	1926890.18	6363541.75
215	1926899.02	6363541.57
216	1926898.92	6363536.58
217	1926890.08	6363536.75
218	1926891.30	6363531.66
219	1926894.73	6363525.90
220	1926902.37	6363520.35
221	1926910.39	6363515.13
222	1926913.22	6363517.22
223	1926910.82	6363513.79
224	1926913.80	6363509.78
225	1926940.76	6363479.28
226	1926937.72	6363477.07
227	1926951.41	6363459.11
228	1926953.95	6363454.78

PROFESSIONAL ENGINEER & LAND SURVEYOR
STATE OF CALIFORNIA
No. C 88180
CIVIL
2/13/20

CITY OF SANTA ROSA
CAPITAL IMPROVEMENT PROJECT
LA PALOMA AVE, EAST HAVEN DR & ROGERS WAY
SEWER AND WATER SYSTEM IMPROVEMENTS

CURB RAMP DETAILS
LA PALOMA AT ROGERS (NE)

CONTRACT NO.
C00308

SHEET 15 OF 25

FILE NO.2019-0050

SCALE: AS SHOWN
DWN BY: WJK

DATE: ---
CHK BY: SRV

APPROVED: Deputy Director - Engineering
By:
LORI URBANEK





















NO.

DATE


REVISION

BY

Costland Civil Engineering, Inc.
1400 Nectomas Avenue, Santa Rosa, CA 95405
707.571.8005
707.571.8037 Fax

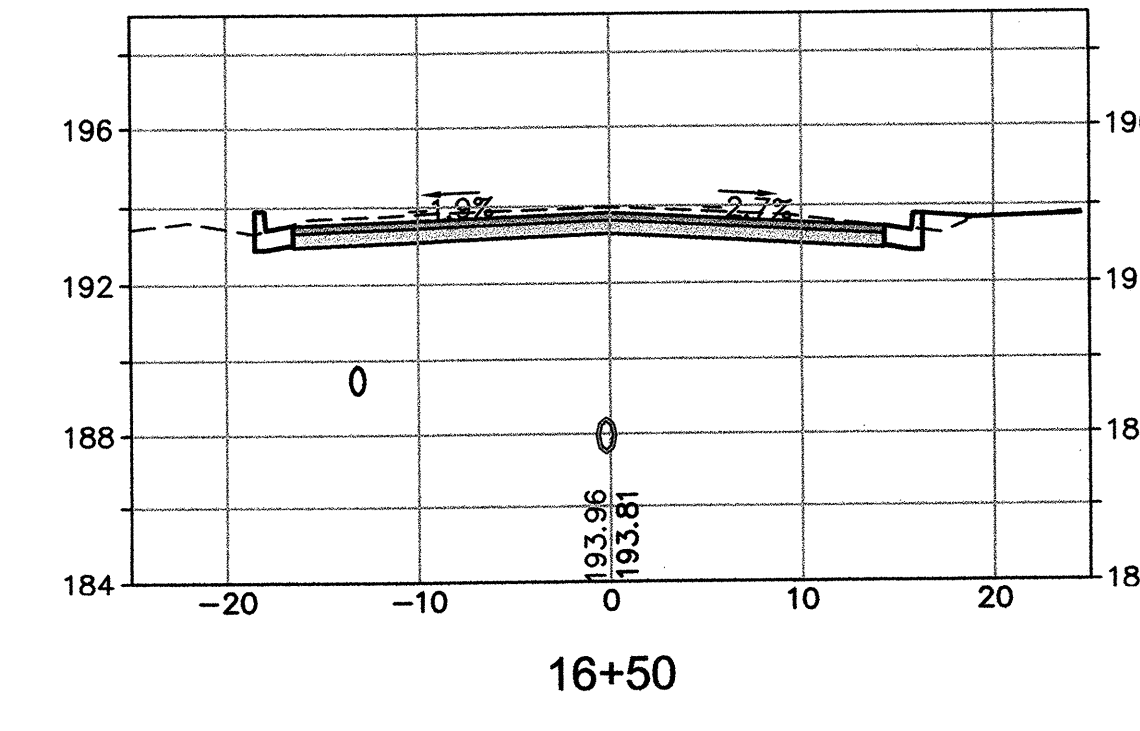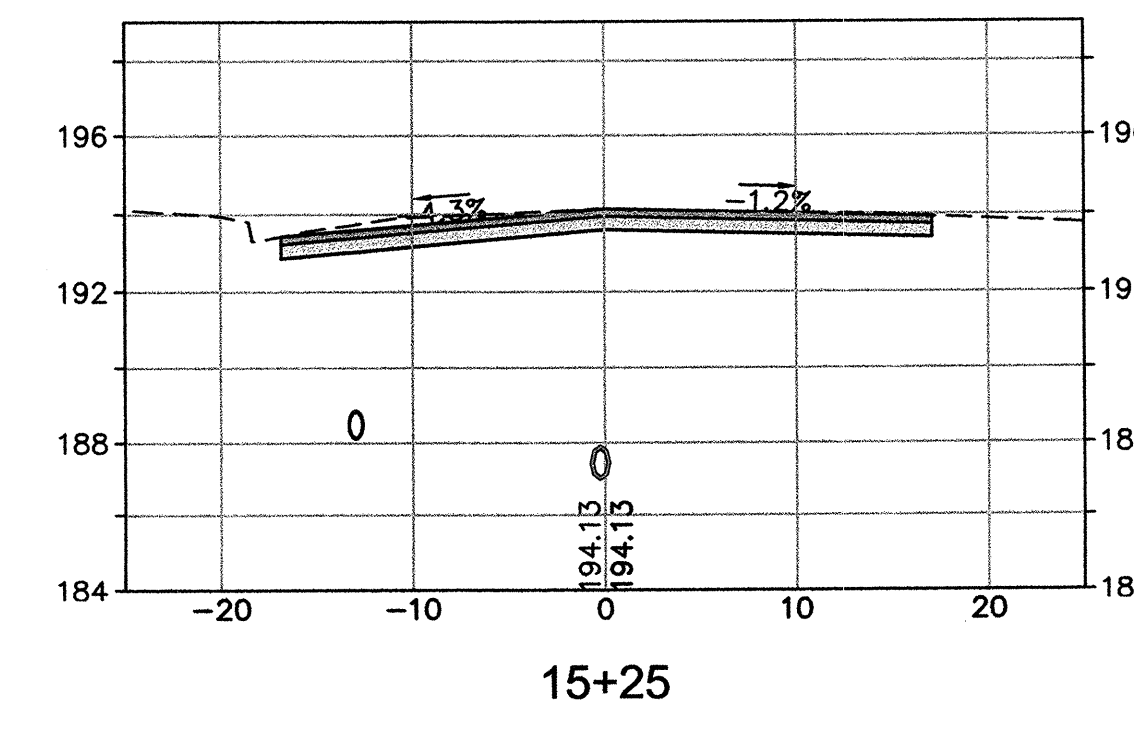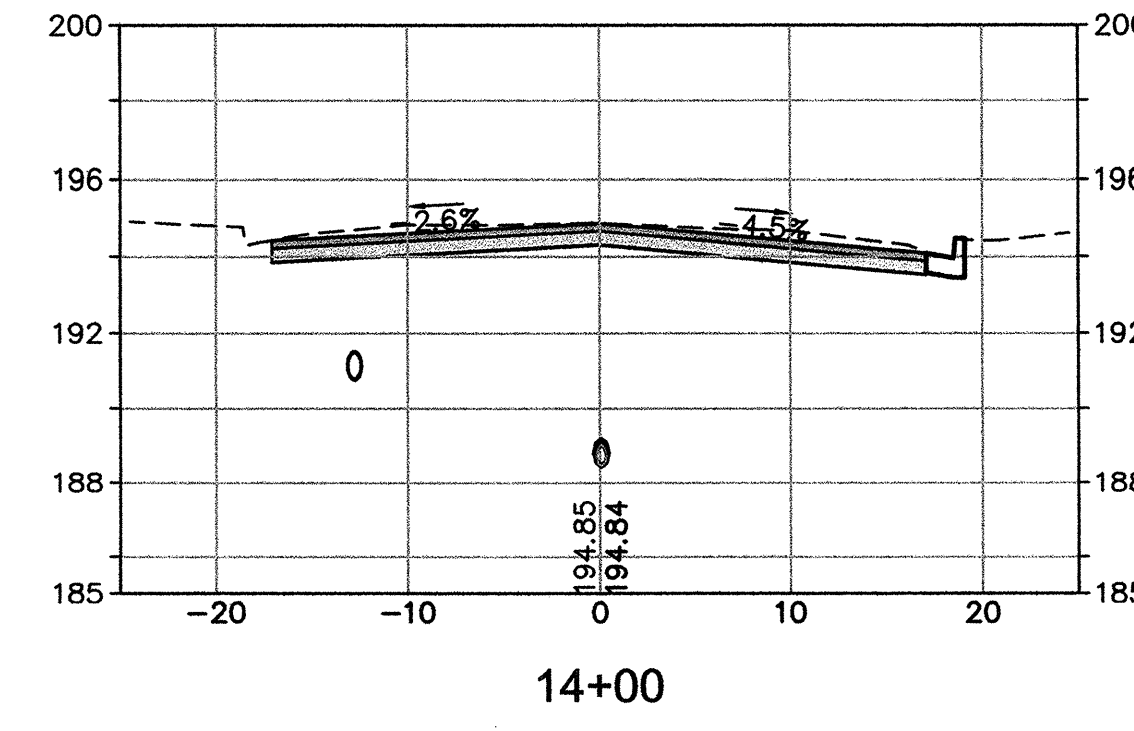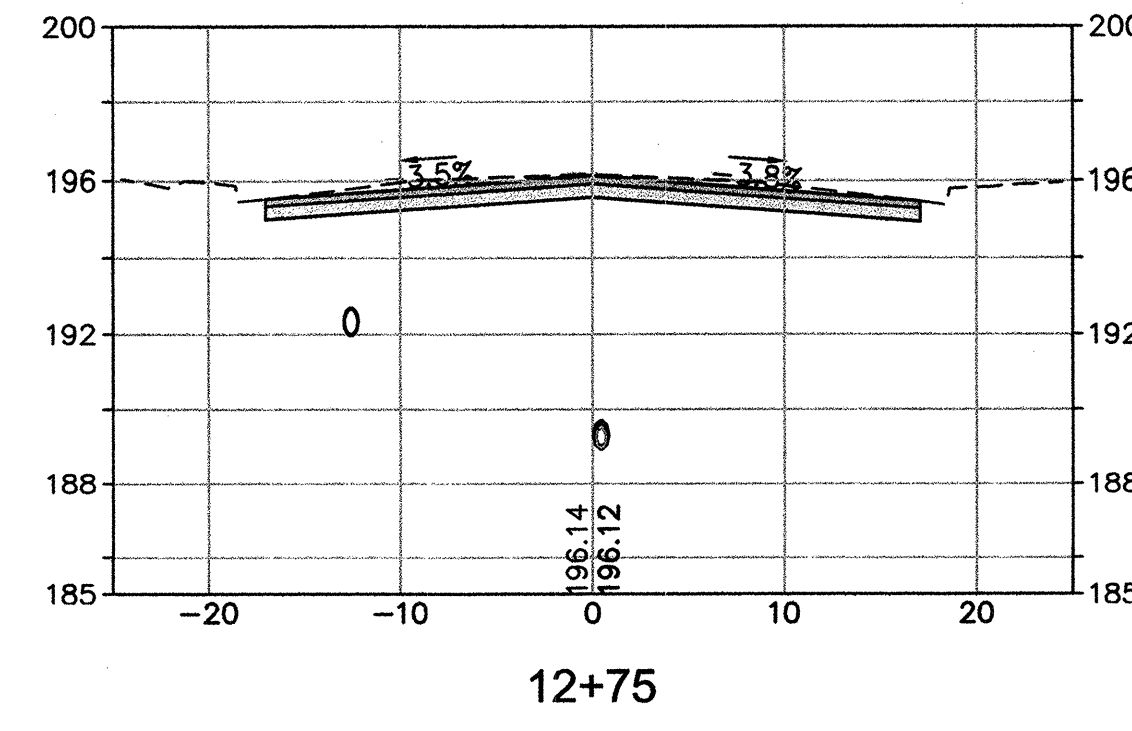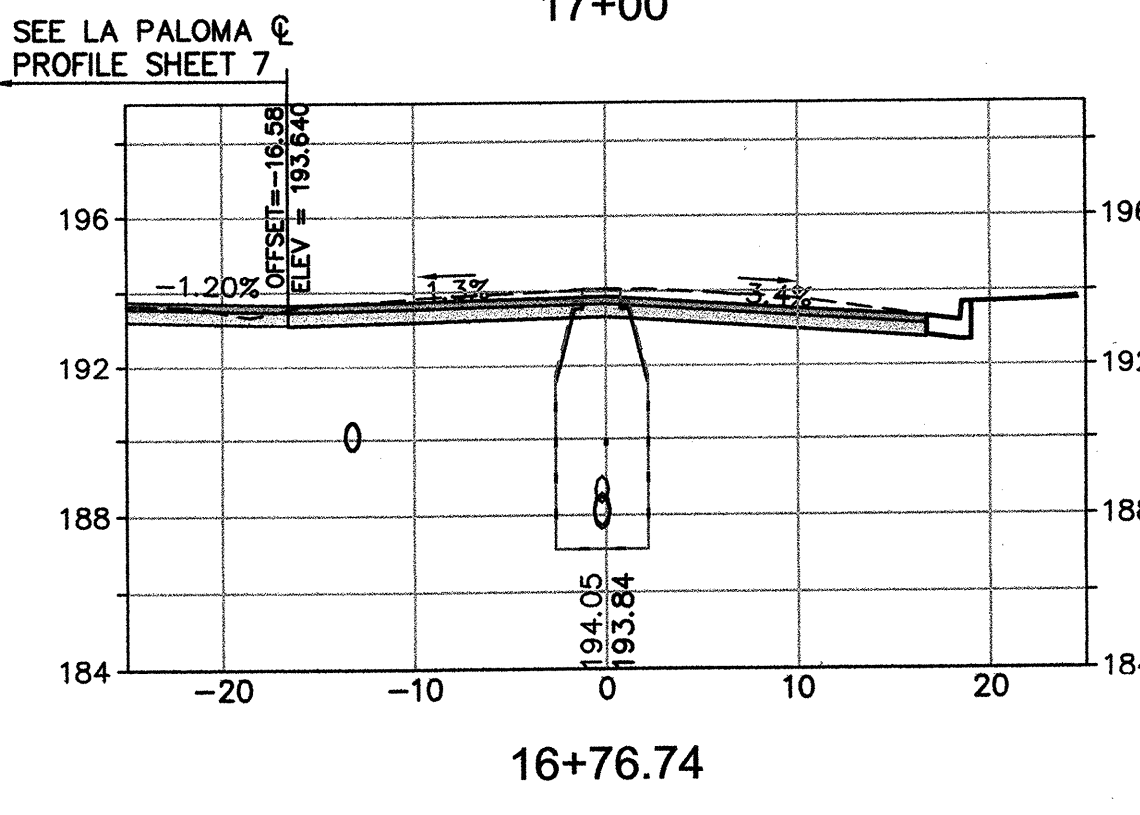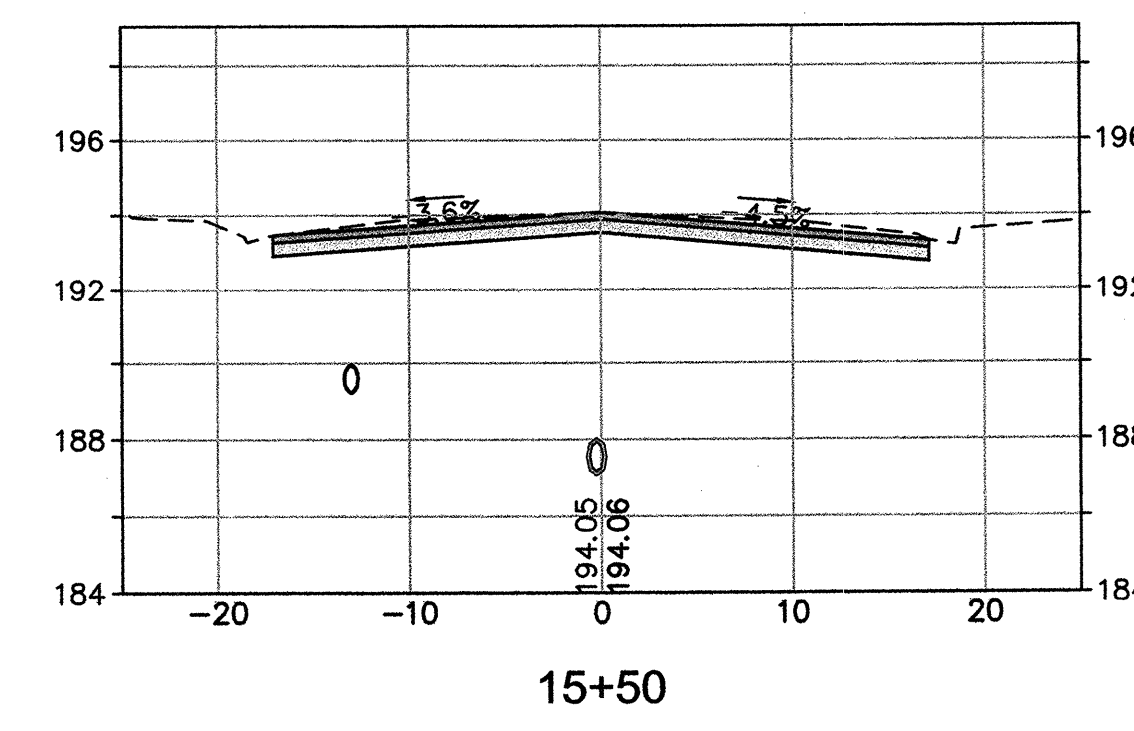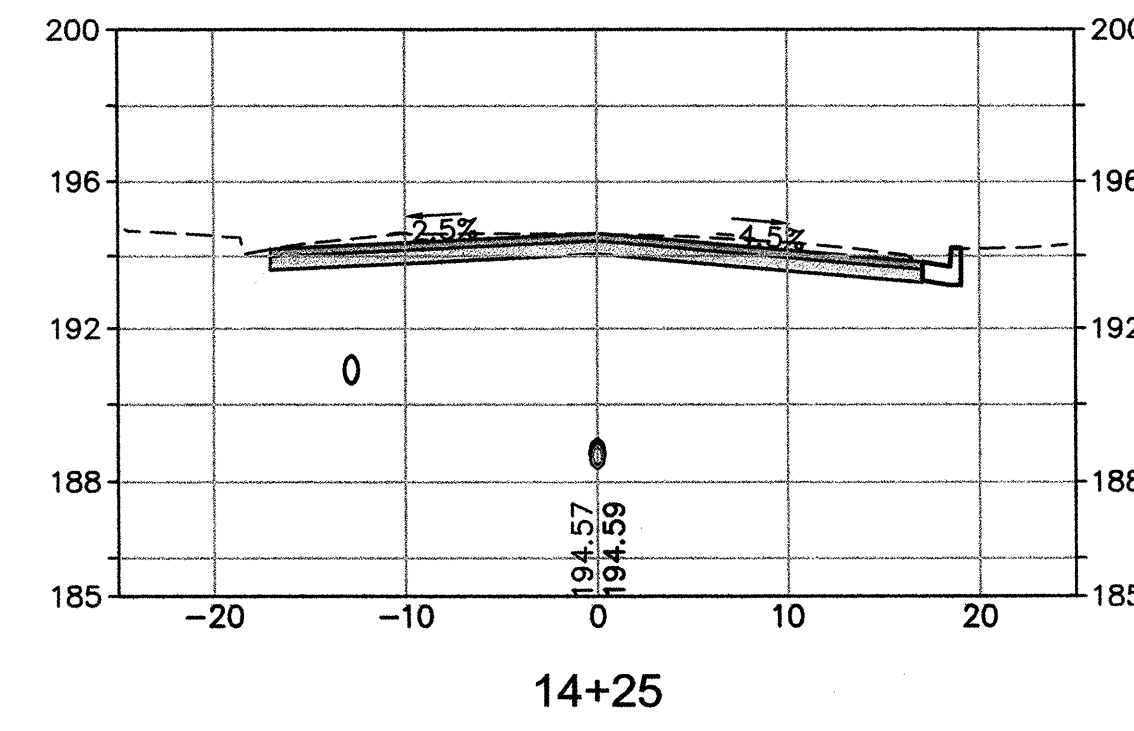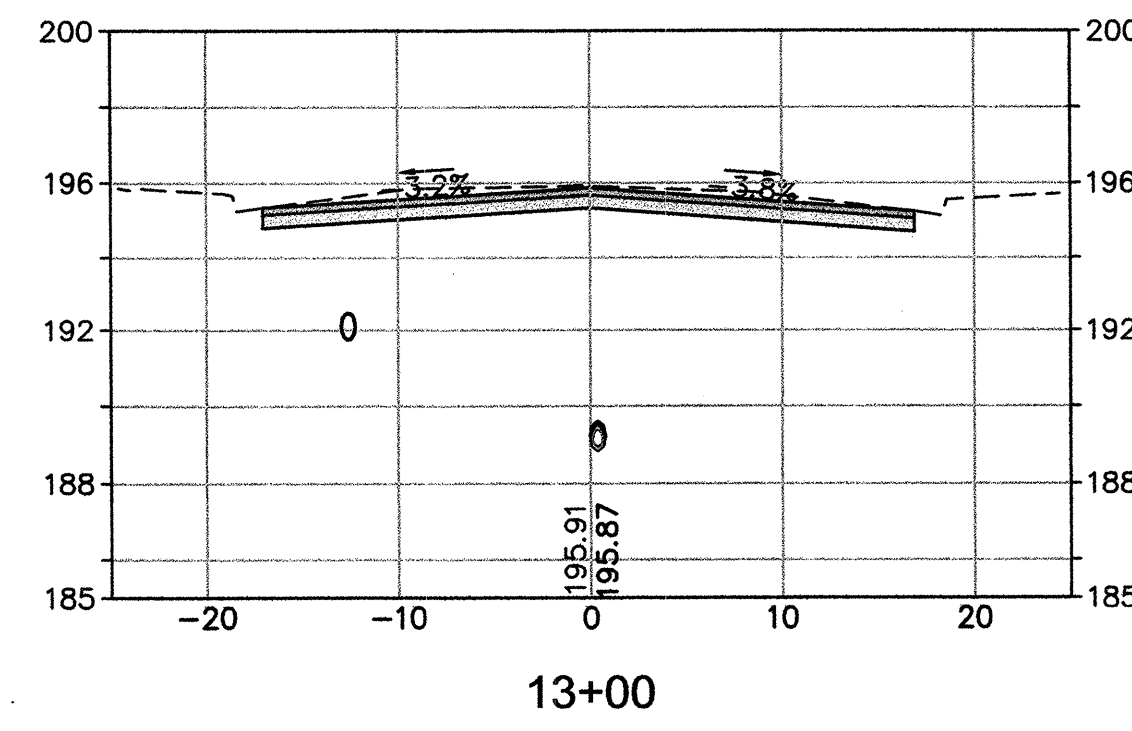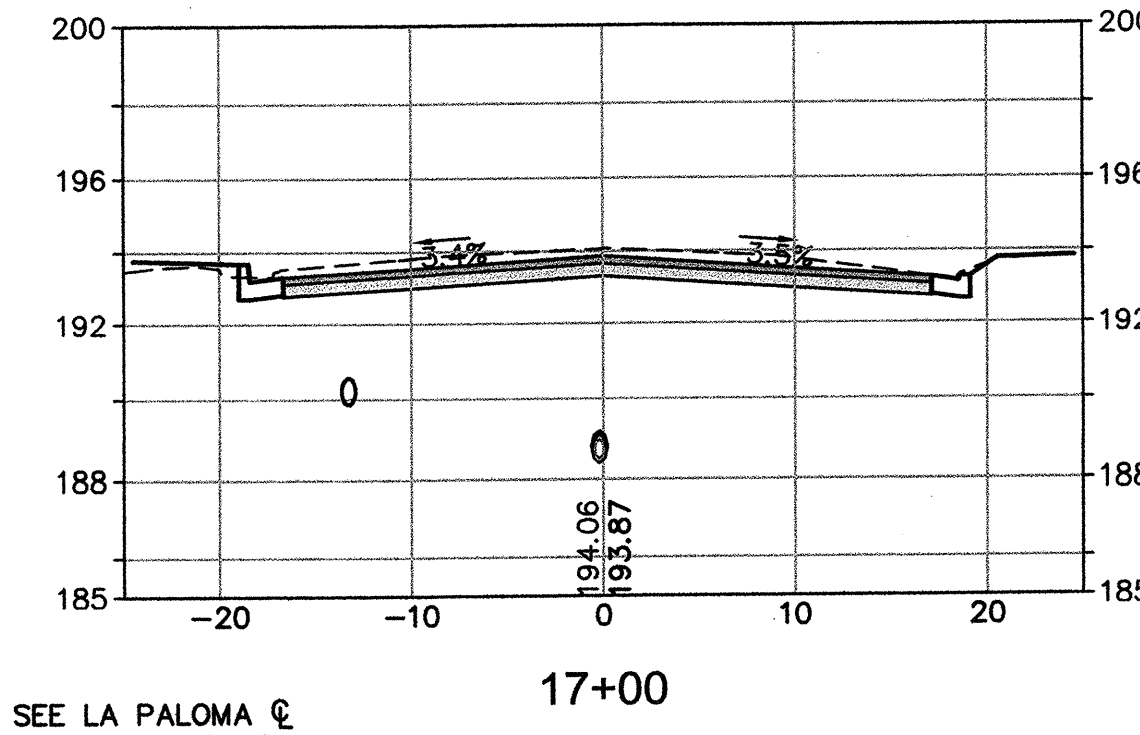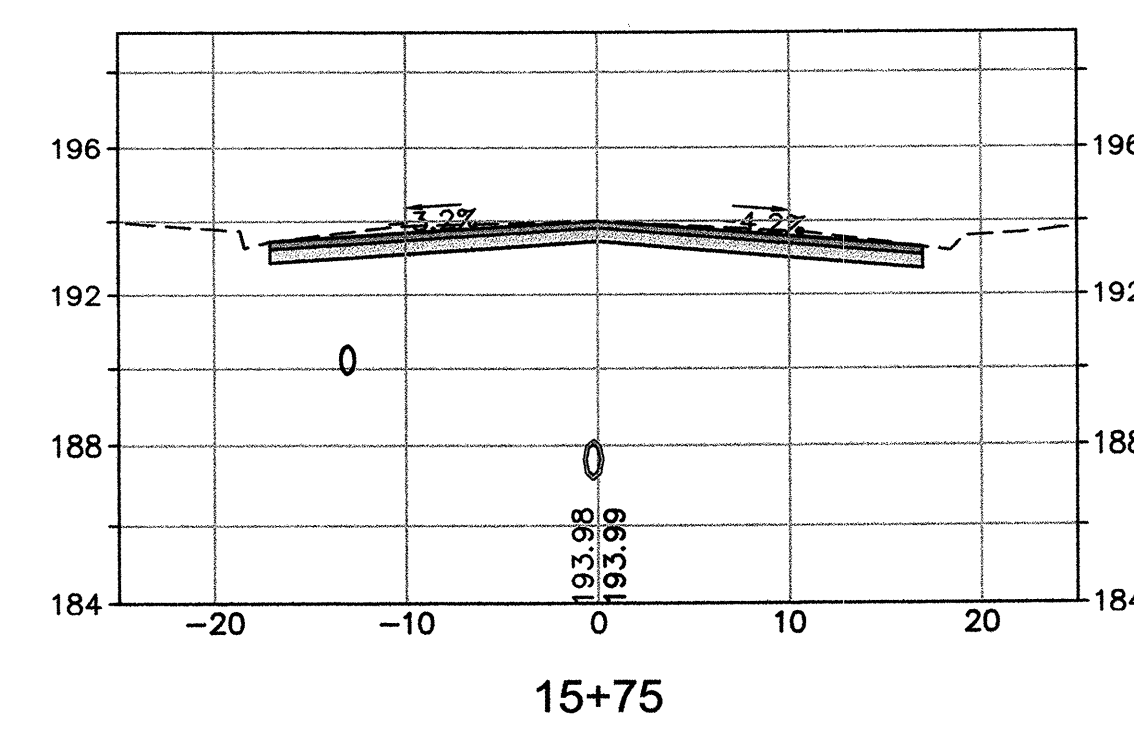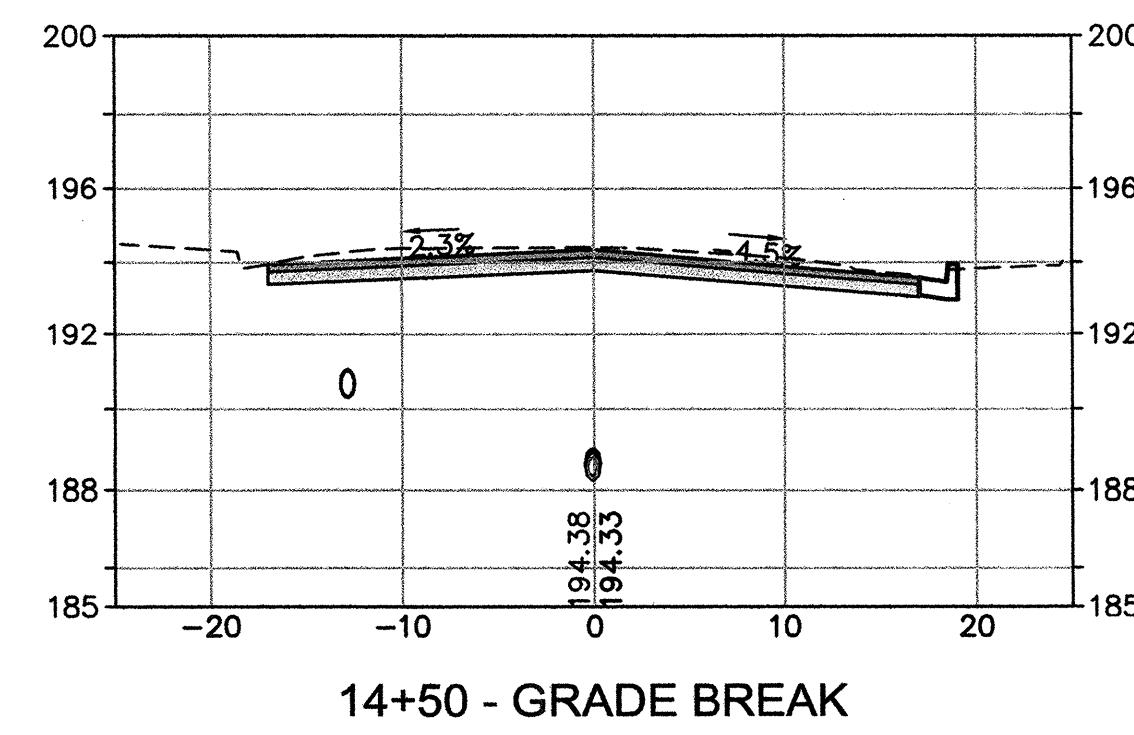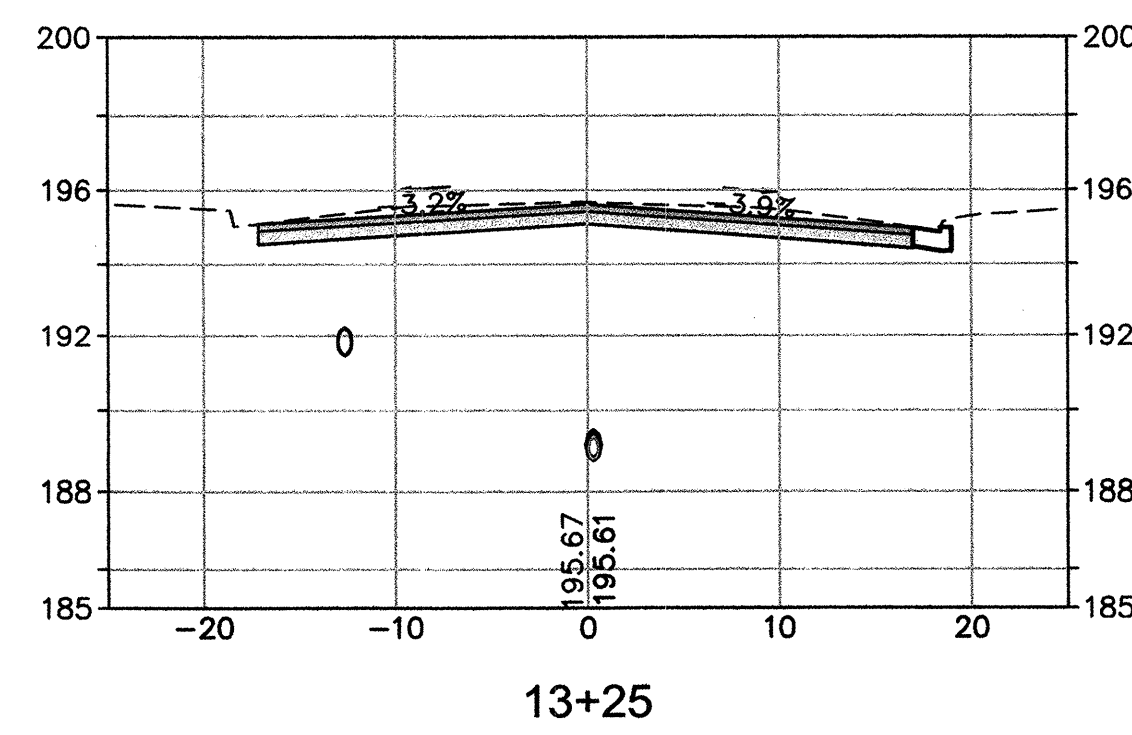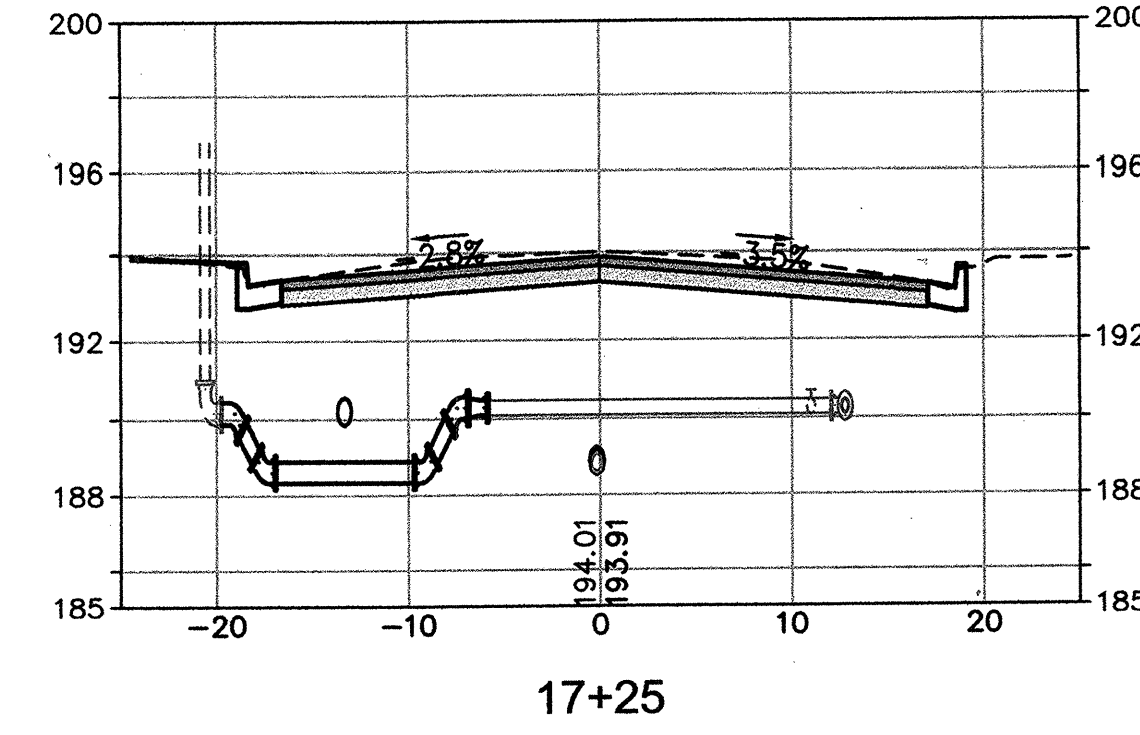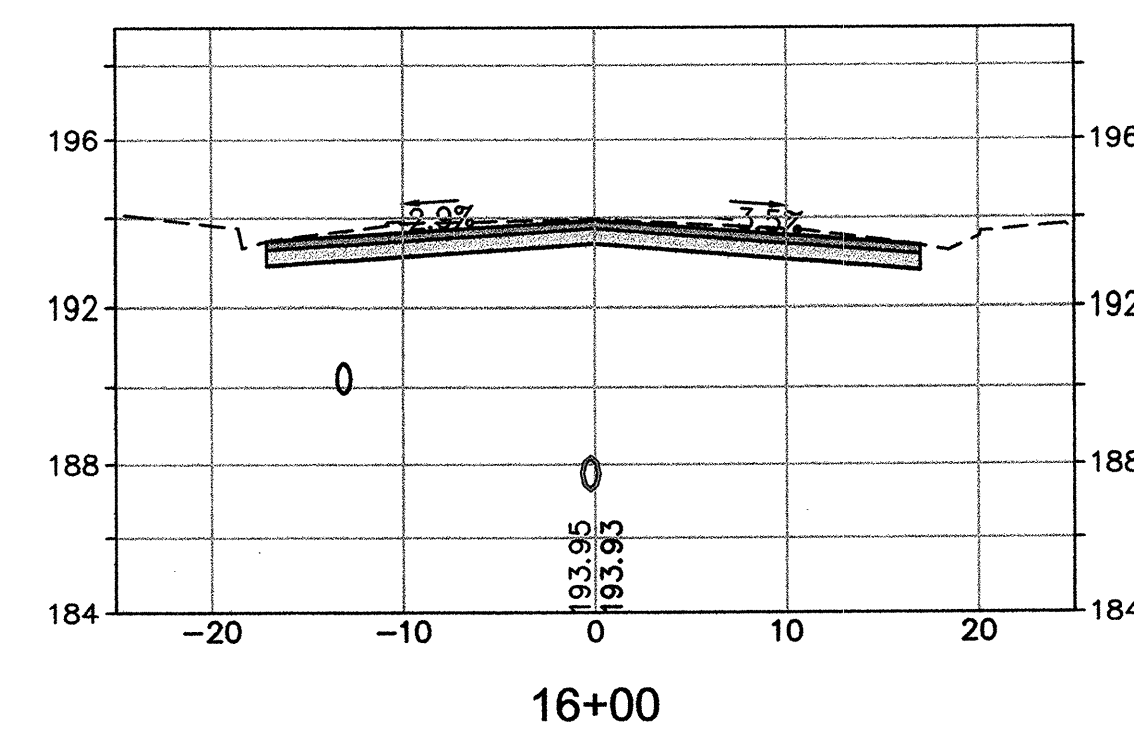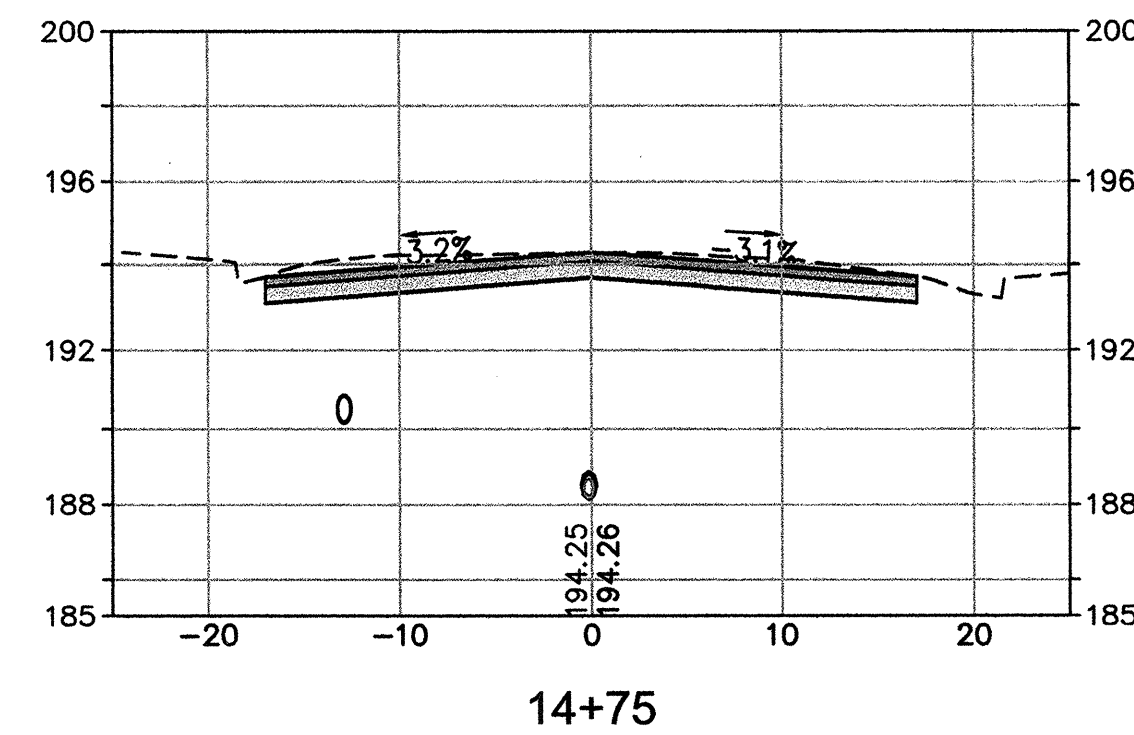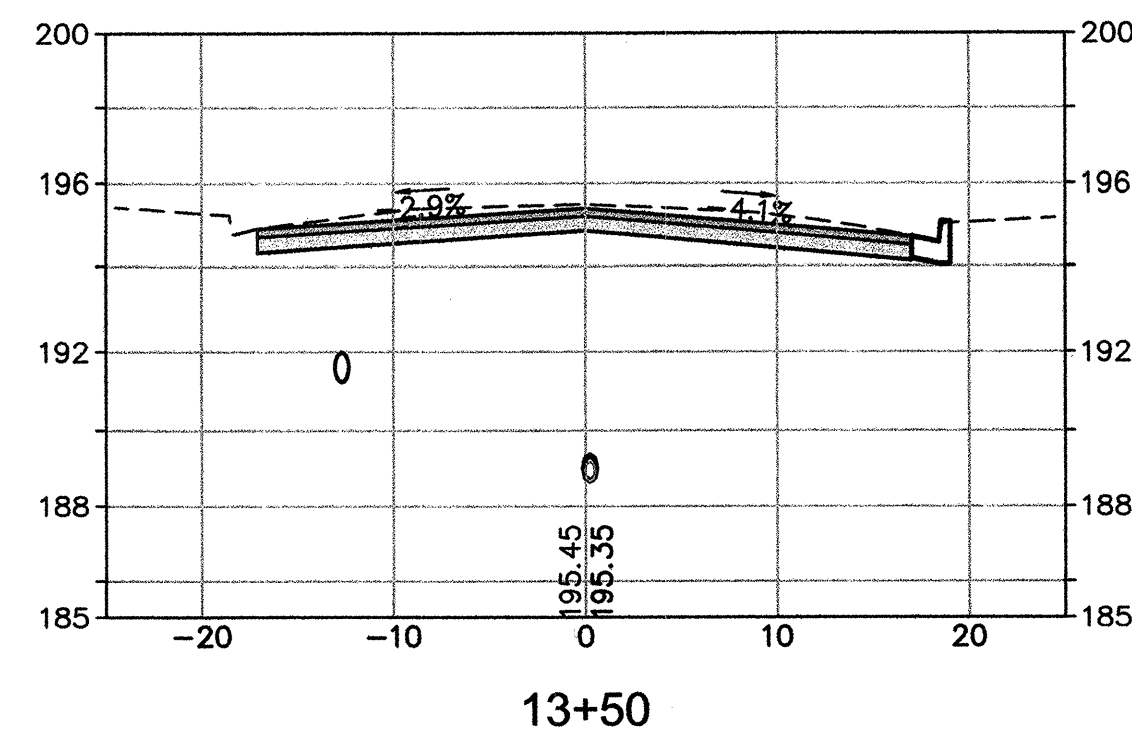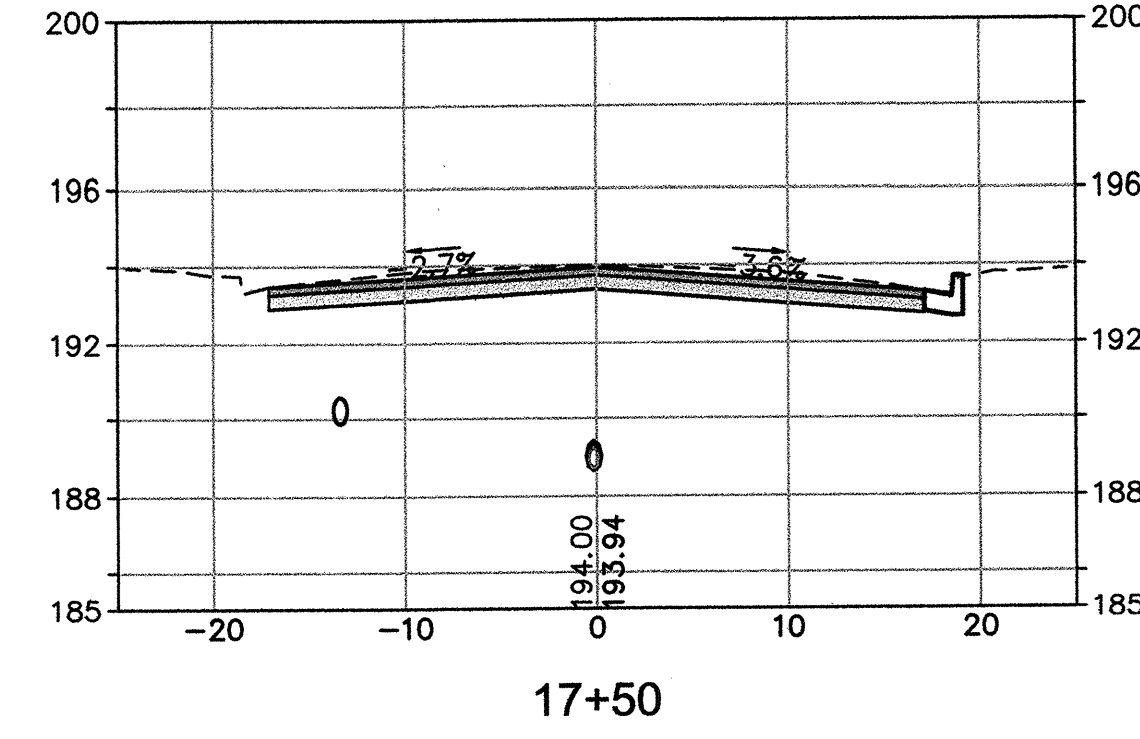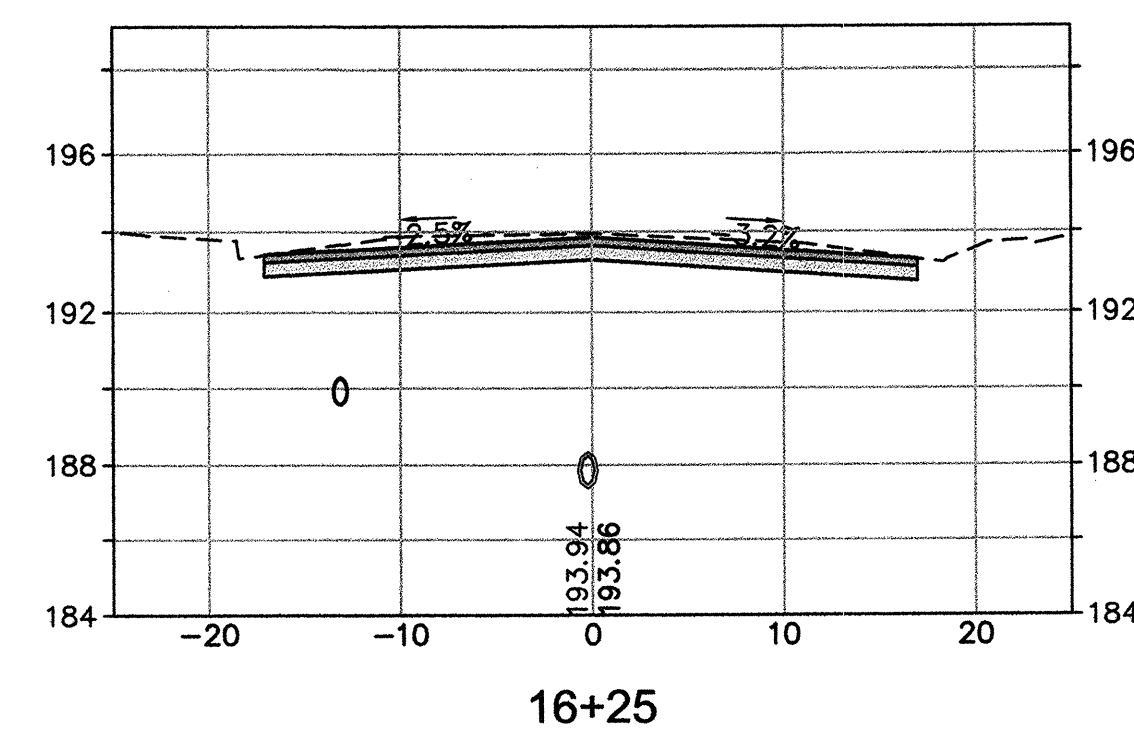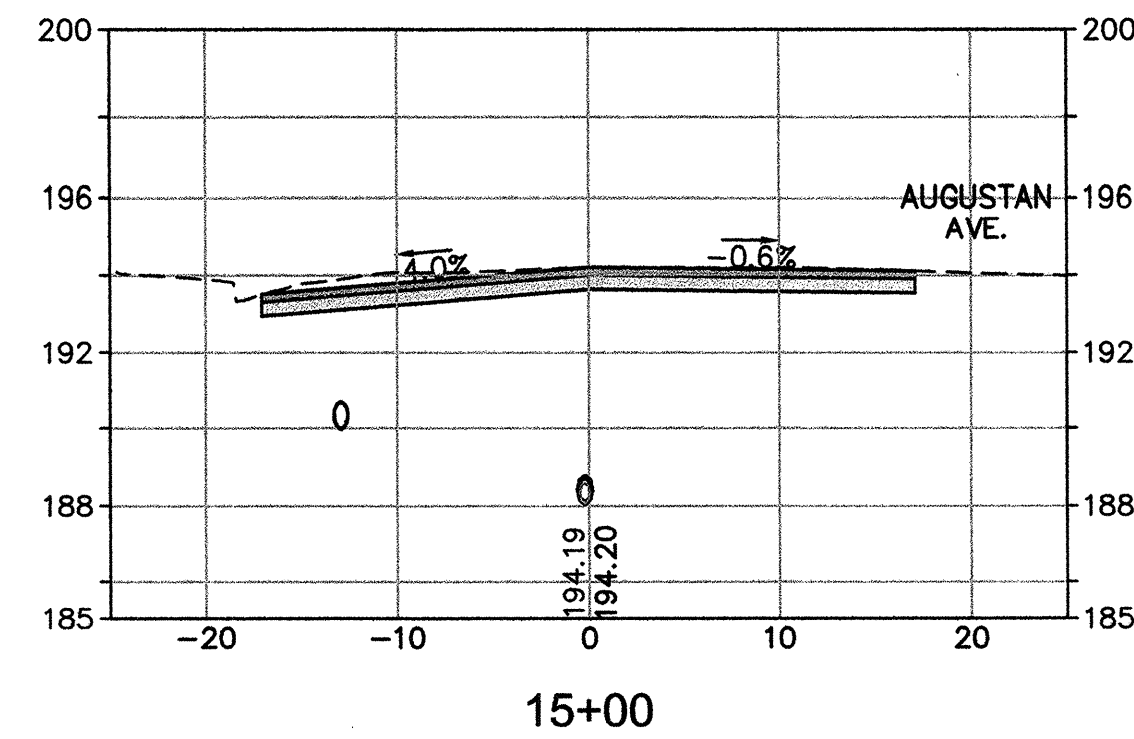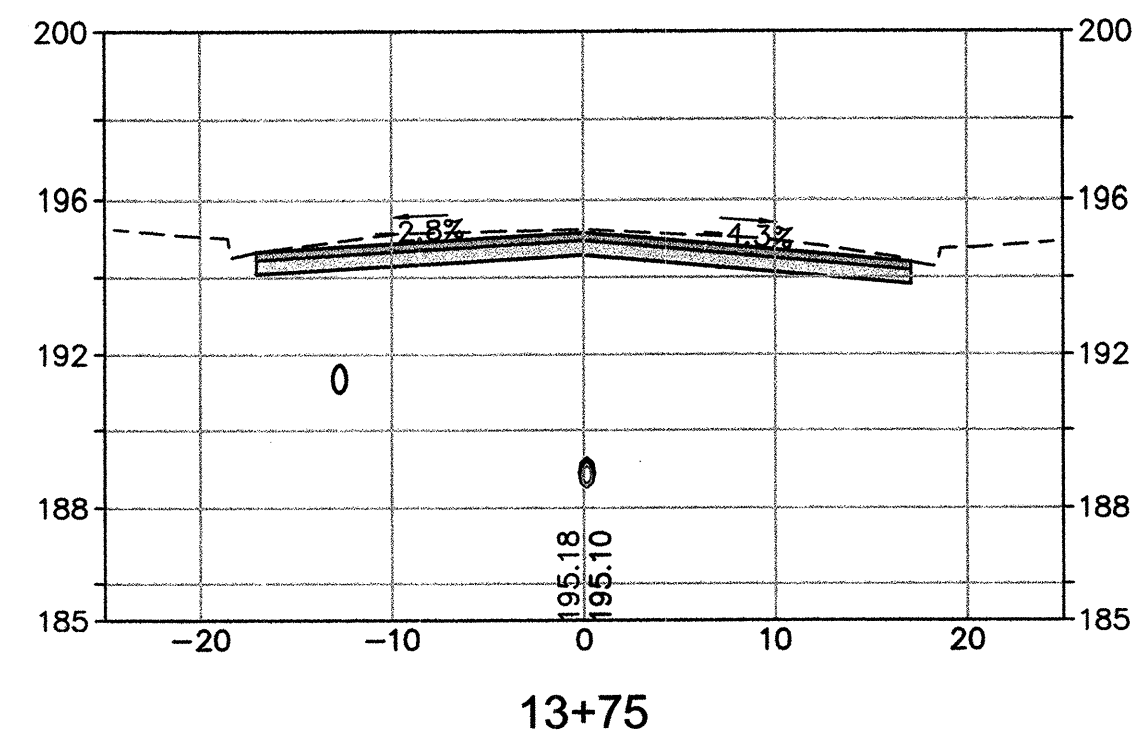






CROSS SECTION SCALES	
HORIZ.	1"=10'
VERT.	1"=5'

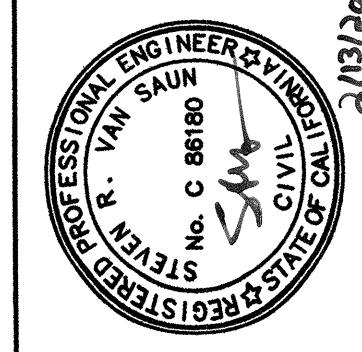

Coastland Civil Engineering, Inc.
1400 Neotomas Avenue, Santa Rosa, CA 95405
707.571.8005 707.571.8037 Fax

SCALE:	AS SHOWN	DATE:	FEBRUARY 2020	NO.	DATE	REVISION	BY
DWN BY: WJK	---	CHK BY: SRV	---				
APPROVED: Deputy Director -- Engineering <i>Mr. Webb</i> Date <u>2/25/2020</u>							
By <u>LOBI LUBRANEK</u>							


CITY OF SANTA ROSA CAPITAL IMPROVEMENT PROJECT LA PALOMA AVE. EAST HAVEN DR & ROGERS WY SEWER AND WATER SYSTEM IMPROVEMENTS	CONTRACT NO. C00308	
	SHEET 18 OF 25	
FILE NO. 2019-005		

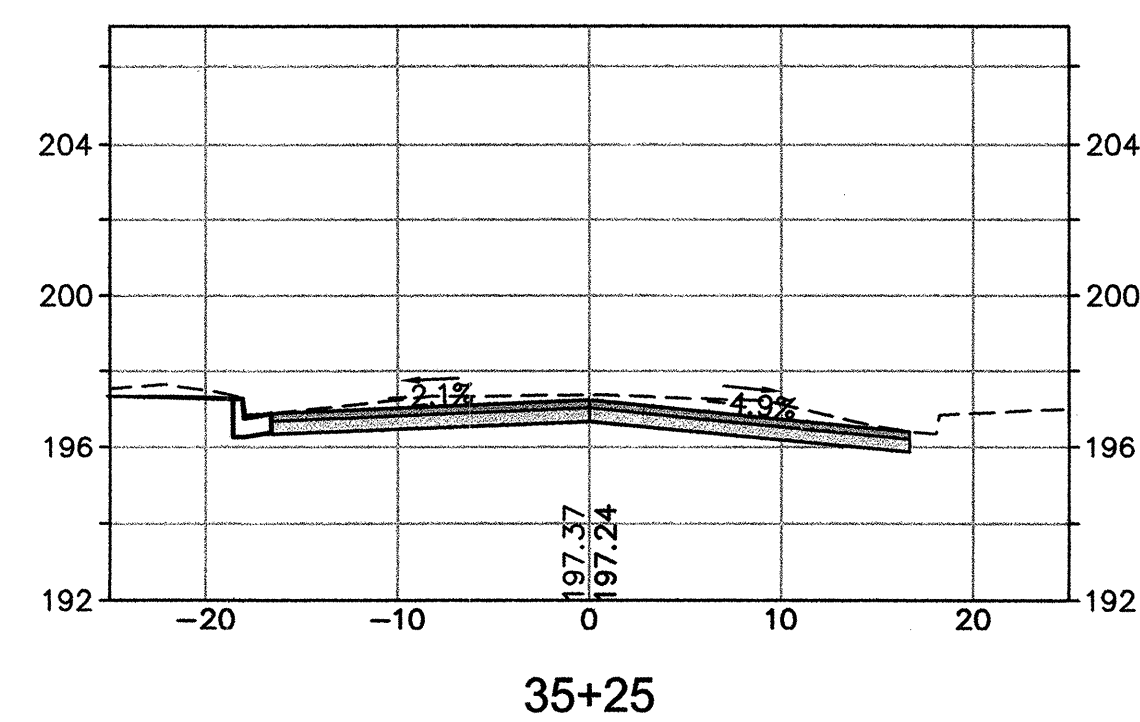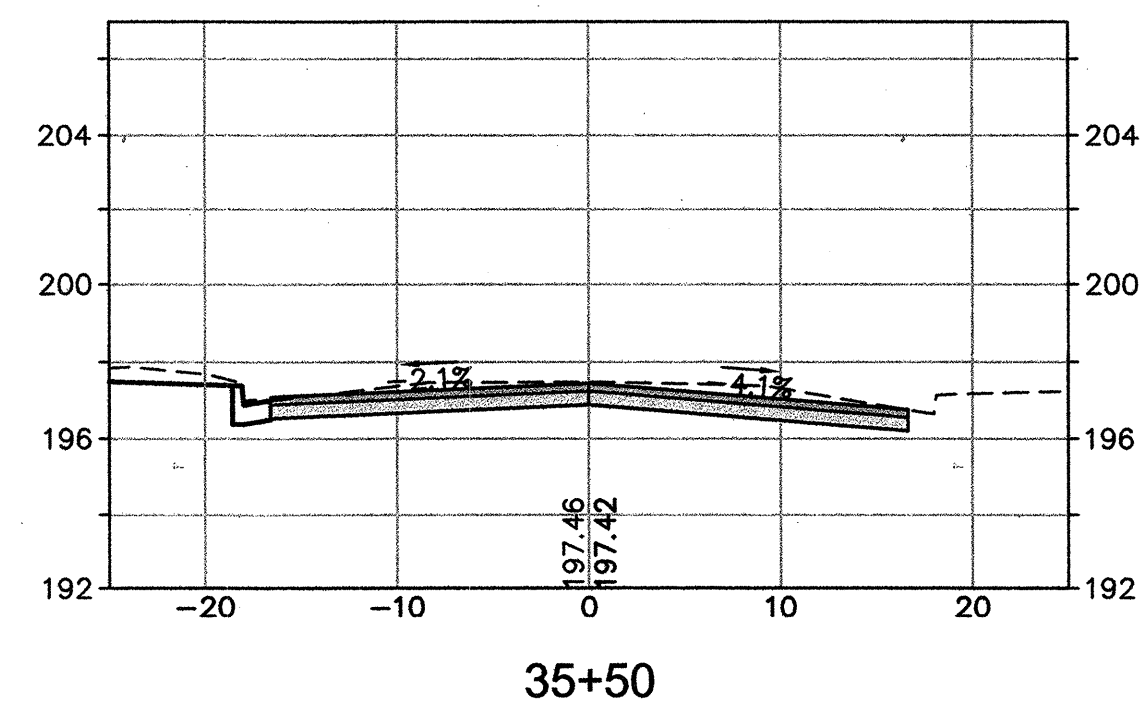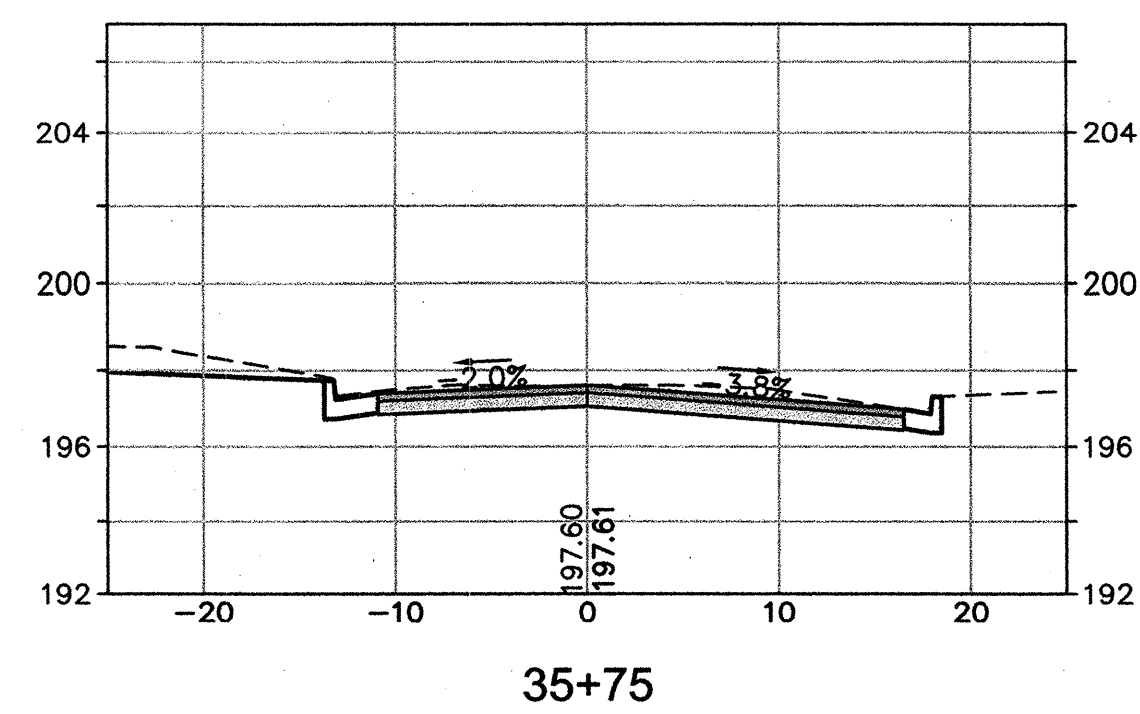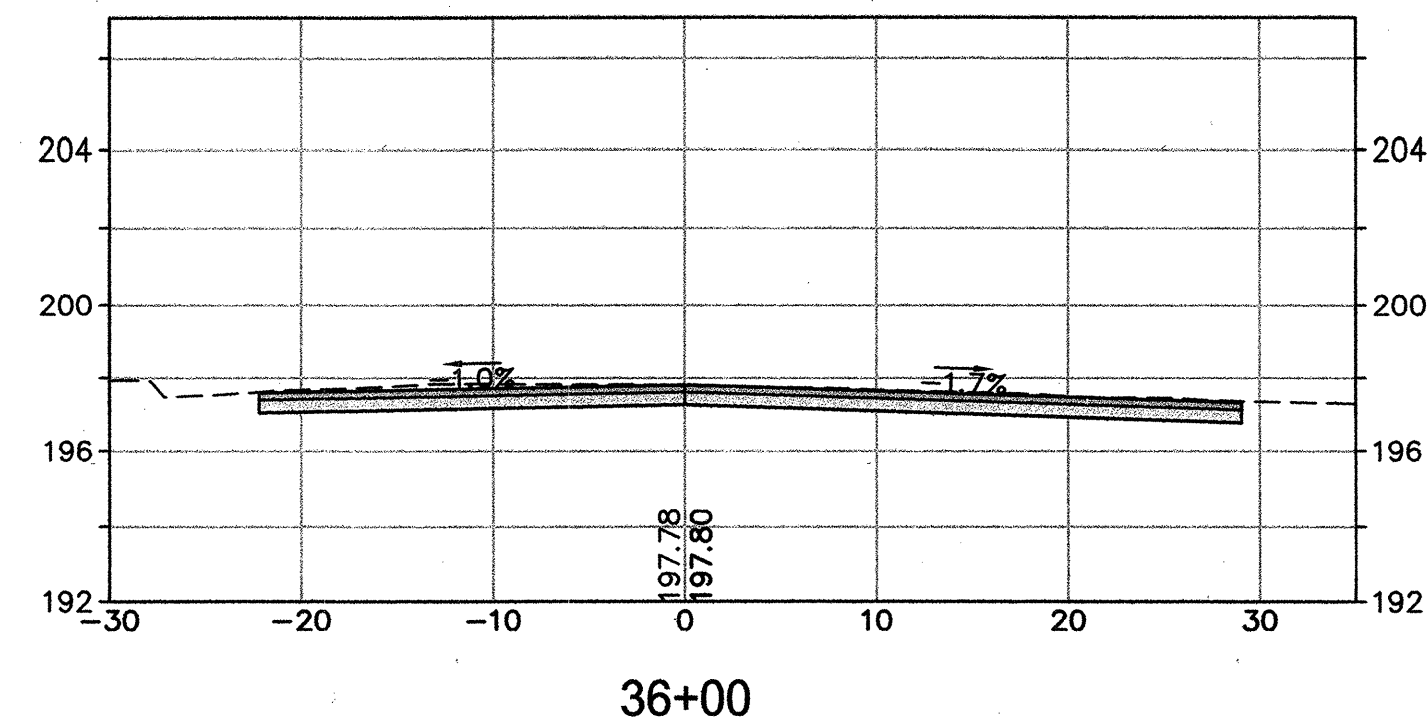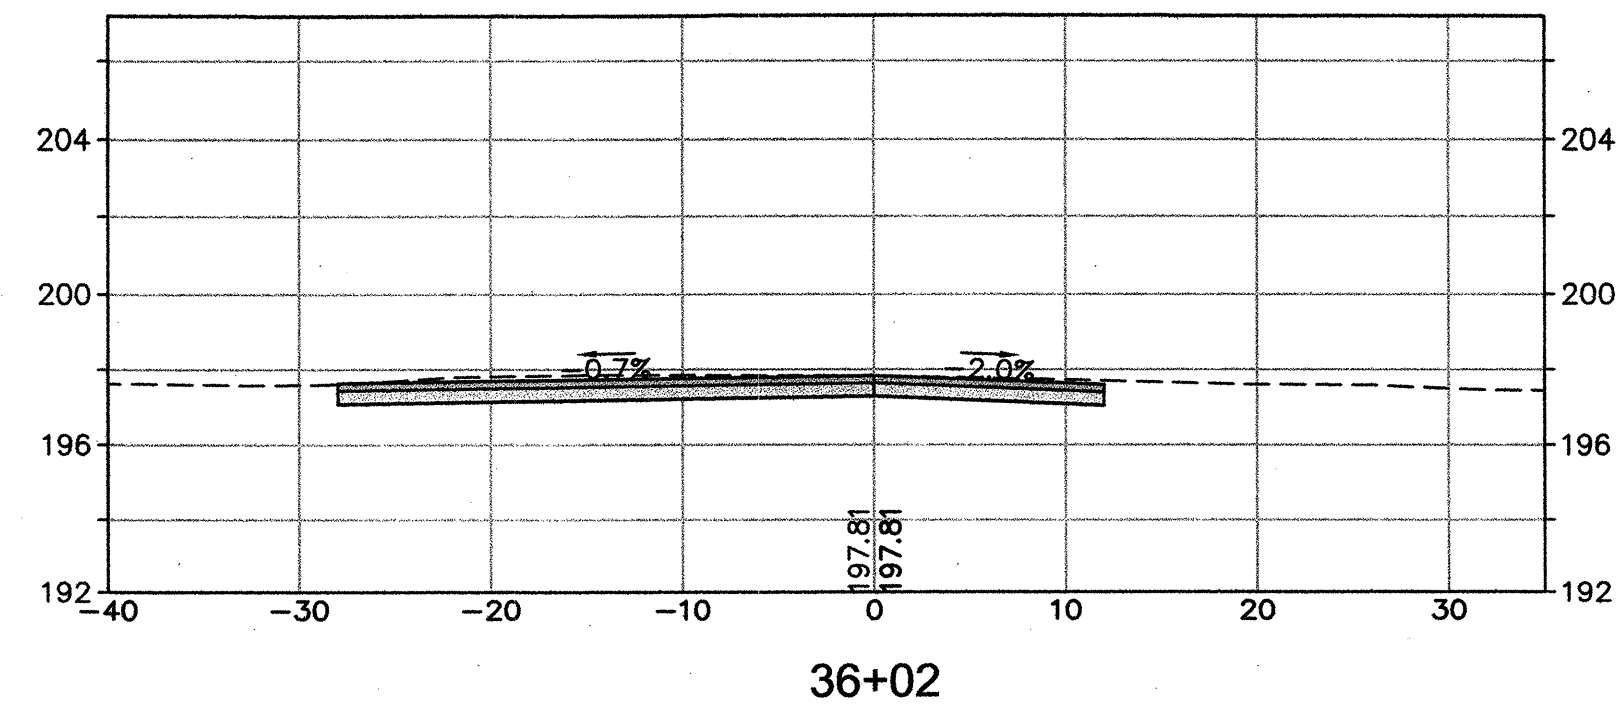

CROSS SECTION SCALES	
HORIZ.	1"=10'
VERT.	1"=5'



Coastland Civil Engineering, Inc.
1400 Neotomas Avenue, Santa Rosa, CA 95405
707.571.8037 Fax
707.571.8005

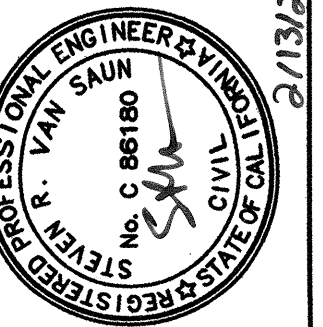

BY	NO.	DATE	REVISION
BT			

DWN BY: WJK SCALE: AS SHOWN CHK BY: SRV DATE: FEBRUARY 2020	---	---
--	-----	-----
















APPROVED: Deputy Director – Engineering

By: *Lori Urbanek* Date: 2/5/2020

LORI URBANEK

LA PALOMA AVE CROSS SECTIONS
STA. 35+25 TO STA. 36+02

CONTRACT NO.	C00308
SHEET	21 OF 25
FILE NO.	2019-0050

               

CROSS SECTION SCALES
HORIZ. 1"=10' VERT. 1"=5'



1400 Neotomas Avenue, Santa Rosa, CA 95405
707.571.8005 707.571.8037 Fax

SCALE:	AS SHOWN	DATE:	FEBRUARY 2020	NO.	DATE	REVISION	BY
DWN BY: WJK	---	CHK BY: SRV	---				
APPROVED: Deputy Director – Engineering  Date <u>3/23/2020</u>							
By _____							
LORI URBANEK							


CITY OF SANTA ROSA
CAPITAL IMPROVEMENT PROJECT
LA PALOMA AVE. EAST HAVEN DR & ROGERS WY
SEWER AND WATER SYSTEM IMPROVEMENTS
ROGERS WAY CROSS SECTIONS
STA. 41+50 TO STA. 45+19.55

CONTRACT NO.
000700


SHEET 22 OF 25

FILE NO.2019-005


Images: 2018_Merged_Aerial.tif; Xrefs: CSR-ENGINEERS STAMPS-PLAN-2016.dwg; 124014-TP.dwg; BM07.DWG; 124014-SP.DWG; 124014-RAMPS.DWG

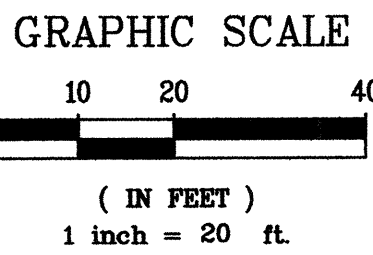

- (T1) INSTALL TRAFFIC STRIPE DETAIL 4 PER CALTRANS STD PLAN A20A.
- (T2) INSTALL WHITE THERMOPLASTIC "STOP" LEGEND PER CALTRANS STD. PLAN A24D.
- (T3) INSTALL WHITE 12" THERMOPLASTIC CROSSWALK STRIPE/LIMIT LINE PER CALTRANS STD. PLAN A24E.
- (T4) INSTALL BLUE TWO-WAY RETROREFLECTIVE MARKER PER CITY STD 857.
- (T5) INSTALL WHITE THERMOPLASTIC CONTINENTAL CROSSWALK STRIPE, 2' WIDE x 10' LONG, 3" SPACING.
- (T6) INSTALL TRAFFIC STRIPE, DETAIL 23 PER CALTRANS STD PLAN A20A.
- (T7) TRAFFIC LOOP DETECTORS NOT TO BE REPLACED.
- (T9) REPAIR PAVEMENT MARKINGS AS REQUIRED FOR WATERLINE INSTALLATION.
- (T10) HANDHOLES TO REMAIN AND ADJUSTED TO FINISH GRADE.

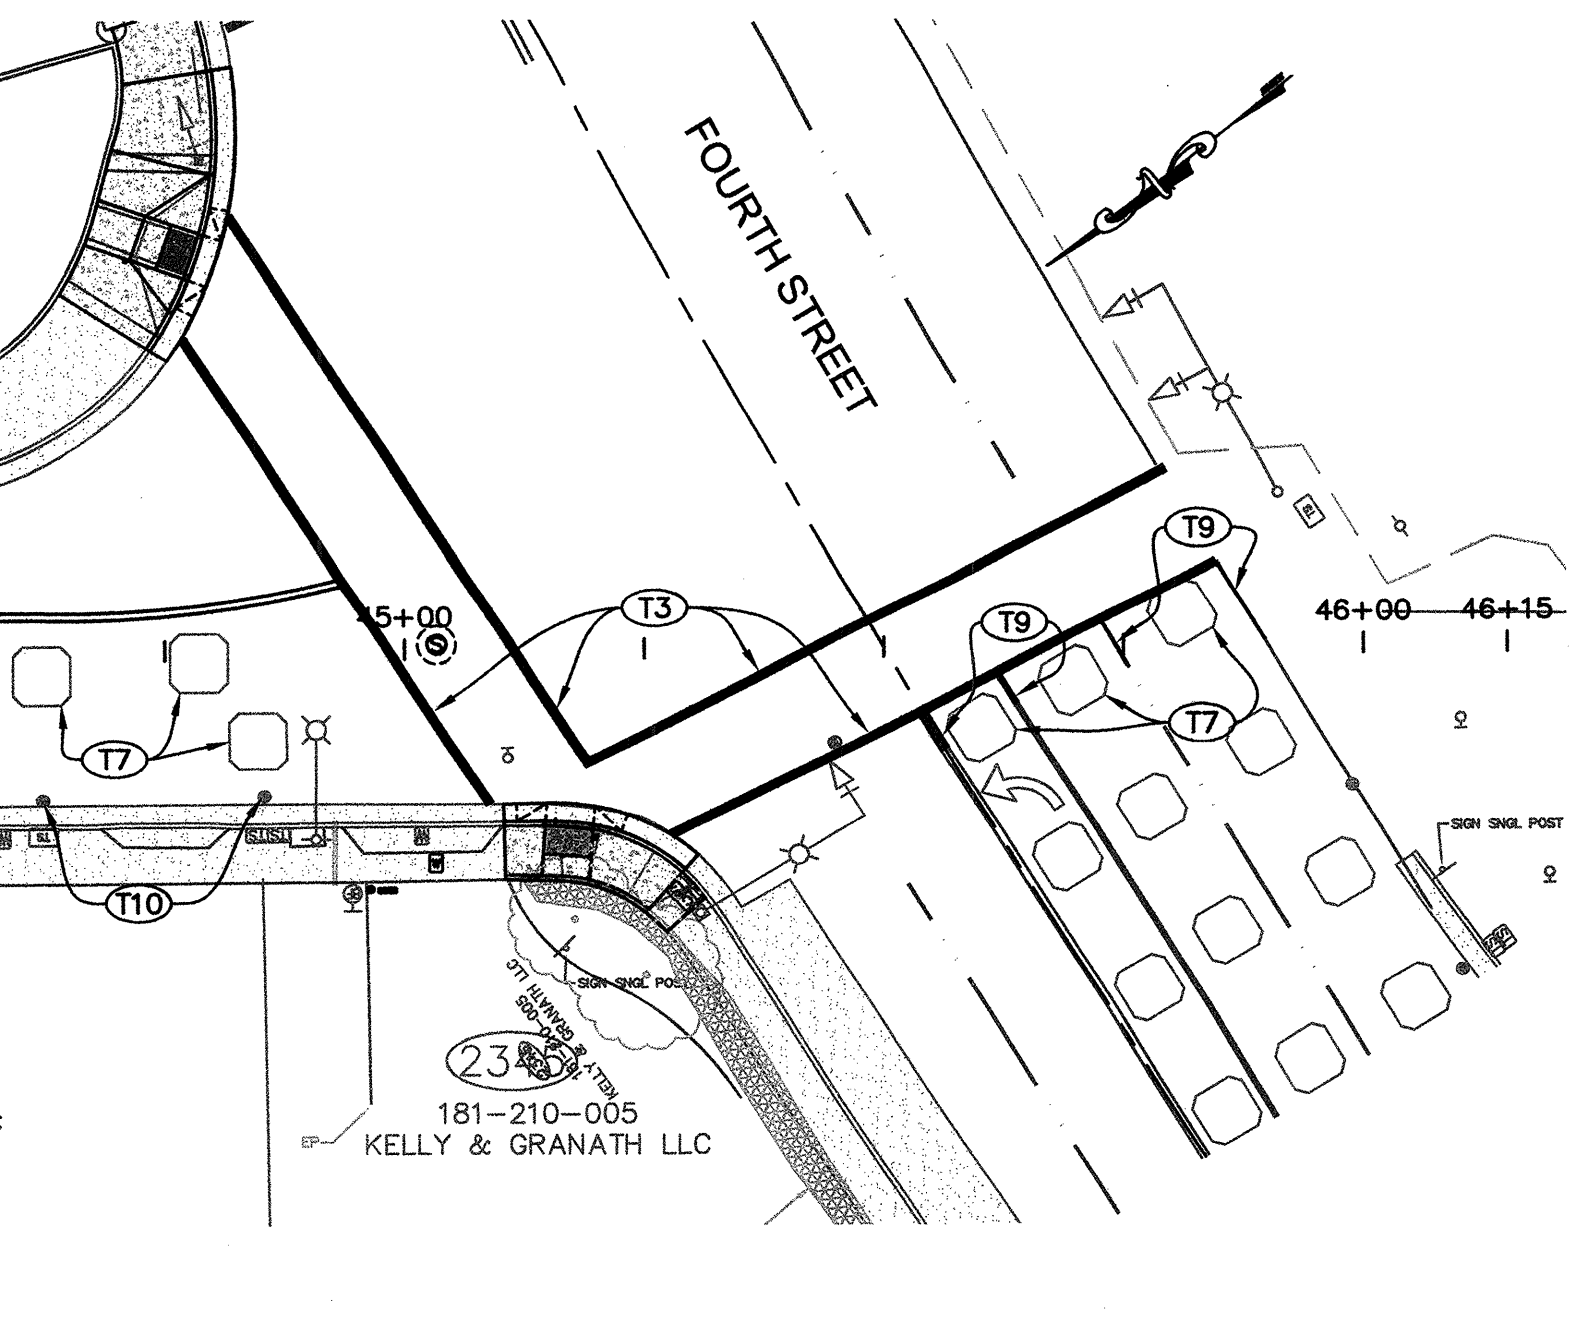

Images: 2018_Merged_Aerial.tif; Xrefs: 124014-SP.DWG; CSR-ENGINEERS STAMPS-PLAN-2016.dwg; 124014-TP.dwg; BM07.DWG
Path: F:\Civil 3D Projects\124014 La Paloma\DWG\124014-RAMPS.DWG Layout Name: SHT-24 Plot Date: Feb 11, 2020 at 11:59

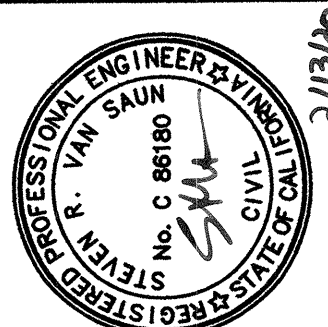

Coastland Civil Engineering, Inc.
1400 Neotomas Avenue, Santa Rosa, CA 95405
707.571.8005 707.571.8037 Fax

SCALE: AS SHOWN	DATE: ---	NO.	DATE	REVISION	BT
DWN BY: WJK	CHK BY: SRV				
APPROVED: Deputy Director - Engineering					
BY: <i>[Signature]</i> Date: 2/15/2002					
LORI URRANEK					

CITY OF SANTA ROSA
CAPITAL IMPROVEMENT PROJECT
LA PALOMA AVE. EAST HAVEN DR & ROGERS WY
SEWER AND WATER SYSTEM IMPROVEMENTS


STRIPING PLAN

LA PALOMA AVE AND ROGERS WAY

CONTRACT NO.
C00308

SHEET 24 OF 25

FILE NO.2019-005

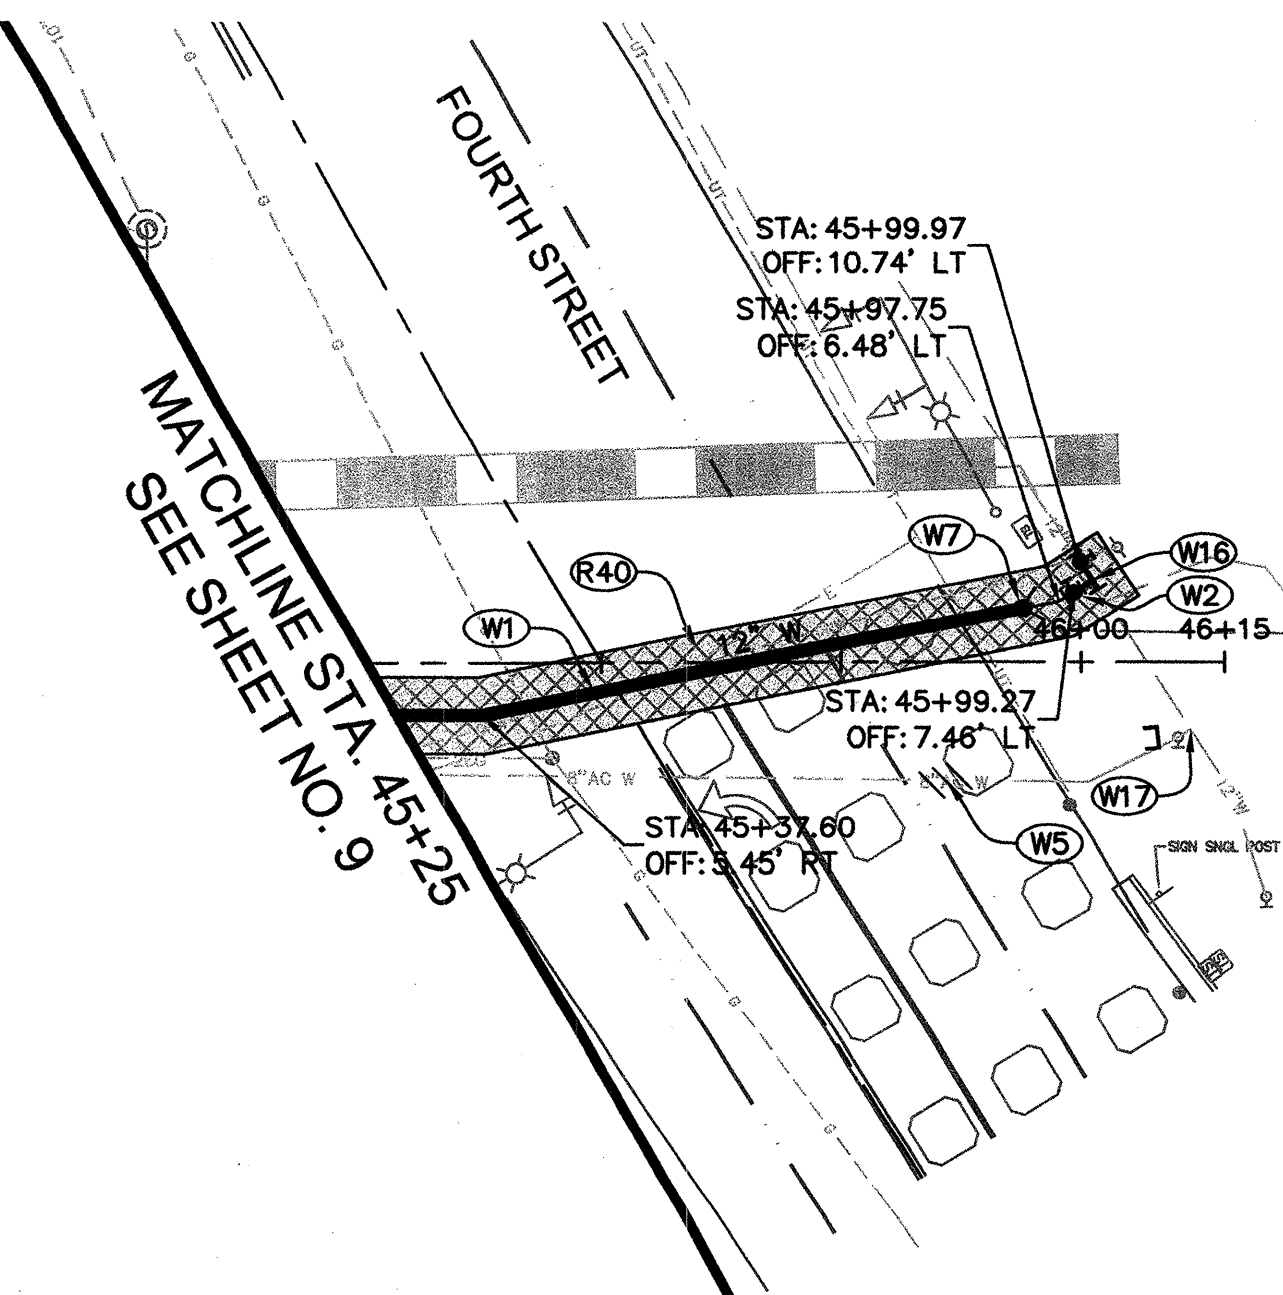

(R40) PLACE PERMANENT TRENCH PAVING PER DETAIL — $\frac{6}{25}$

- (W1) INSTALL WATER MAIN.
- (W2) INSTALL GATE VALVE.
- (W5) REMOVE OR ABANDON EXISTING WATER MAIN PER CITY WATER DISTRIBUTION STANDARD SPECIFICATIONS.
- (W7) INSTALL TEMPORARY BLOW OFF PER CITY STD 859 AND SPECIFICATIONS.
- (W16) INSTALL 12" x 12" TEE AND 12" GATE VALVES ON EXISTING 12" WATER PIPE, CONNECT NEW 12" WATER MAIN TO EXISTING 12" WATER MAIN AS A SINGLE OPERATION UNDER CITY INSPECTION.
- (W17) REMOVE 12" WATER VALVE & TEE INSTALL 12" PVC WATER MAIN AND COUPLERS AS REQUIRED.



 
 
1. EXISTING ROADWAY CROSS SLOPE VARIES. CONTRACTOR SHALL PROVIDE A FINISHED CROSS SLOPE PER CROSS SECTIONS.
2. AC THICKNESS SHALL BE PLACED IN TWO LIFTS, 0.20' AC SURFACE OVER 0.35' AC BASE.
3. ROADWAY EXCAVATION SHALL BE PERFORMED WITH A PAVEMENT GRINDER. NO OTHER CONSTRUCTION EQUIPMENT WILL BE ALLOWED ON THE SUBGRADE UNLESS APPROVED BY THE ENGINEER.
4. THE ASPHALT CONCRETE BASE COURSE SHALL BE PLACED THE SAME DAY THAT AN AREA IS EXCAVATED SO THAT ALL AREAS OF THE STREET WILL HAVE EITHER THE EXISTING PAVEMENT SURFACE OR NEW ASPHALT CONCRETE BASE TO ACCOMMODATE OVERNIGHT TRAFFIC.
5. ROADWAY EXCAVATION AND ASPHALT CONCRETE BASE SHALL BE COMPLETED FOR HALF OF THE STREET WIDTH BEFORE BEGINNING EXCAVATION OF THE OPPOSITE SIDE OF THE STREET. TRUCKS OR CONSTRUCTION EQUIPMENT WILL NOT BE ALLOWED ON NEWLY PLACED ASPHALT CONCRETE BASE UNTIL THE FOLLOWING DAY.
6. THE ASPHALT CONCRETE BASE COURSE SHALL BE PLACED WITH A PAVING MACHINE. THE AC SHALL BE TRANSFERRED FROM TRUCKS TO THE HOPPER OF THE PAVING MACHINE BY MEANS OF A SHOULDER MACHINE EQUIPPED WITH A SIDE CASTER.

NOT TO SCALE



1. SUBGRADE STABILIZATION/DIGOUTS ARE NOT SHOWN ON THE PLAN SHEET. EXACT LOCATIONS SHALL BE MARKED IN THE FIELD BY THE ENGINEER.
2. SUBGRADE STABILIZATION/DIGOUTS SHALL BE PERFORMED AFTER ROADWAY EXCAVATION IS COMPLETE AND PRIOR TO PLACING AC BASE AND STABILIZATION FABRIC.

NOT TO SCALE



1. SEE CITY OF SANTA ROSA STD. 215 FOR ADDITIONAL TRENCH BACKFILL AND PIPE BEDDING DETAILS.
2. NEATLY CUT PAVEMENT AFTER TRENCH IS BACKFILLED TO SUBGRADE.

ADDITIONAL PAVEMENT REMOVAL:
REMOVE ADDITIONAL PAVEMENT TO A PAINTED LANE STRIPE, A LIP OF GUTTER, A CURB, AN EXISTING PAVEMENT PATCH, OR AN EDGE OF PAVEMENT IF SUCH A STREET FEATURE IS WITHIN 3' OF FINAL SAW CUT.

 
NOT TO SCALE



1. TRENCH EXCAVATION AND BACKFILL SHALL CONFORM TO THE REQUIREMENTS OF CITY STD. 215 IN ALL OTHER WAYS.

NOT TO SCALE



By _____	DATE _____	NO. _____	REVISION _____	BY _____
SCALE: AS SHOWN	DATE: FEBRUARY 2024	NO. _____	REVISION _____	BY _____
DWN BY: WJK	CHK BY: SRV	NO. _____	REVISION _____	BY _____
APPROVED: Deputy Director - Engineering		NO. _____	REVISION _____	BY _____
 _____ Date 2/25/2024		NO. _____	REVISION _____	BY _____

CITY OF SANTA ROSA
CAPITAL IMPROVEMENT PROJECT
LA PALOMA AVE, EAST HAVEN DR & ROGERS WY
SEWER AND WATER SYSTEM IMPROVEMENTS

DETAILS

CONTRACT NO.
C00308

SHEET 25 OF 25

FILE NO. 2019-0050